
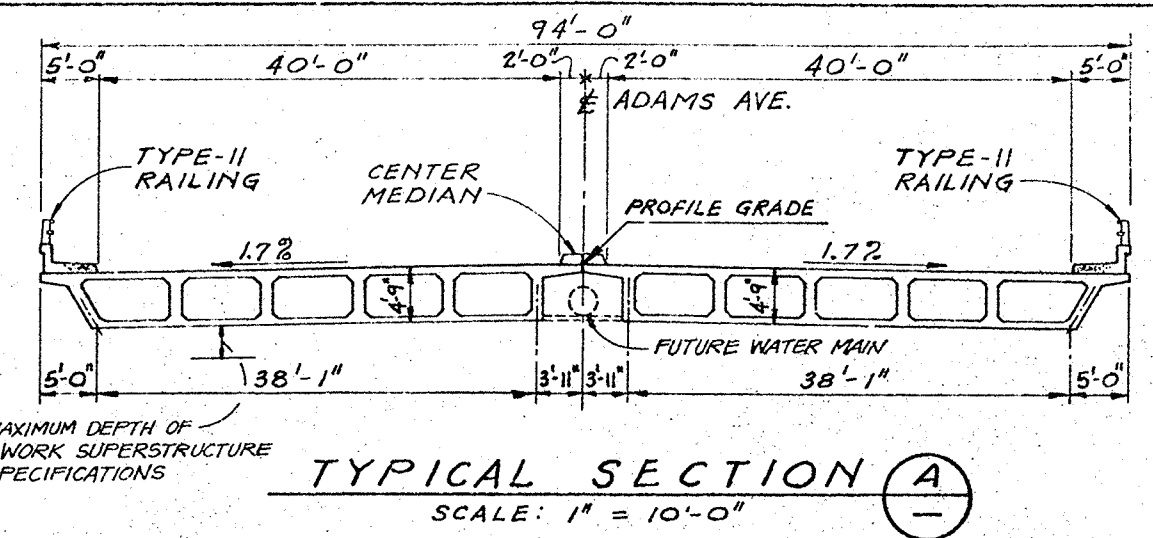


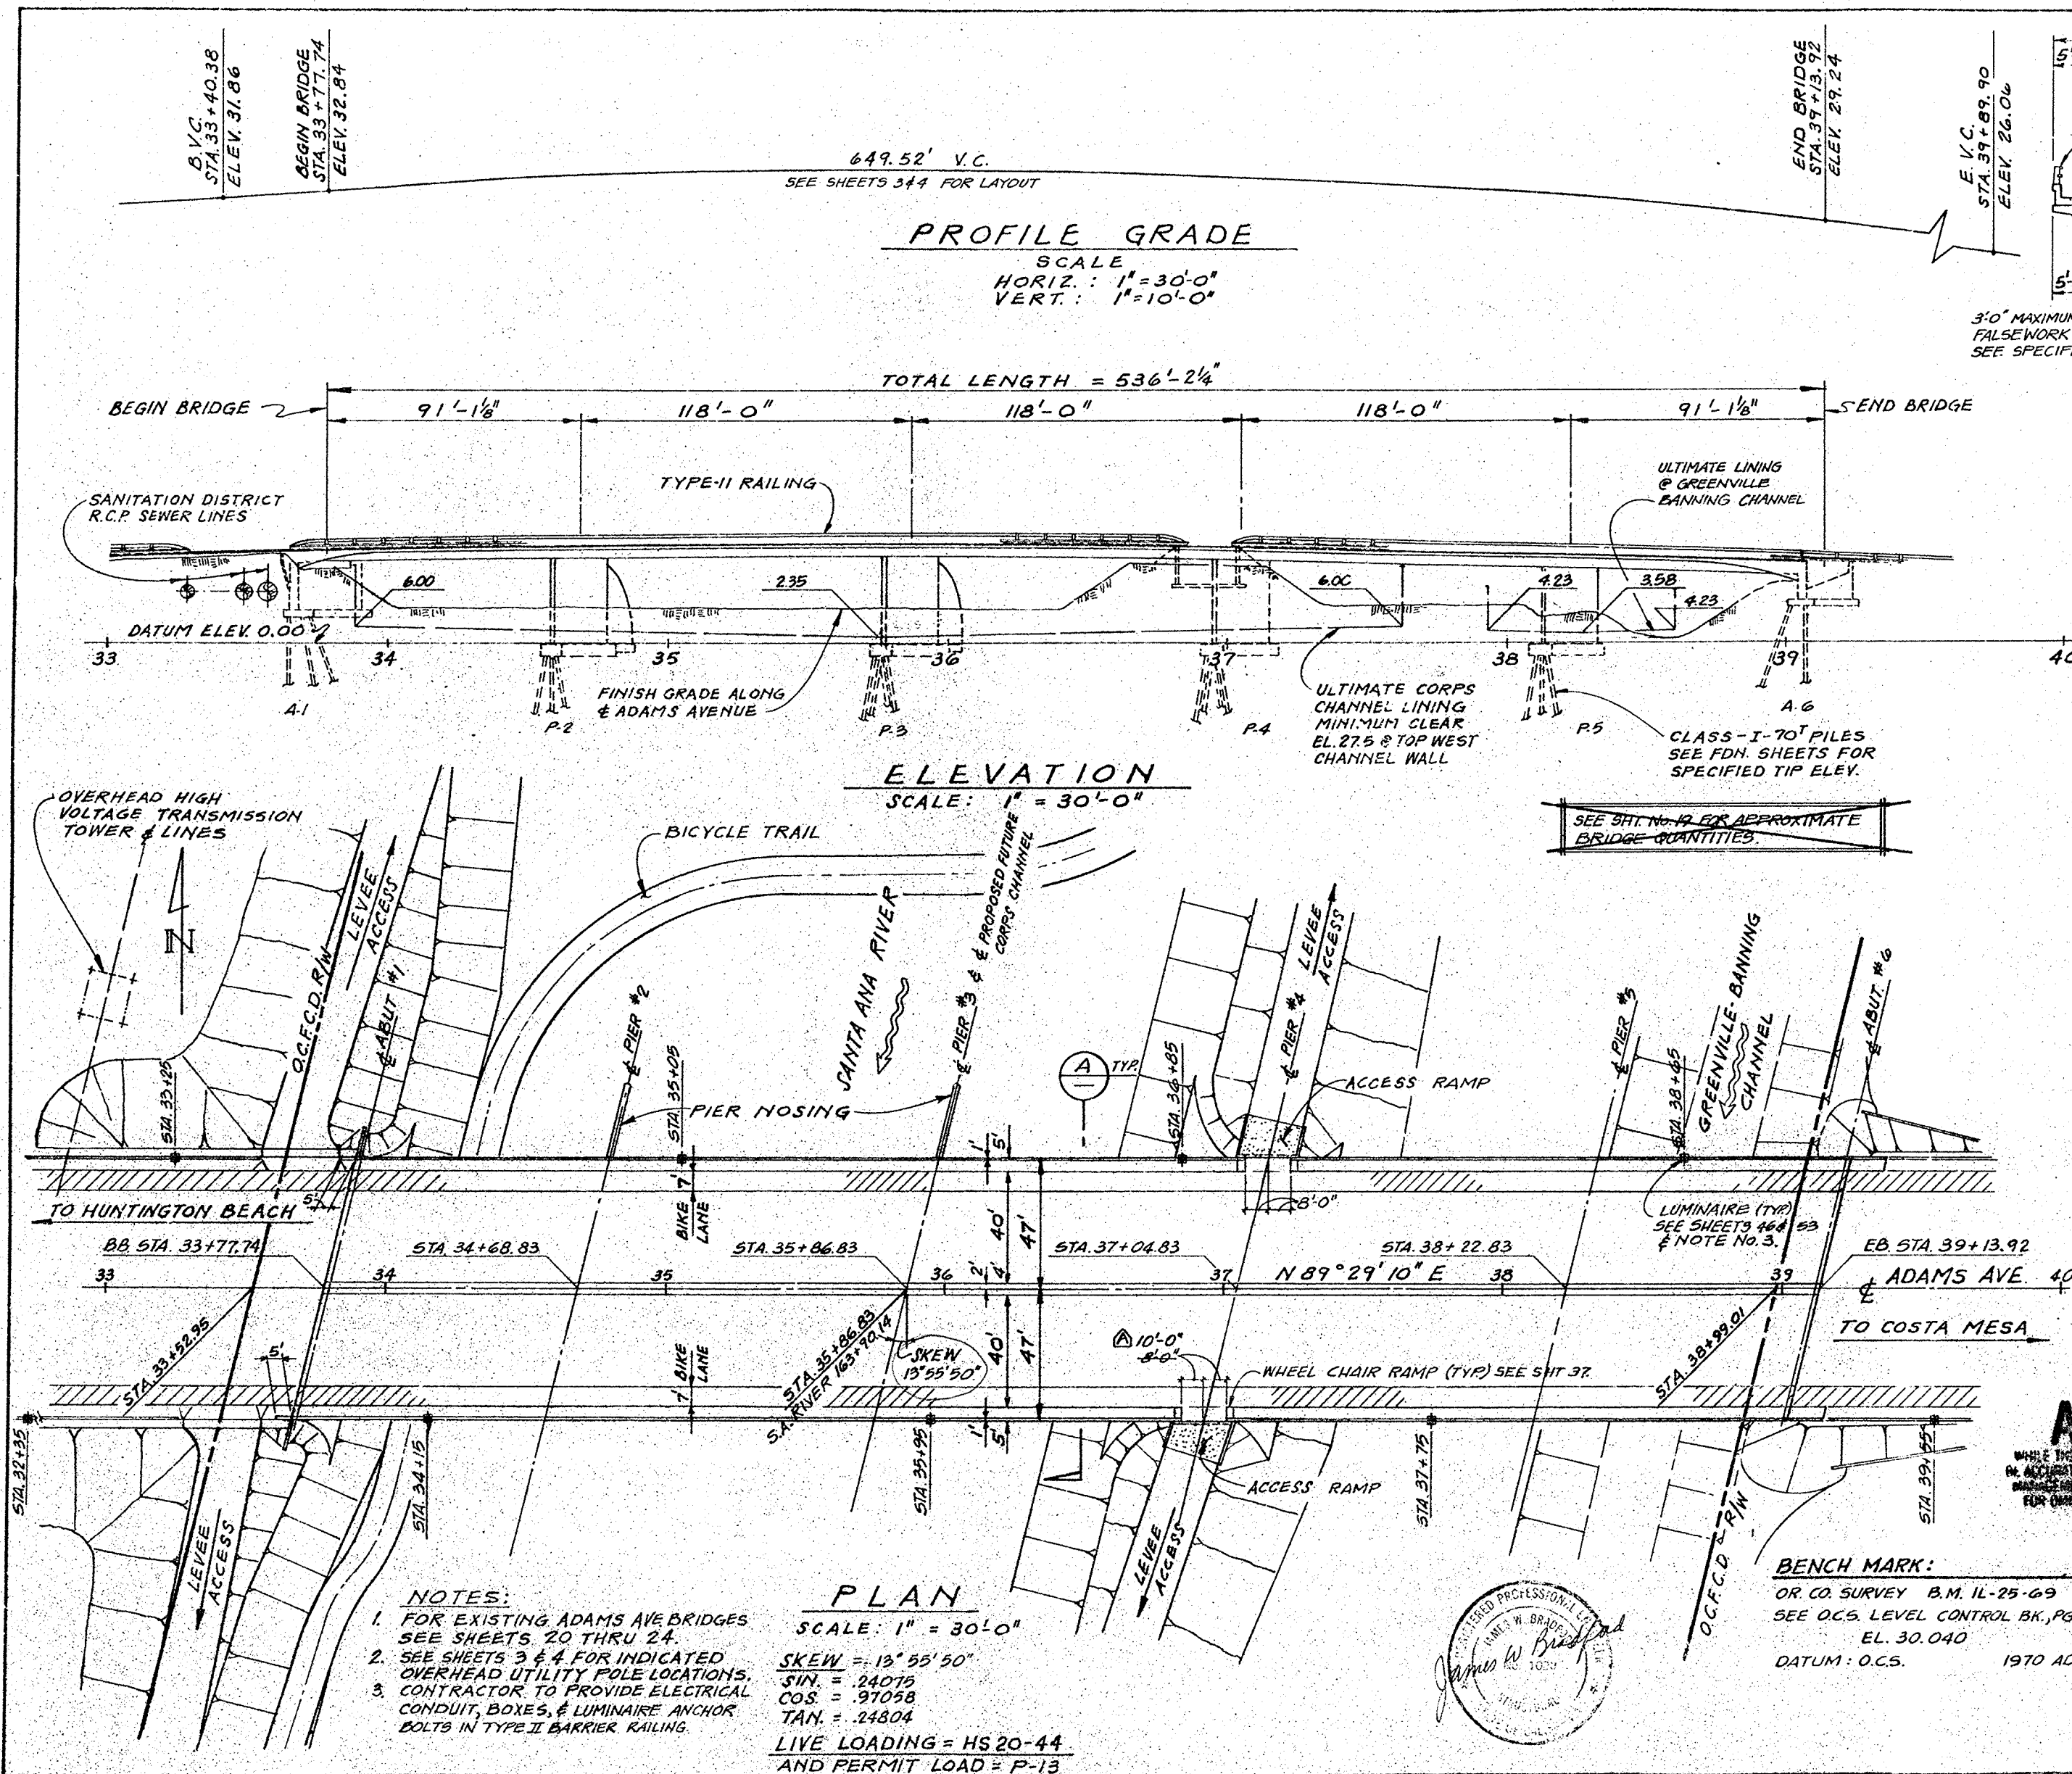

BRIDGE SHEET INDEX

SHEET NO.	TITLE
18	GENERAL PLAN
19	10' GRID DECK ELEVATIONS
20	DEMOLITION GENERAL PLAN
21	DEMOLITION FOUNDATION PLAN
22	DEMOLITION DETAILS - 1
23	DEMOLITION DETAILS - 2
24	DEMOLITION DETAILS - 3
25	FOUNDATION PLAN - 1
26	PIER FOOTING & PILE LAYOUT-PLANS
27	ABUTMENT NO. 1
28	ABUTMENT NO. 6
29	ABUTMENT DETAILS - 1
30	ABUTMENT DETAILS - 2
31	PIER NOS. 2 & 5
32	PIER NOS. 3 & 4
33	PIER NOSING
34	TYPICAL SECTION
35	GIRDER LAYOUT - 1
36	GIRDER LAYOUT - 2
37	GIRDER LAYOUT - 3
38	GIRDER DETAILS
39	PRESTRESSING DETAILS & NOTES
40	PILE DETAILS & NOTES
41	RETAINING WALL - 1
42	RETAINING WALL - 2
43	RETAINING WALL - 3
44	RETAINING WALL DETAILS - 1
45	RETAINING WALL DETAILS - 2
46	BARRIER RAILING TYPE II
47	BARRIER RAILING TYPE II DETAILS
48	EARTHWORK MISCELLANEOUS DETAILS
49	TEMPORARY RAILING DETAILS (TYPES G & K)
50	LOG OF TEST BORINGS NO. 1
51	LOG OF TEST BORINGS NO. 2
52	TYPICAL BRIDGE & RETAINING WALL DETAILS
53	STREET LIGHTING PLAN & DETAILS

AS BUILT
WHILE THE INFORMATION SHOWN IS BELIEVED TO BE ACCURATE, THE ORANGE COUNTY ENVIRONMENTAL MANAGEMENT AGENCY WILL NOT BE RESPONSIBLE FOR OMISSIONS, ERRORS, OR INADEQUACIES.

1 1/2 0 1 2
3 inches on original drawing

ORANGE COUNTY ENVIRONMENTAL MANAGEMENT AGENCY	
ADAMS AVENUE BRIDGE OVER SANTA ANA RIVER	
GENERAL PLAN	
Bridge Plans Dr. # 13329 Sheet 18 of 23 Rev. # 24.1 Type: ** Linen	PREPARED UNDER SUPERVISION OF RCE 6654 DATE 18
DESIGNED: D.S. SCHERSCHER DRAWN: W.B.S. / J.W.B.	SCALE: AS SHOWN DATE: APRIL 1977 DWG. NO. SA. 35 OF 53

PR#7 13329