
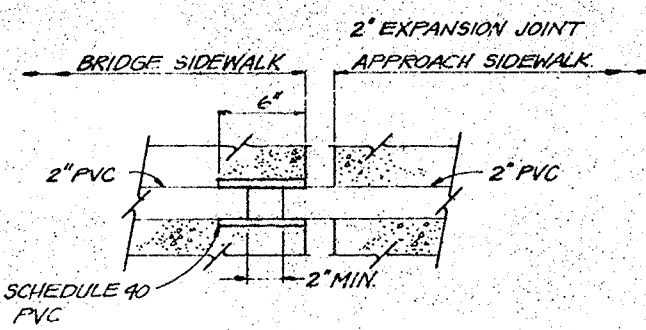
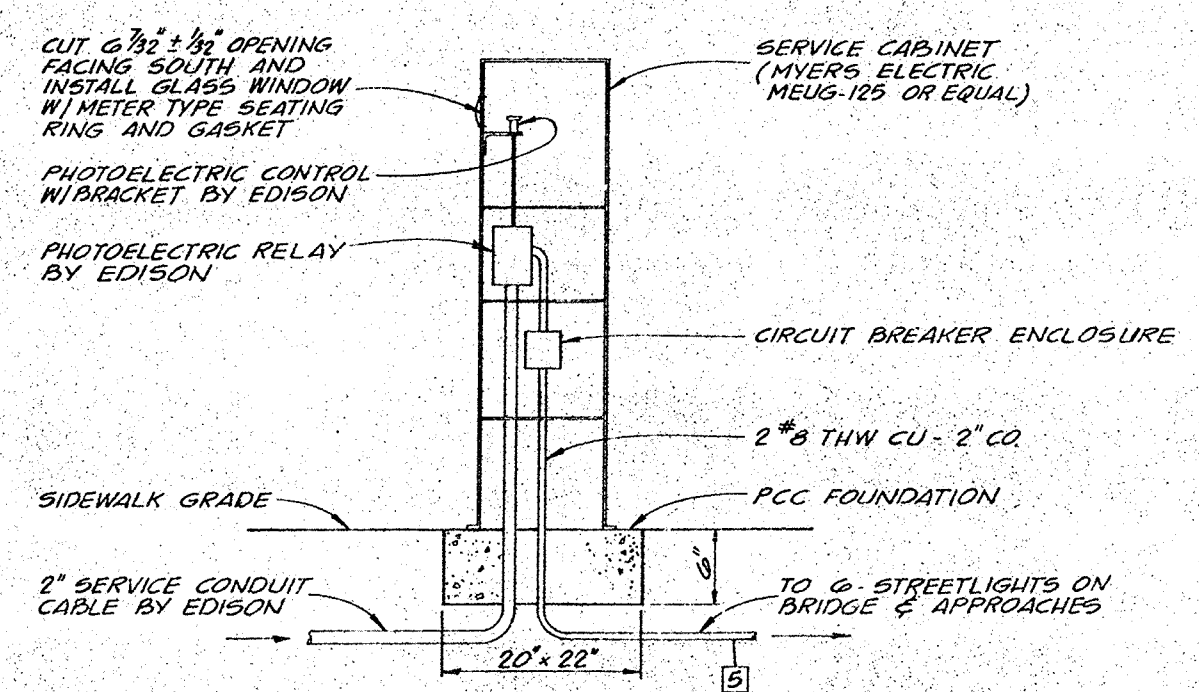
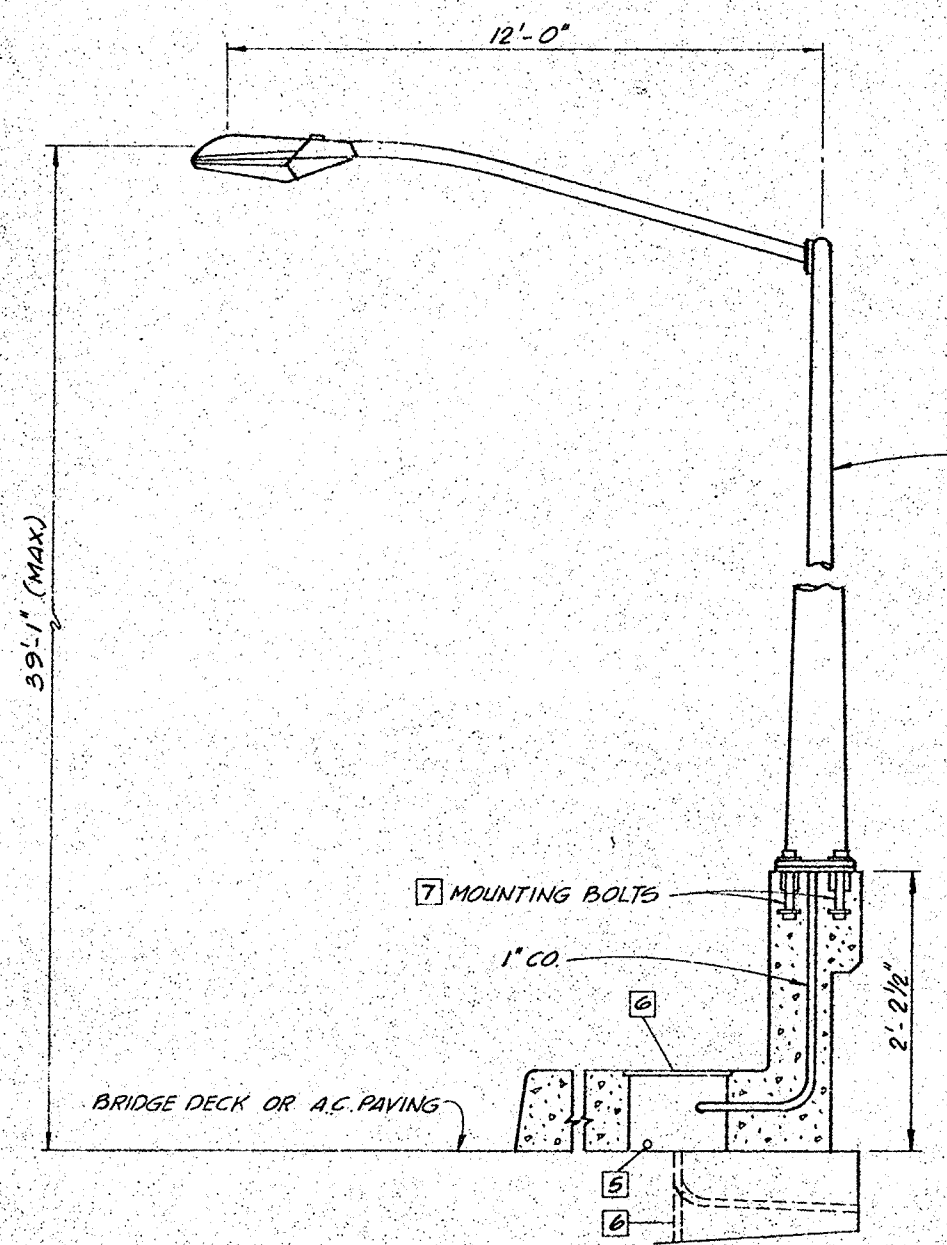


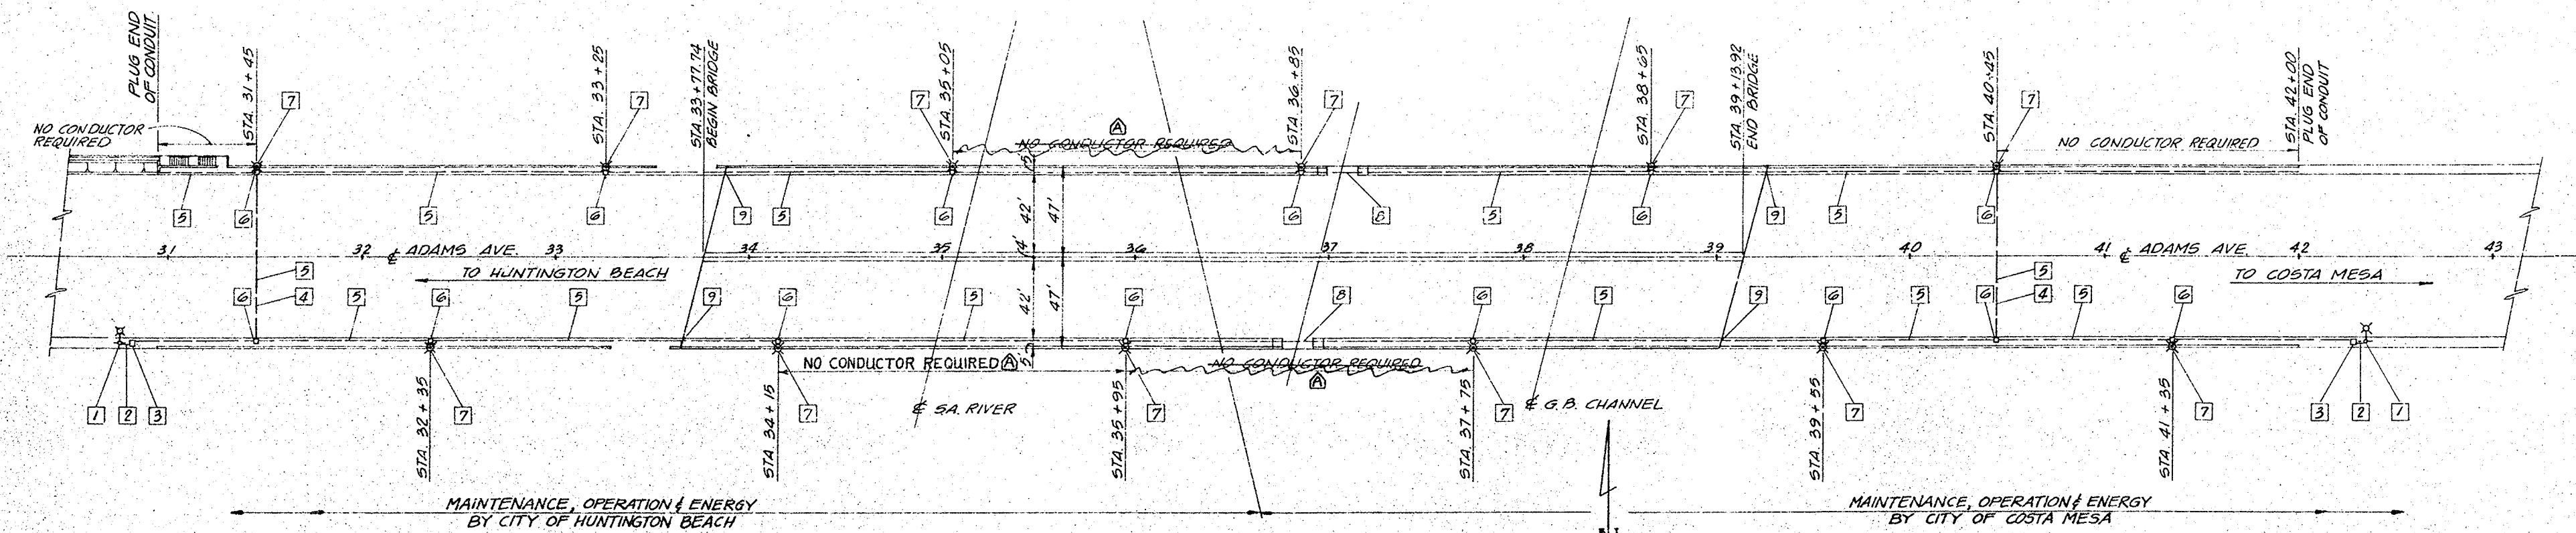

ELECTRICAL NOTES:

- 1 - EXIST. EDISON CO FEED POINT FOR BRIDGE LIGHTING
- 2 - INSTALL 2" CO PVC SCHEDULE 40 FROM EDISON CO SERVICE POINT TO UNDERGROUND SERVICE PEDESTAL. SERVICE CONDUCTORS BY EDISON.
- 3 - INSTALL MYERS ELECTRIC MEUG-125 SERVICE CABINET OR APPROVED EQUAL.
- 4 - INSTALL 2" CO PVC SCHEDULE 40 W/ 3" CONC. ENCASEMENT.
- 5 - INSTALL 2" #8 THW CU & 2" CO PVC SCHEDULE 40. (SEE SHEET 46)
- 6 - INSTALL PULLBOX PER CALTRANS DWG. ES-7A (TYPE-2). WITH 3/4" DRAIN THROUGH BRIDGE DECK, GRADE BEAM OR RETAINING WALL.
- 7 - 1 1/2" DIA. MOUNTING BOLTS, 11 1/2" BOLT CIRCLE, WITH ANCHOR PLATE PER CALTRANS SHEET ES-7B.
- 8 - INSTALL 2" PVC SCHEDULE 40 CONDUIT IN TOP SLAB OF BRIDGE STRUCTURE AT PIER & RAMP AREA.
- 9 - PROVIDE EXPANSION JOINT PER DETAIL (3)

1 1/2 0 1 2
3 inches on original drawing

AS BUILT

WHILE THE INFORMATION SHOWN IS BELIEVED TO BE ACCURATE, THE ORANGE COUNTY ENVIRONMENTAL MANAGEMENT AGENCY WILL NOT BE RESPONSIBLE FOR OMISSIONS, ERRORS, OR INACCURACIES.

Bridge Plans
Sheet 53 of 53
Revised 24-1-77
Type: A. L. L.

ORANGE COUNTY ENVIRONMENTAL MANAGEMENT AGENCY	
ADAMS AVENUE BRIDGE OVER SANTA ANA RIVER	
STREET LIGHTING PLAN AND DETAILS	
DESIGNED: C.A.C.	DRAWN: H.R.R.
CHECKED: C.A.C.	APPROVED: C.A.C.
DATE: 4/2/77	DATE: 4/2/77
SCALE: 1"=40'	DWG. NO. SA 35
SHEET 53	OF 53

73329