

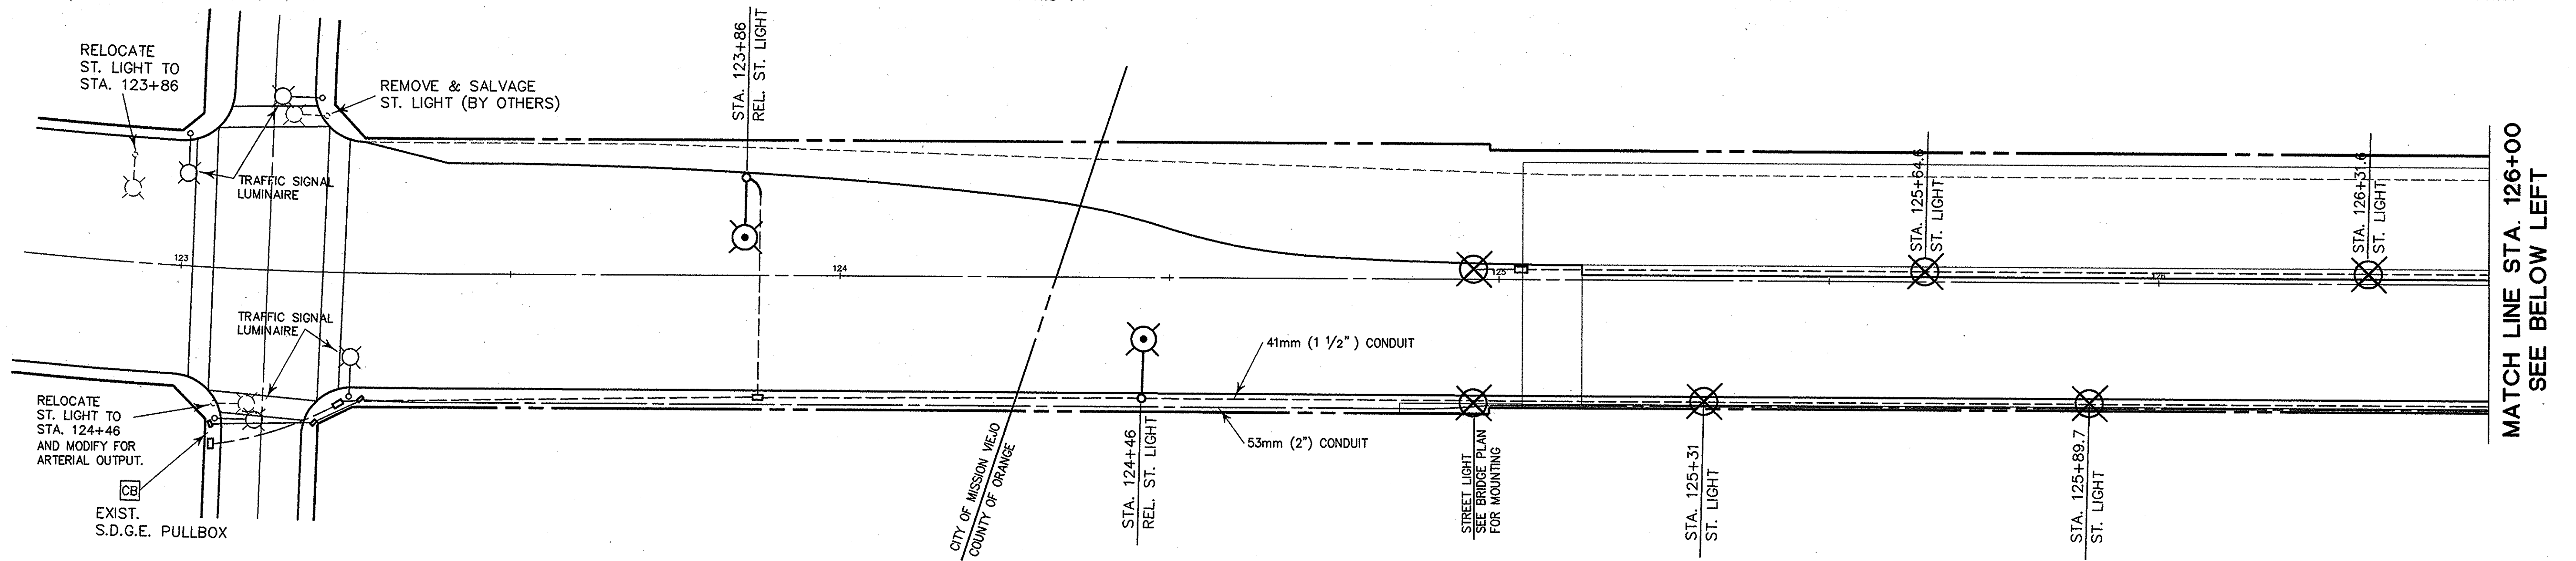


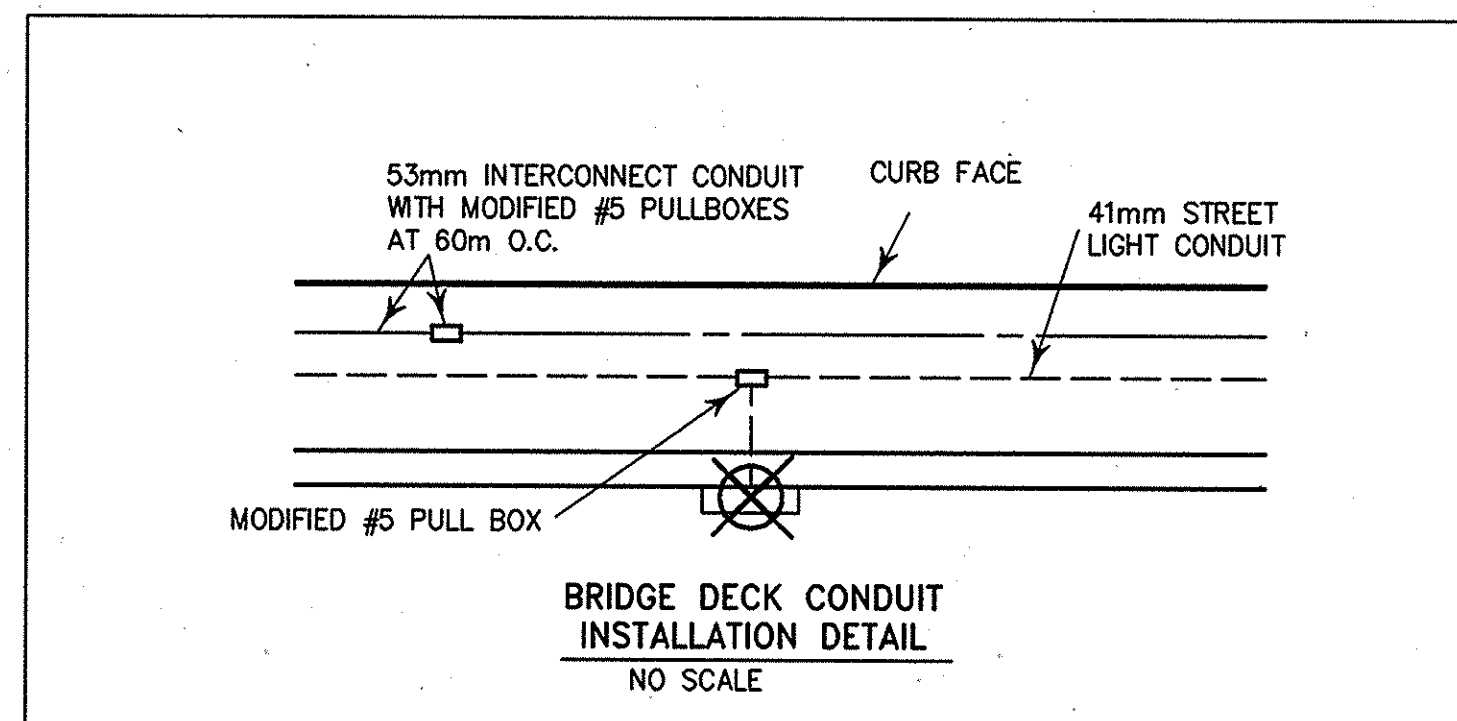


SEE ABOVE RIGHT
MATCH LINE STA. 126+00

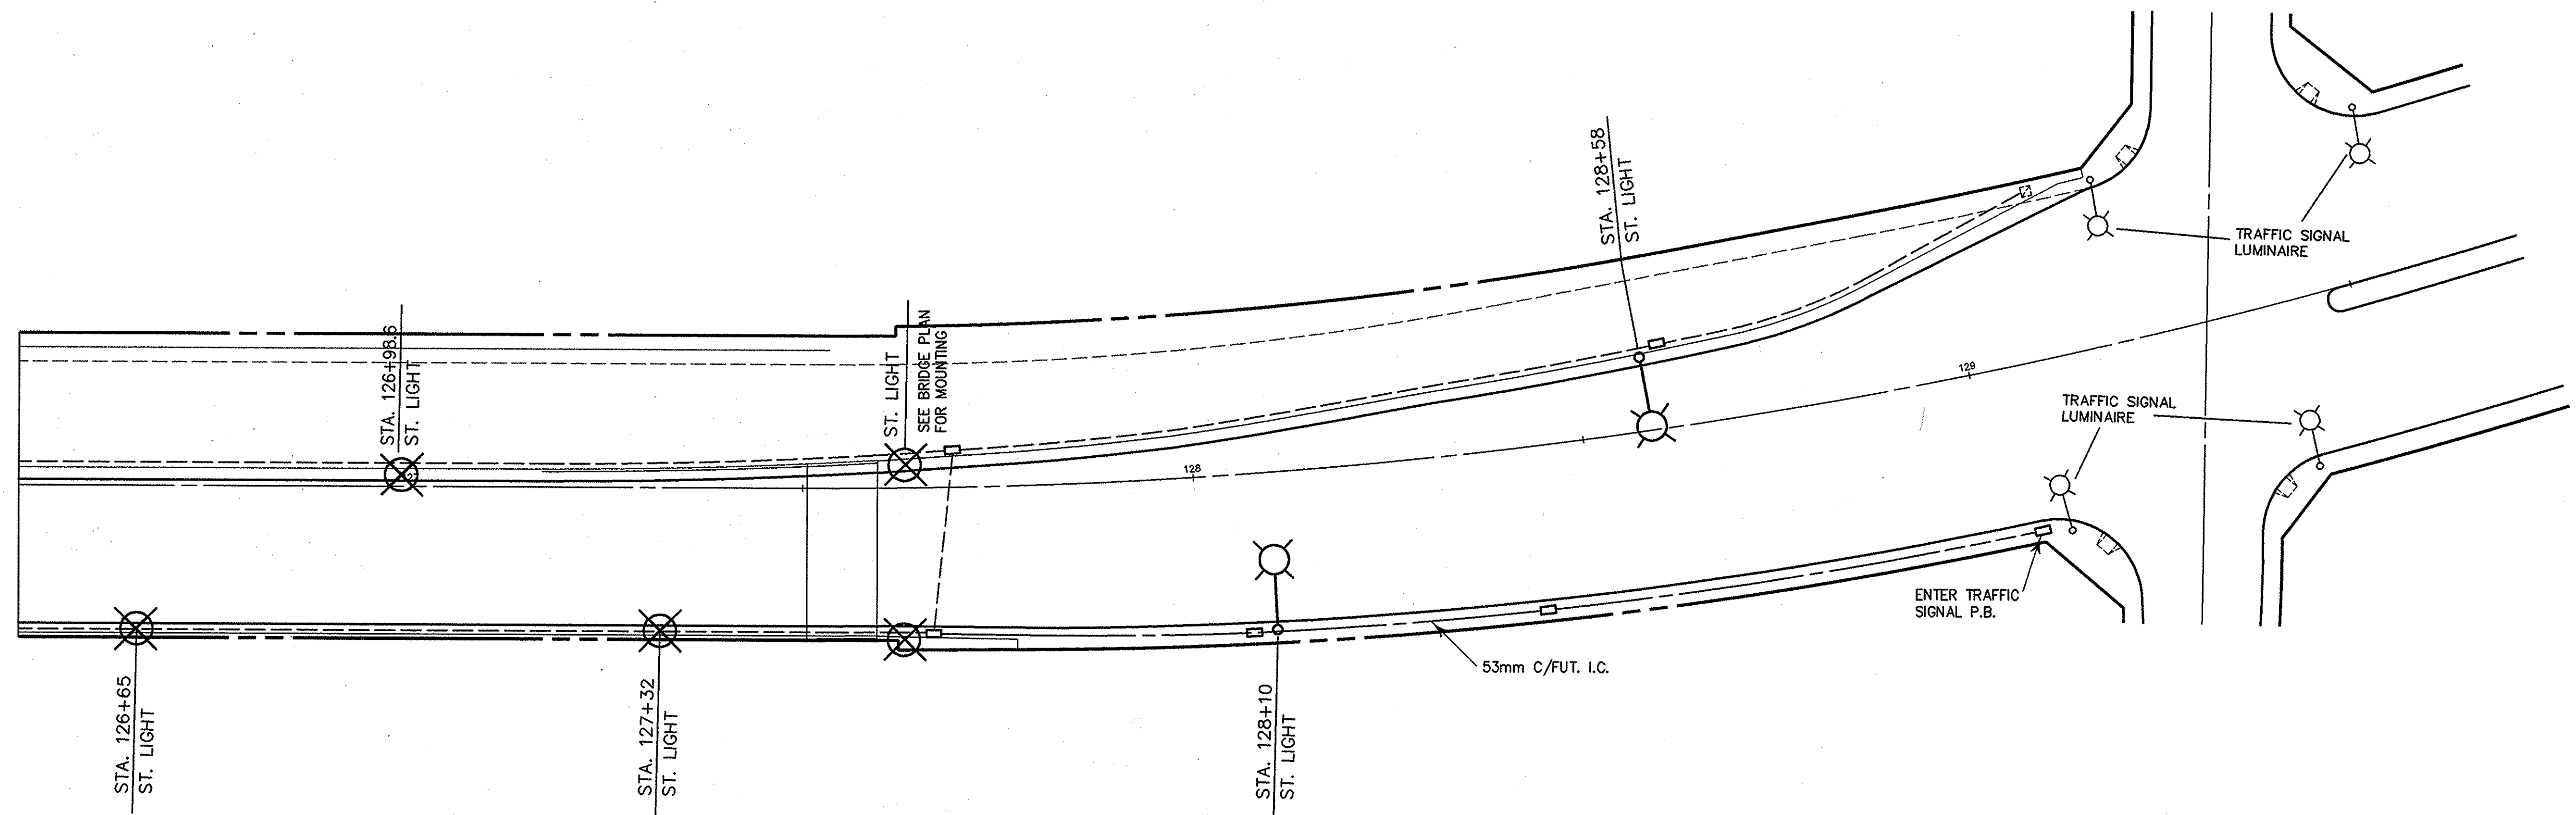

LEGEND

- EXISTING STREET LIGHT
- CONSTRUCT STREET LIGHT PER P.F.R.D. STD. PLAN 1411 OR RELOCATE AS SHOWN.
- TRAFFIC SIGNAL STANDARD/LUMINAIRE/SAFETY LIGHTING
- BRIDGE STREET LIGHT (SEE BRIDGE PLANS FOR DETAILS).
- CITY OF MISSION VIEJO MISSION BELL FIXTURE. RELOCATE FROM JARDINES AVE. CHANGE LAMP FIXTURE TO PROVIDE ARTERIAL LIGHTING LEVELS. TO BE INSTALLED BY S.D.G. & E.
- STREET LIGHTING CONDUIT.
- SIGNAL INTERCONNECT CONDUIT.
- No. 5 PULL BOX (MODIFY FOR BRIDGE DECK INSTALLATION).

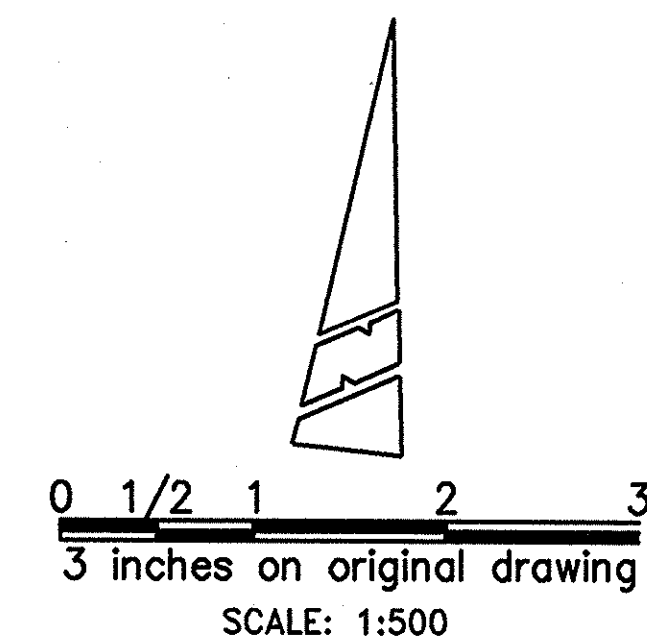

WPA TRAFFIC ENGINEERING, INC.
TRAFFIC AND TRANSPORTATION ENGINEERING
23421 SOUTH POINTE DRIVE SUITE 190 LAGUNA HILLS, CA. 92653 (949) 480-0110

ALL DIMENSIONS ARE IN METERS UNLESS SHOWN OTHERWISE

ORANGE COUNTY PUBLIC FACILITIES AND RESOURCES DEPARTMENT	
STREET LIGHTING PLAN	
Crown Valley Pkwy.	
FROM	
STA. 123+00 TO STA. 129+50	
DESIGNED: RLM	CHECKED: [Signature]
SCALE: 1:500	DATE: 6/99
DRAWING NO. 47	

REVISIONS
PREPARED UNDER RESPONSIBLE CHARGE OF:
[Signature]
[Stamp: REGISTERED PROFESSIONAL ENGINEER, No. 16828, EXP. 6/30/01, STATE OF CALIFORNIA]

CHANGED BY ASBUILT
SHT. 9 (this sheet still keeping)

