




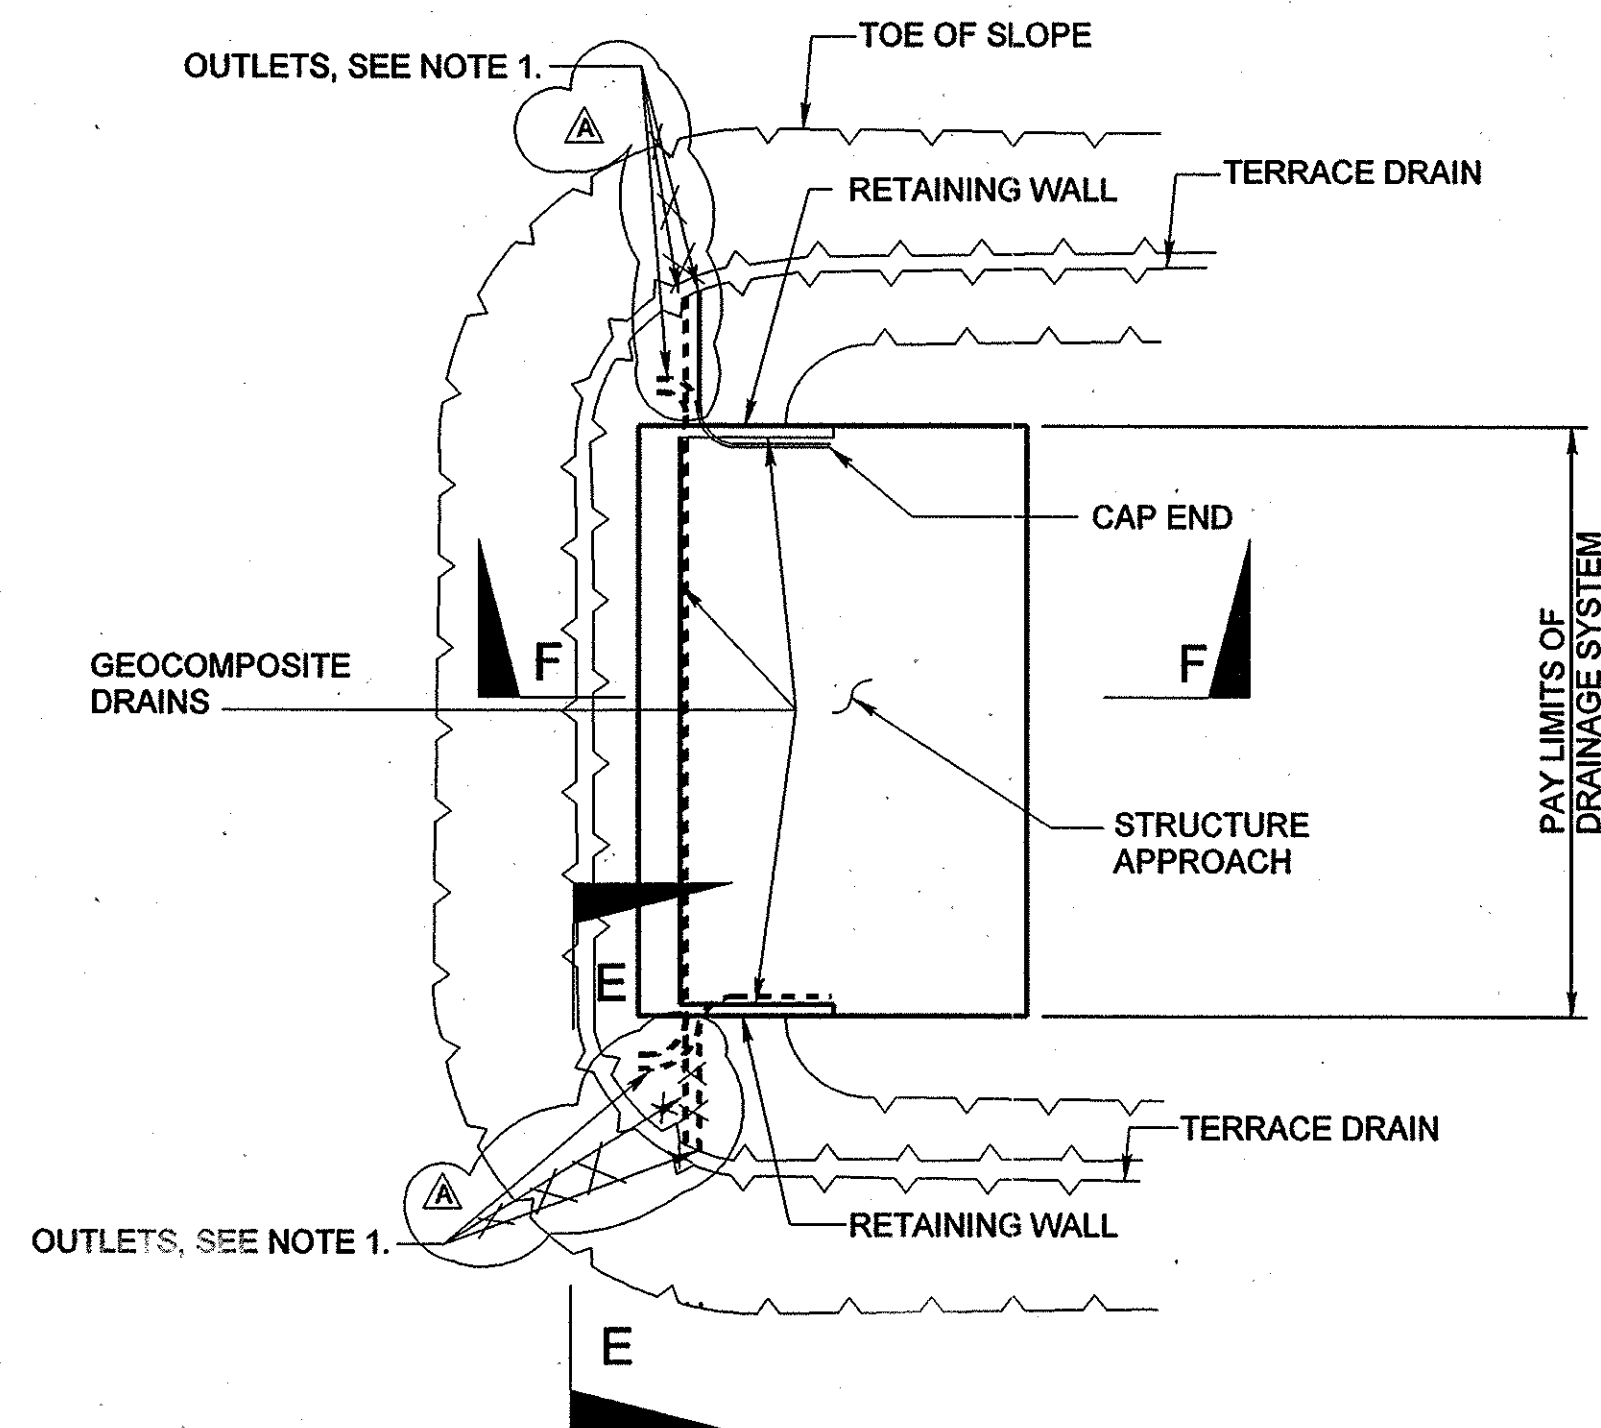


TYPICAL PLAN
Not To Scale

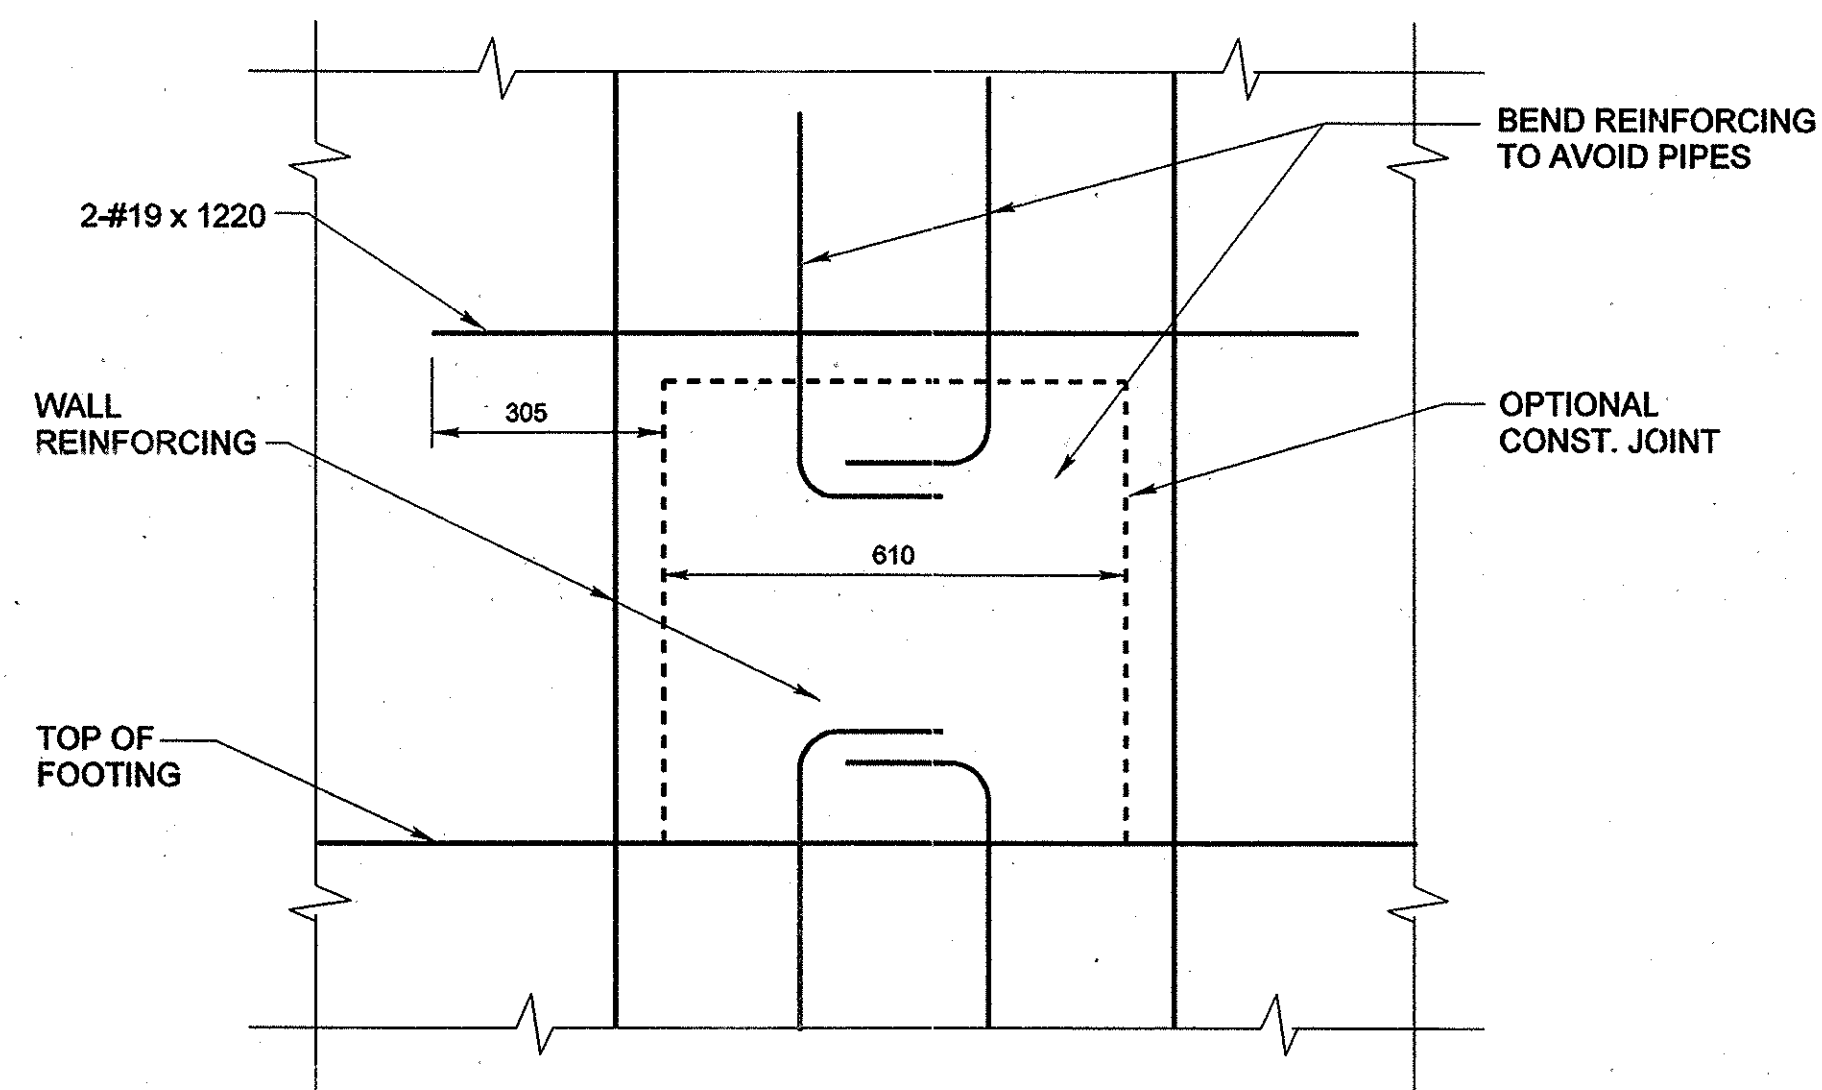

SECTION H-H
1:10

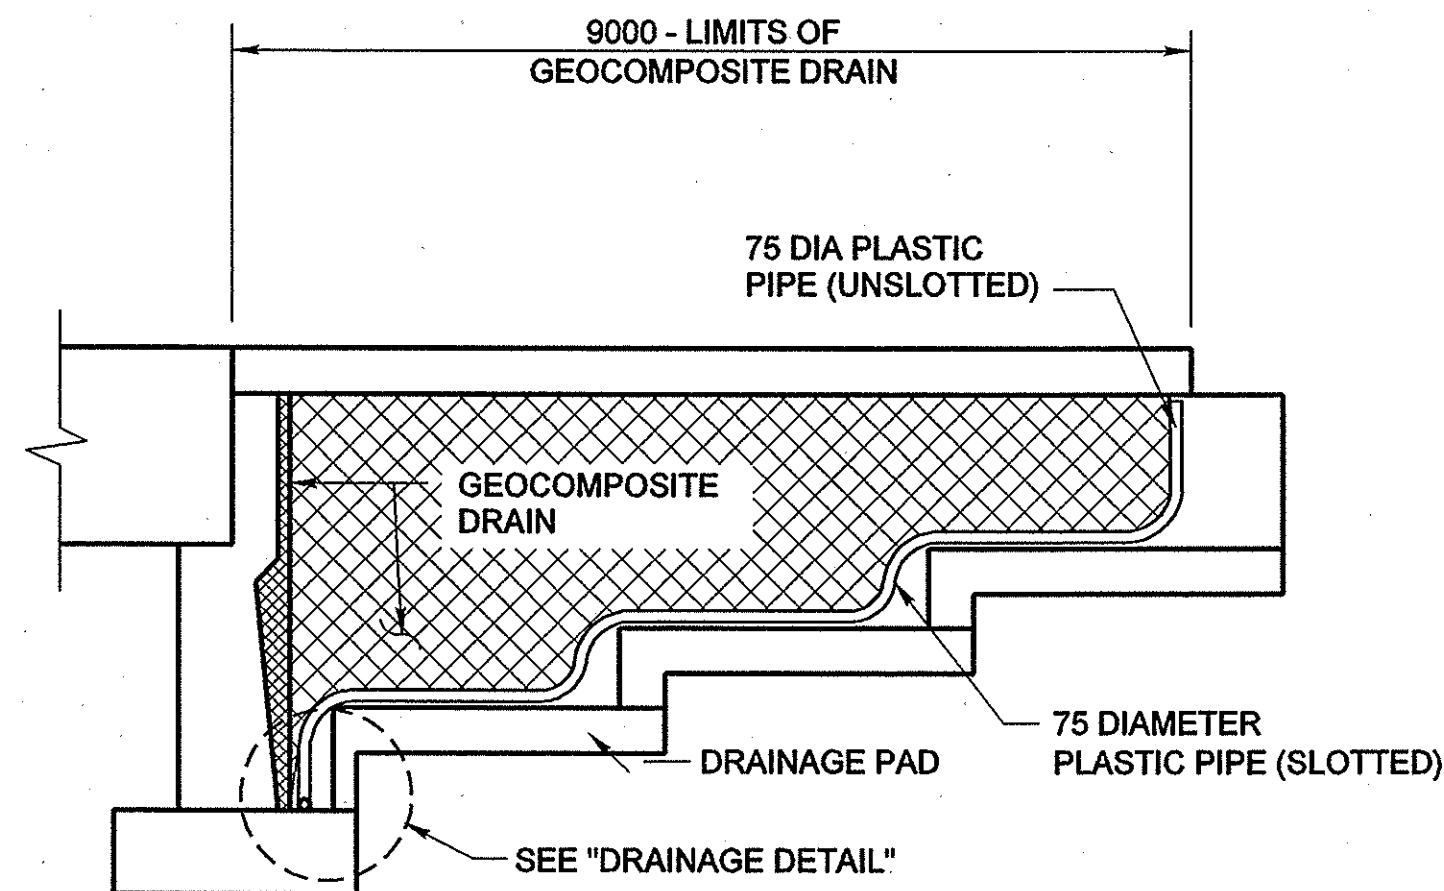


RETAINING WALL WINGWALL SECTION F-F
Not To Scale

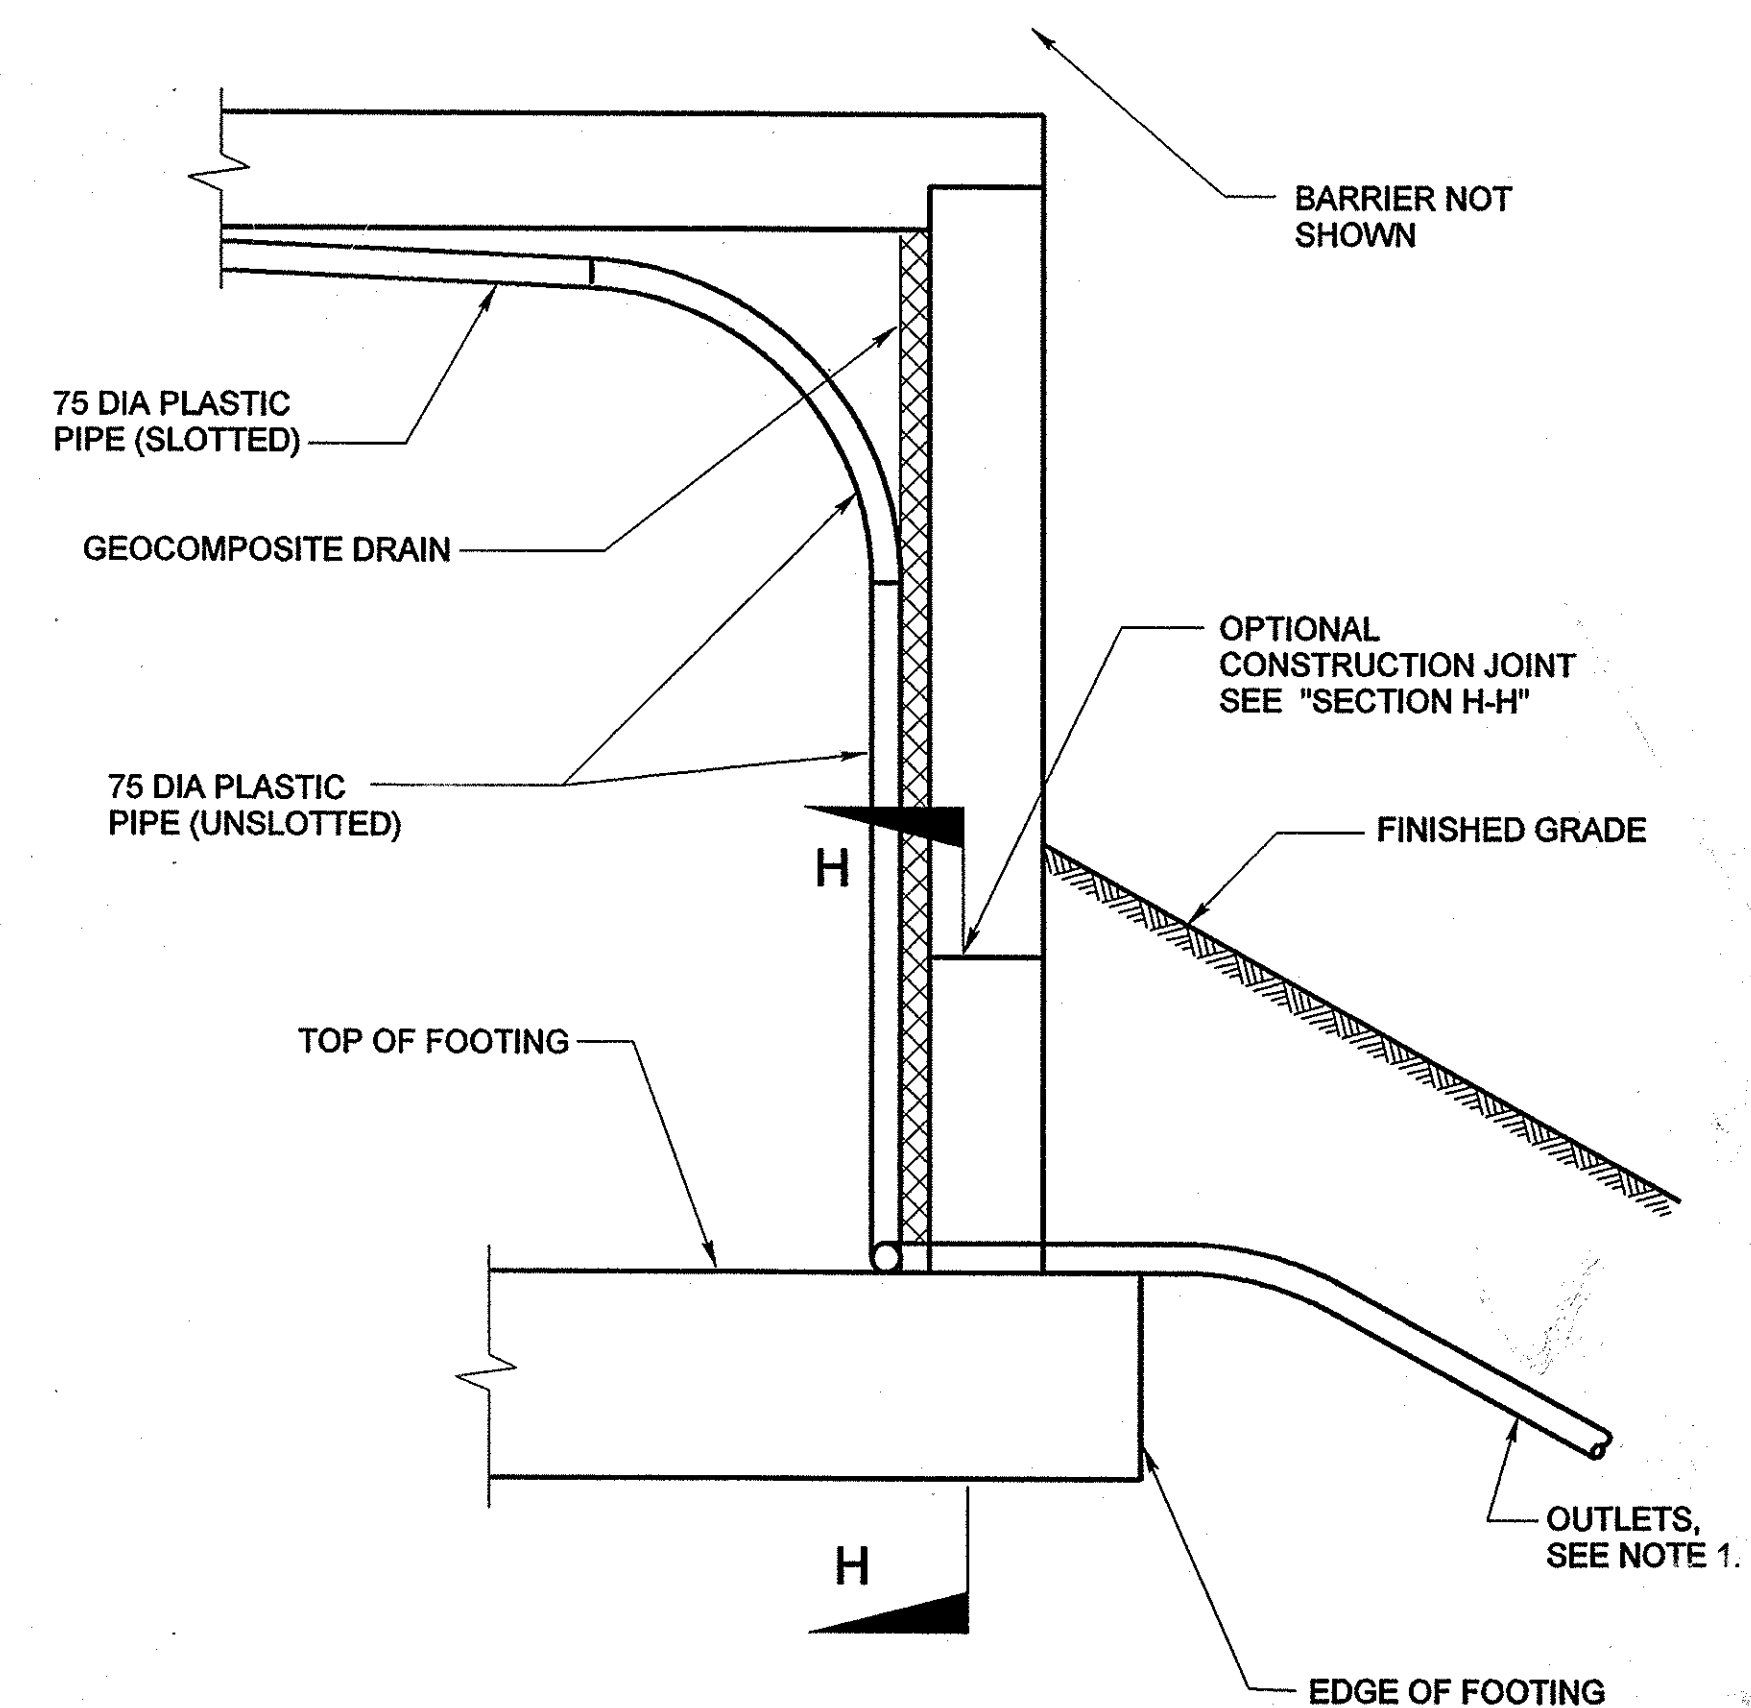


SECTION E-E
1:20

NOTES:

1. OUTLET TO TERRACE DRAINS, SEE "SLOPE PAVING DETAILS- FULL SLOPE NO. 2" SHEET.
2. BENDS AND JUNCTIONS IN 75 mm PLASTIC PIPE ARE 765 mm RADIUS MIN.

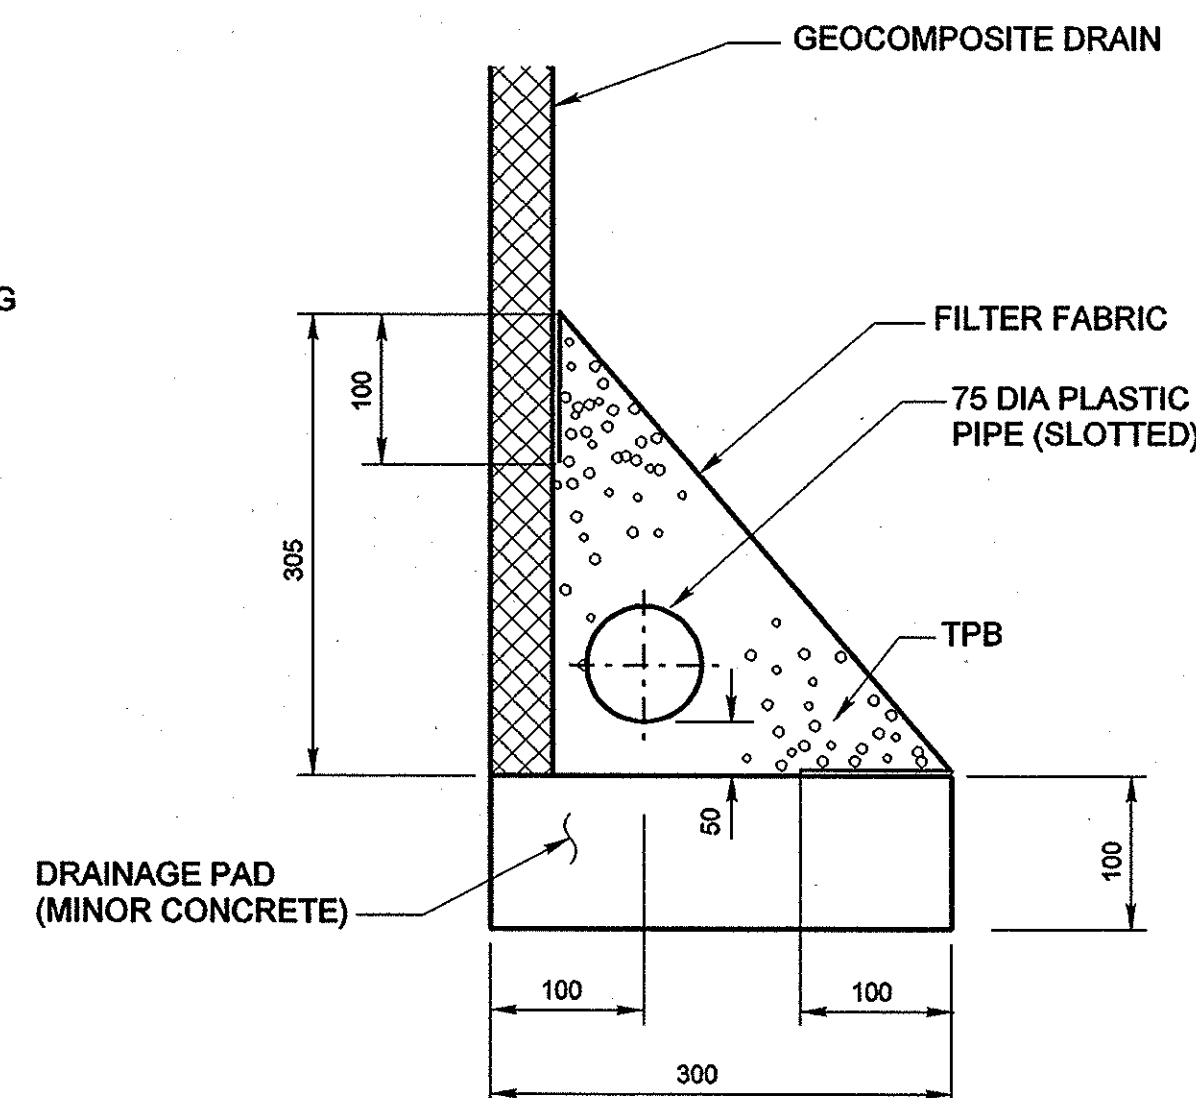


WITHOUT FOOTING

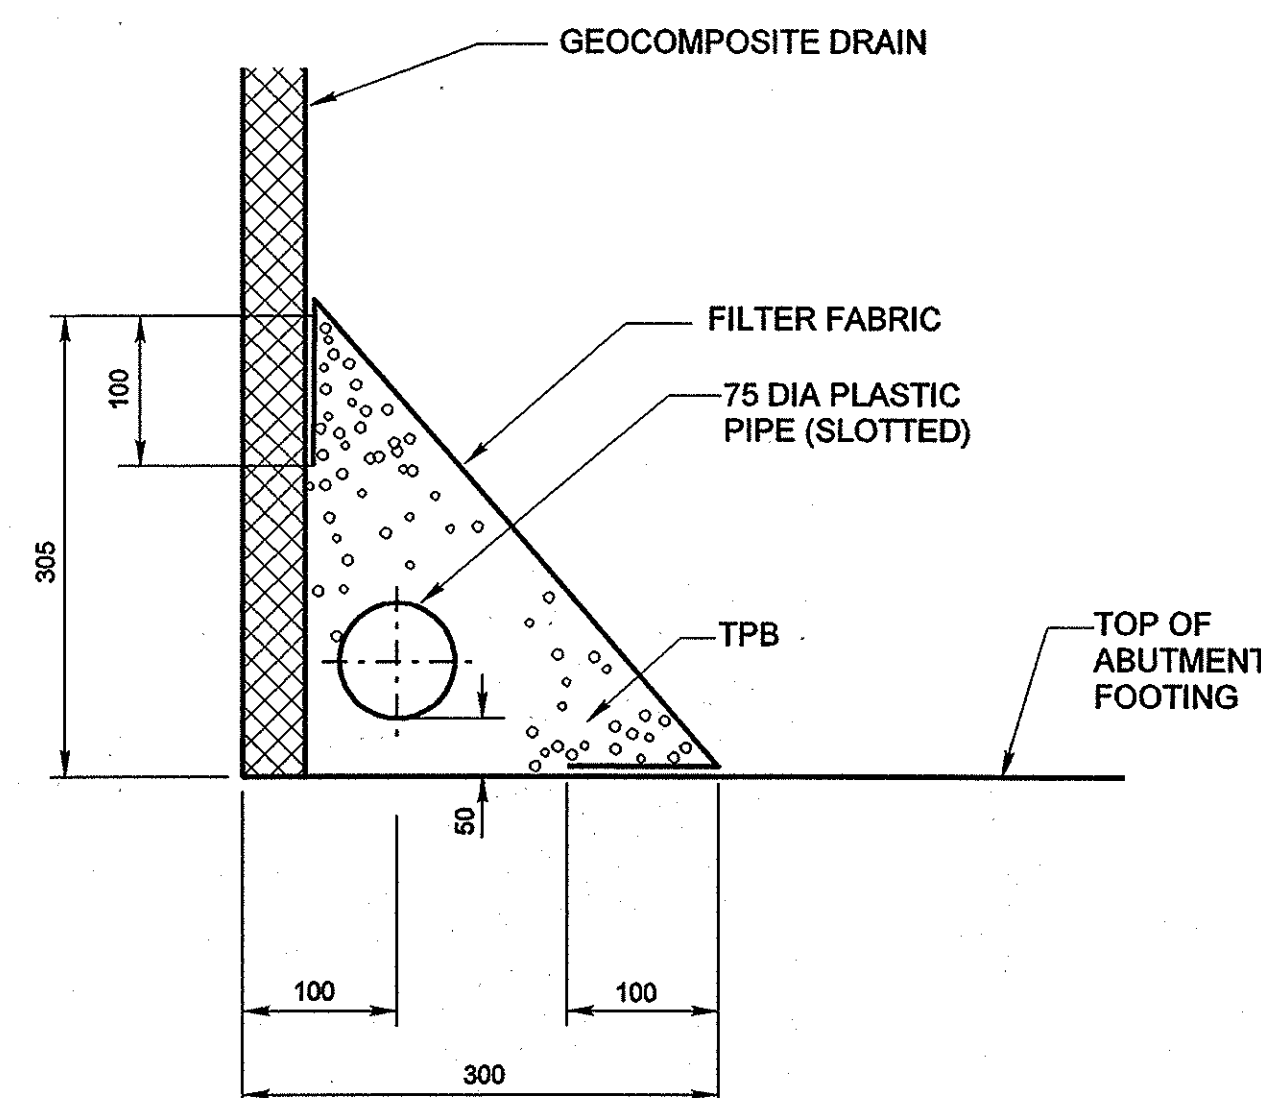

WITH FOOTING

DRAINAGE DETAIL
1:5

 FOR REDUCED PLANS ORIGINAL
SCALE IS IN MILLIMETERS



MK CENTENNIAL
CENTENNIAL ENGINEERING, INC.
17300 REDHILL AVENUE
SUITE 150
IRVINE, CA 92614

ALL DIMENSIONS ARE IN MILLIMETERS UNLESS NOTED OTHERWISE.

ORANGE COUNTY PUBLIC FACILITIES AND RESOURCES DEPARTMENT	
CROWN VALLEY PARKWAY BRIDGE WIDENING OVER ARROYO TRABUCO STRUCTURE APPROACH DRAINAGE DETAILS	
DESIGNED BY: HILTON L. YEE	SHEET 43 OF 47
DRAWN BY: P. MURPHY, ET AL	CHECKED BY: XIAN WU
SCALE: AS SHOWN	DATE: JUNE 15, 1999
DRAWING NO.	

MARK	DATE	DESCRIPTION
11-01-01	AS BUILT	
REVISIONS		
PREPARED UNDER RESPONSIBLE CHARGE OF:		

File Name: \$DGN-FILE-NAMES
Date Plotted: dd-mm-yyyy hh:mm