

CURVE DATA				
NO.	R	Δ	T	L
(A)	716.244	34°58'41"	225.680	437.253
(B)	60.000	12°26'35"	6.541	13.031
(C)	60.000	10°17'14"	5.401	10.773
(D)	90.130	07°38'16"	6.016	12.015
(E)	0.302	171°24'21"	3.978	0.903

NOTES:
1. UTILITIES TO BE INSTALLED BY UTILITY COMPANIES ARE NOT SHOWN. SEE OTHER PLAN SHEETS AND SPECIAL PROVISIONS.

- LEGEND:
- ① PROTECT IN PLACE
 - ② JOIN
 - ③ REMOVE
 - ④ SAWCUT


CONSTRUCTION NOTES

- 1 CONSTRUCT 315 mm AC OVER NATIVE SOIL
- 2 CONSTRUCT PCC CURB & GUTTER TYPE A2-200(8) PER PFRD STD PLAN 120-1-OC OVER 200 mm AGGREGATE BASE
- 3 CONSTRUCT PCC SIDEWALK PER PFRD STD PLAN 1205
- 4 CONSTRUCT PCC CURB TYPE C1-200(8) PER PFRD STD PLAN 120-1-OC
- 5 CONSTRUCT INLET TYPE II PER PFRD STD PLAN 1302
- 6 CONSTRUCT LOCAL DEPRESSION PER PFRD STD PLAN 1308 AND DETAIL A ON SHEET 6
- 7 CONSTRUCT CURB & GUTTER TRANSITION FROM A2-200(8) TO A2-200(8) W/O GUTTER
- 8 INSTALL 7.62 m OF METAL BEAM GUARD RAIL (TYPE 1A LAYOUT, CONNECT TO BARRIERWALL) PER CALTRANS STD PLAN RSP A77D
- 9 INSTALL TERMINAL SYSTEM (TYPE SRT) PER CALTRANS STD PLAN NSPA77L
- 10 CONSTRUCT 100 mm STAMPED CONCRETE
- 11 COLD PLANE 38 mm AC PAVEMENT
- 12 CONSTRUCT 38 mm RUBBERIZED AC

UTILITIES

OWNER

A	GAS LINE	THE GAS COMPANY
B	WATER LINE	SANTA MARGARITA WATER DISTRICT
C	ELECTRICAL LINE	SDG&E
D	SEWER LINE	ORANGE COUNTY SANITATION DISTRICT
E	FUEL LINE	SANTA FE PACIFIC
F	TELEPHONE LINE	PACIFIC BELL
G	CABLE LINE	COX

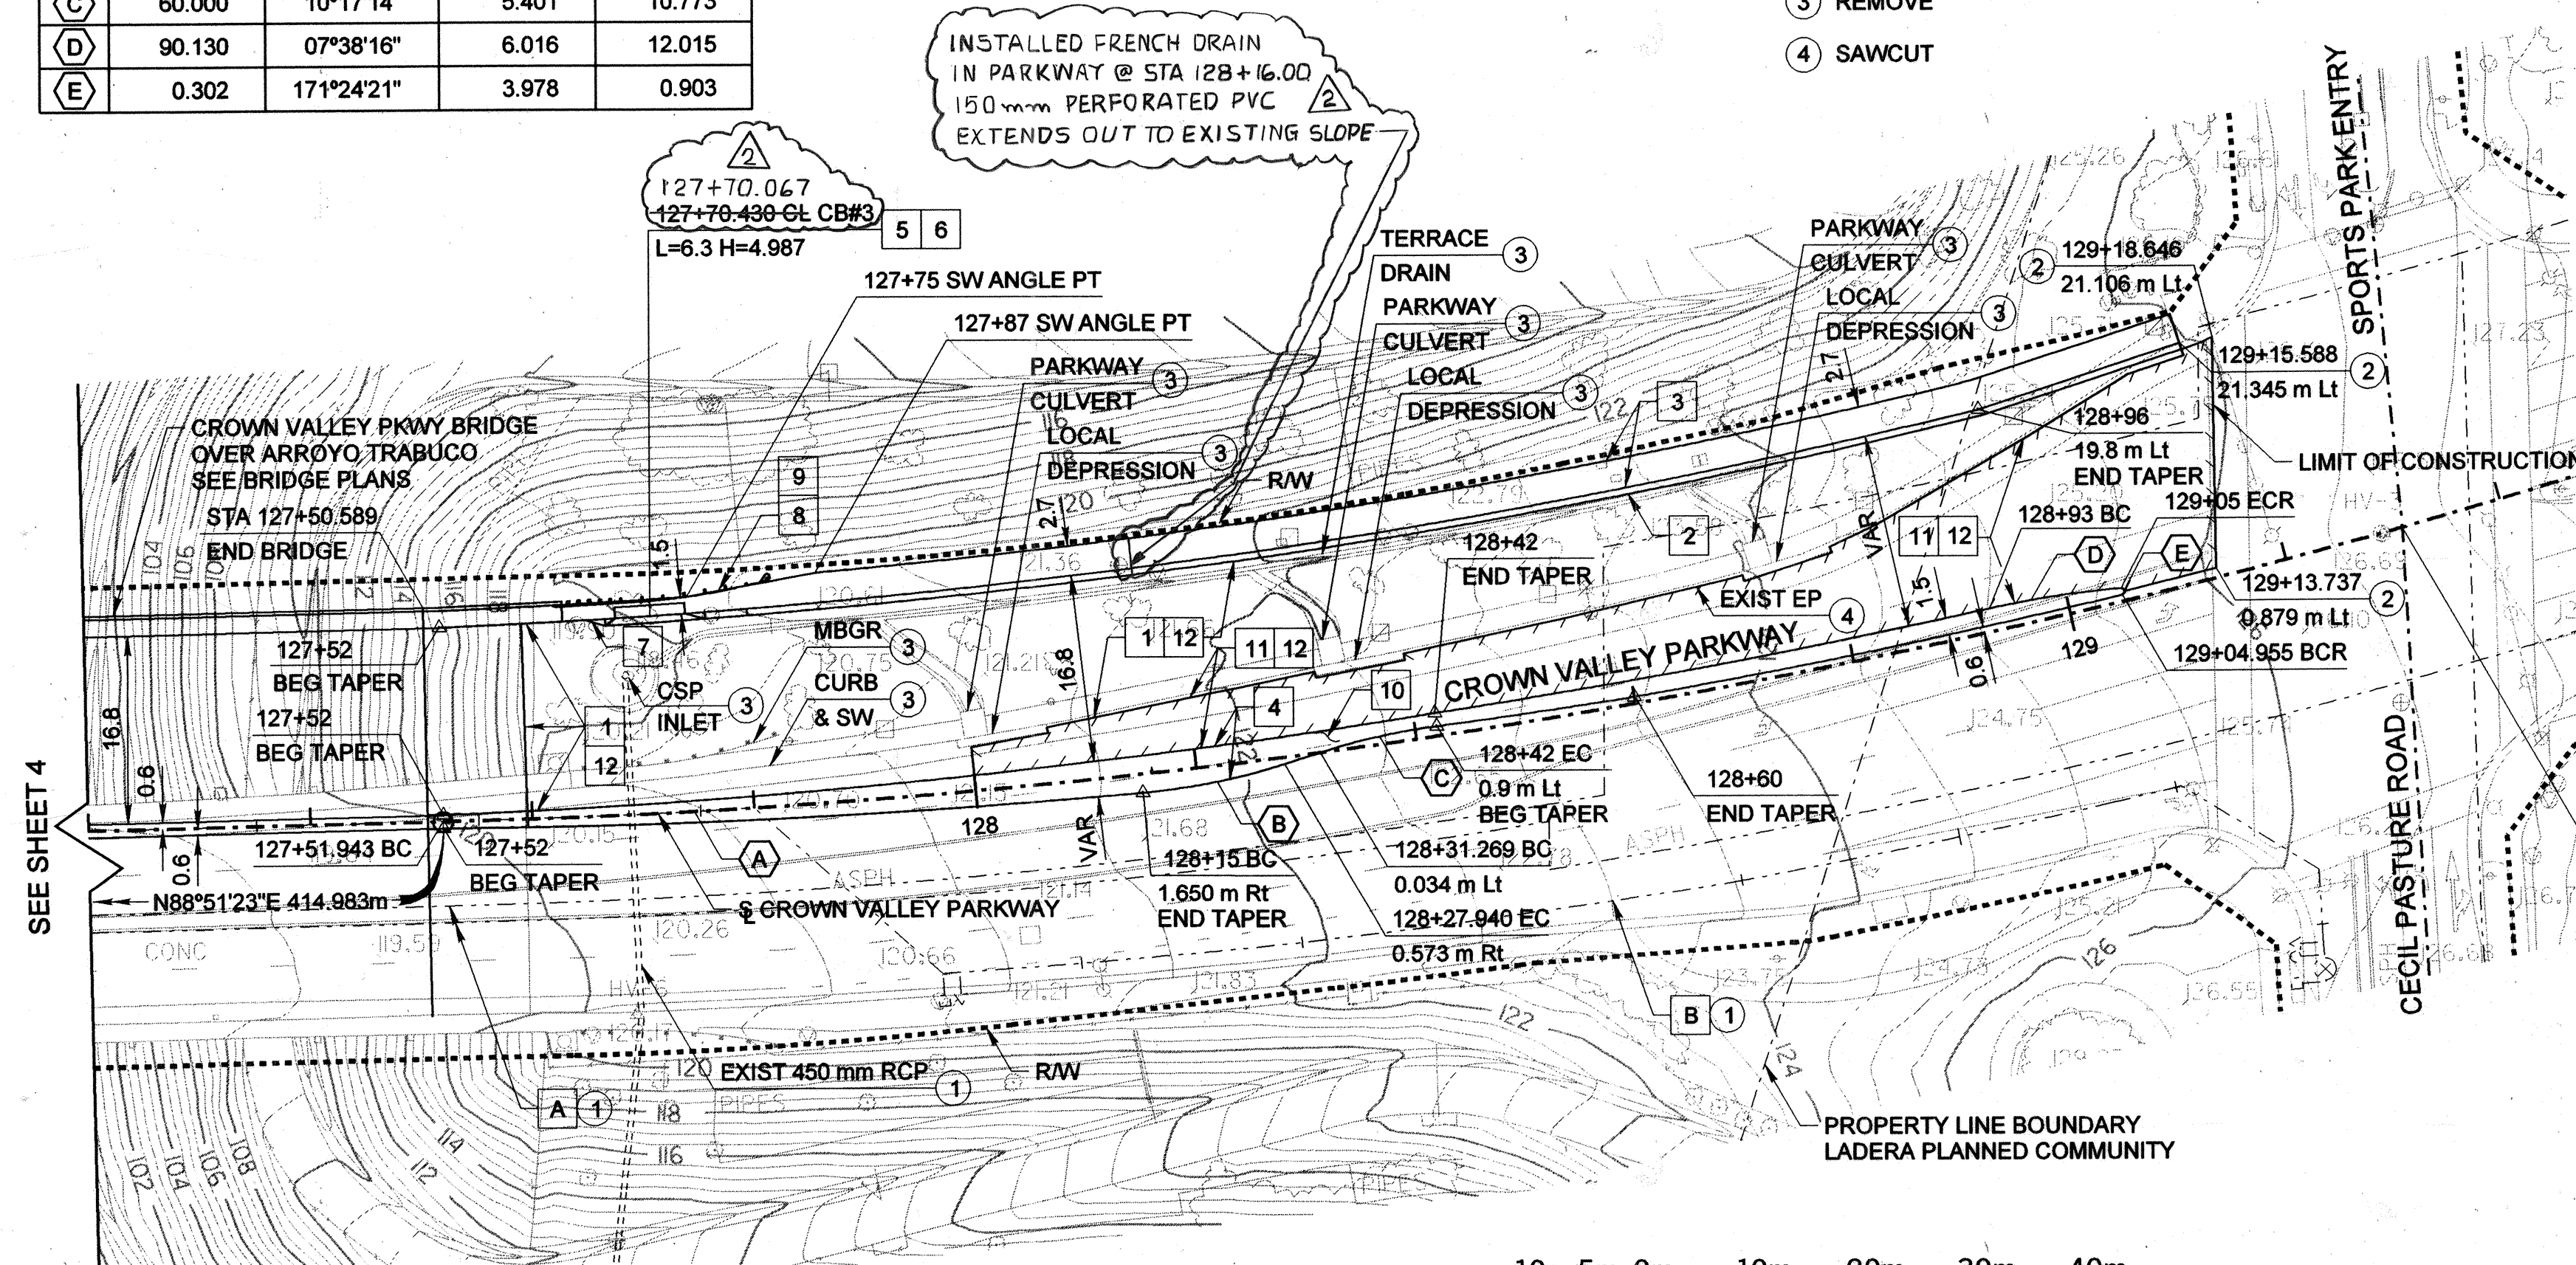

STA 129+30.898 & CROWN VALLEY PARKWAY
= STA 0+00.000 CECIL PASTURE ROAD & INTERSECT

ALL DIMENSIONS ARE IN METERS UNLESS NOTED OTHERWISE.



ORANGE COUNTY PUBLIC FACILITIES AND RESOURCES DEPARTMENT	
CROWN VALLEY PARKWAY STA 127+50.589 TO STA 129+16	
PLAN AND PROFILE	
DESIGNED: K. NGUYEN	SHEET 5
DRAWN: K. NGUYEN	CHECKED: G. R. PEÑA
SCALE: AS SHOWN	DATE: MAY 01, 2003
DRAWING NO. OF 55	

File Name: M:\2614\SHS\Plan and Prof2.dgn
Date Plotted: 8/5/2003 14:23:54