


**PROFILE**  
HORIZ. 1m : 500m  
VERT. 1m : 100m

#### CONSTRUCTION NOTES

- 13 CONSTRUCT 450 mm RCP (2000-D)
- 14 CONSTRUCT REINFORCED CONCRETE COLLAR PER PFRD STD PLAN 1317

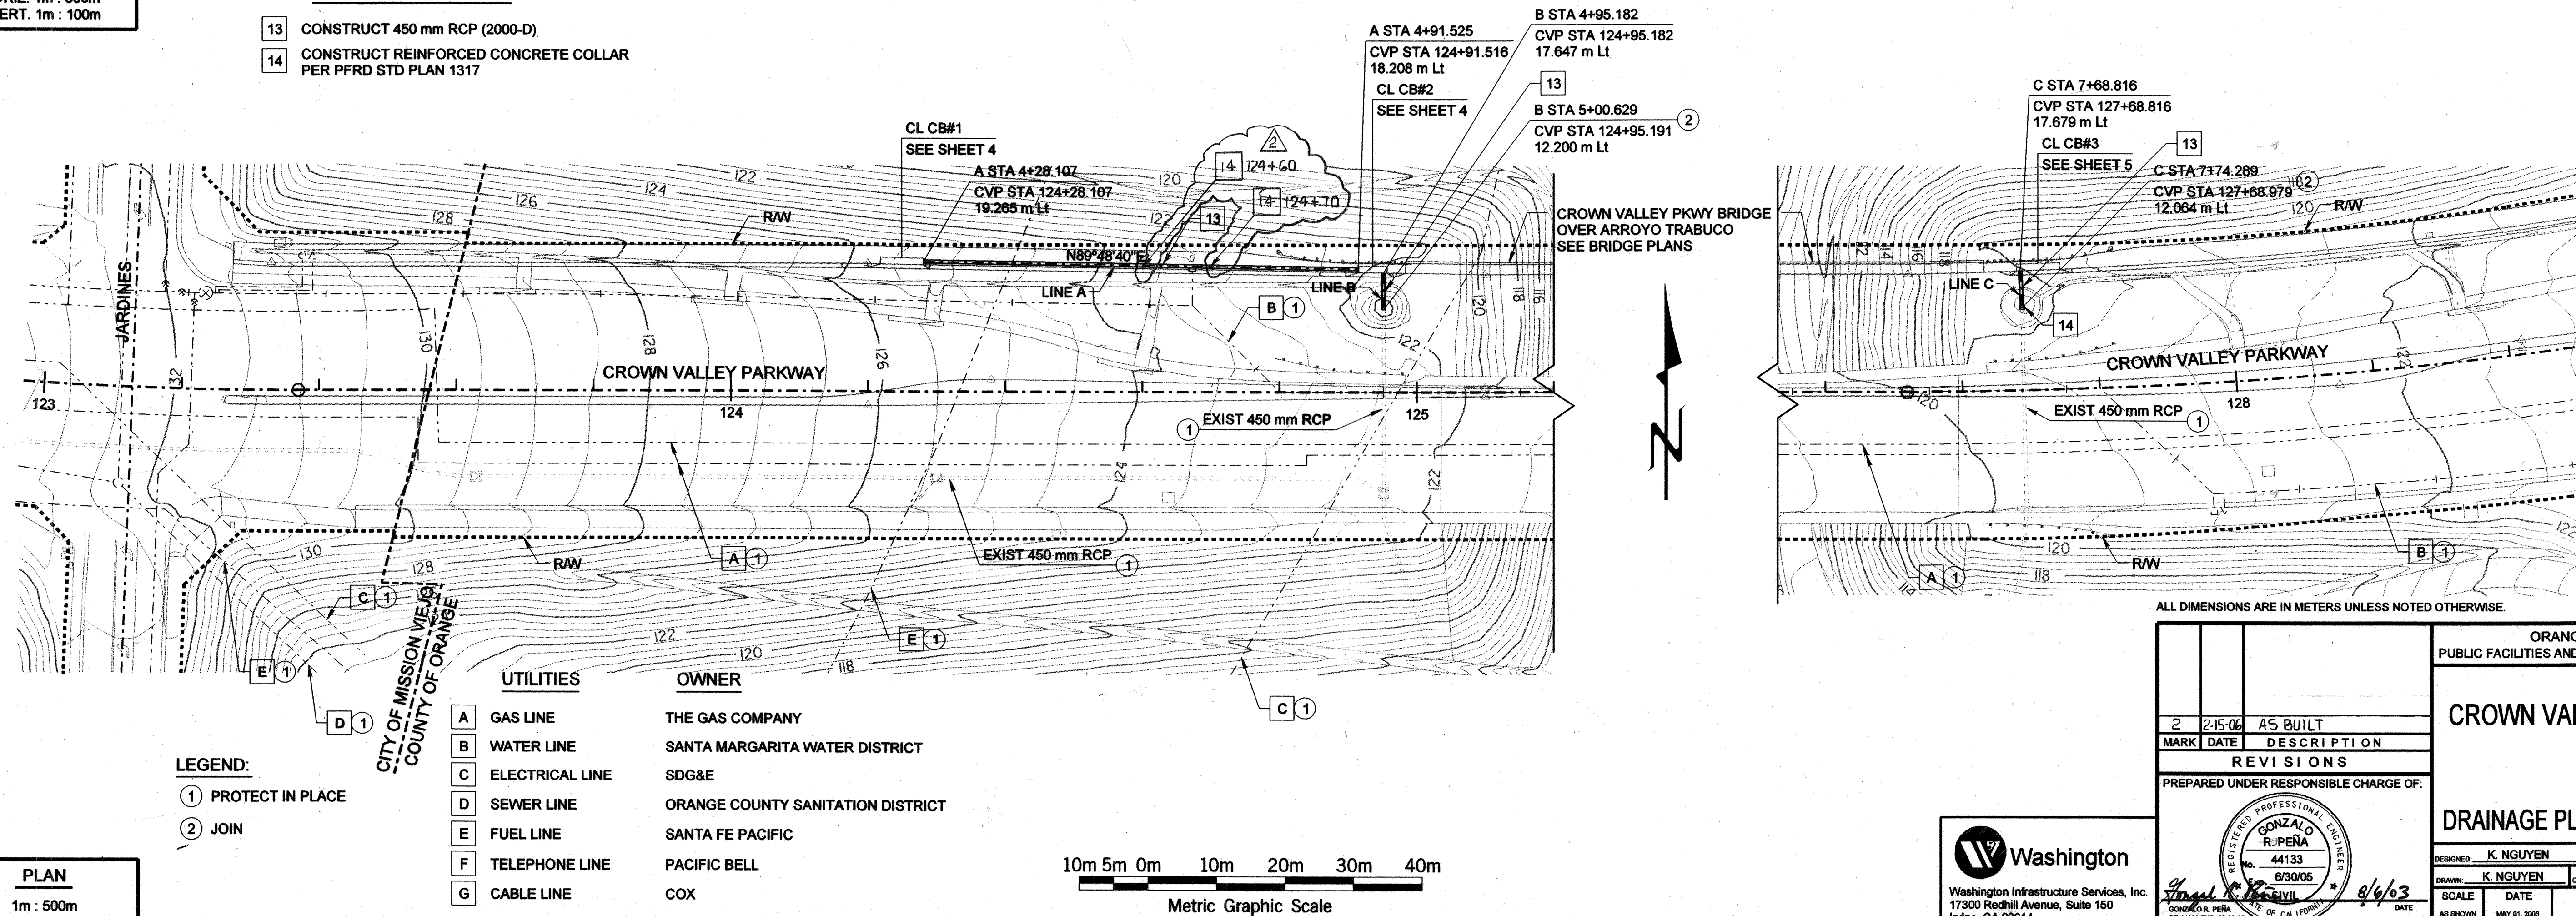

#### LEGEND:


- ① PROTECT IN PLACE
- ② JOIN

#### UTILITIES

- A GAS LINE
- B WATER LINE
- C ELECTRICAL LINE
- D SEWER LINE
- E FUEL LINE
- F TELEPHONE LINE
- G CABLE LINE


#### OWNER

- THE GAS COMPANY
- SANTA MARGARITA WATER DISTRICT
- SDG&E
- ORANGE COUNTY SANITATION DISTRICT
- SANTA FE PACIFIC
- PACIFIC BELL
- COX

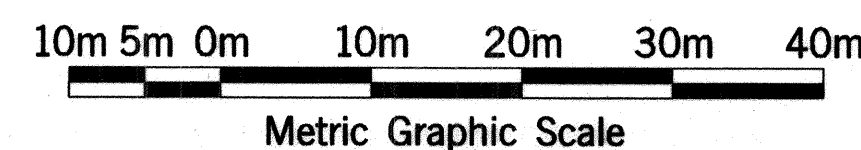

ALL DIMENSIONS ARE IN METERS UNLESS NOTED OTHERWISE.

ORANGE COUNTY PUBLIC FACILITIES AND RESOURCES DEPARTMENT	
<b>CROWN VALLEY PARKWAY</b>	
<b>DRAINAGE PLAN AND PROFILE</b>	
DESIGNED: K. NGUYEN	CHECKED: G. R. PEÑA
DRAWN: K. NGUYEN	DATE: MAY 01, 2003
SCALE: AS SHOWN	DRAWING NO. 7
SHEET 7 OF 55	

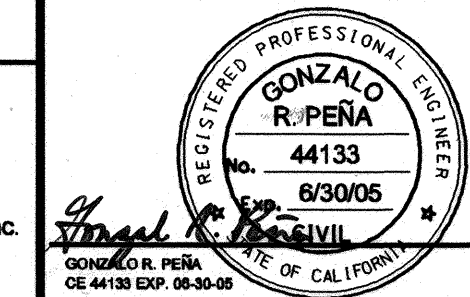

File Name: M126144SHTS1Storm Drain1.dgn  
Date Plotted: 7/23/2003 10:08:10