
 


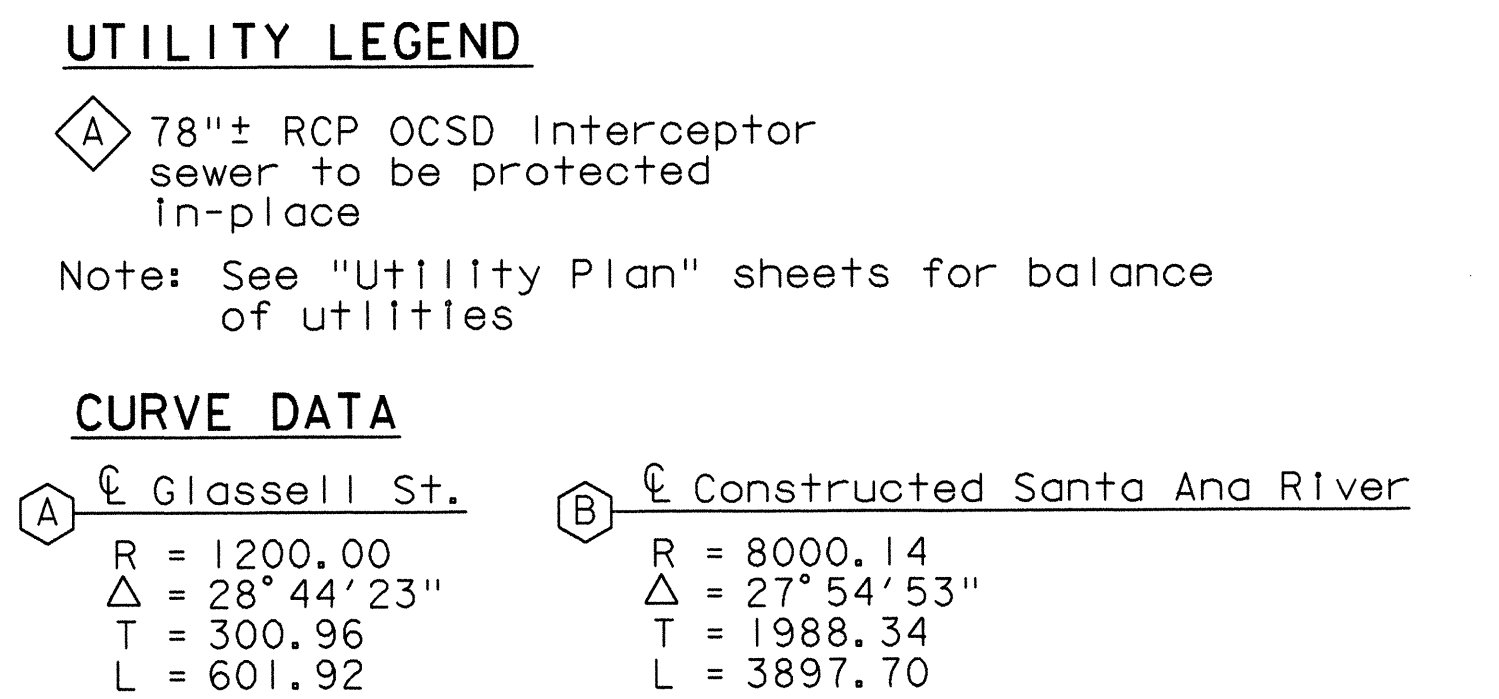

- ### LEGEND
- ① Paint "Glassell St. Bridge" & "Bridge No. 55C-0130"
 - ② Remove and replace exist chain link fence
 - ③ New PCC sidewalk and flared depressed curb driveway approach
 - ④ Remove AC Curb and Type P marker. Salvage Type P marker
 - ⑤ Crash Cushions
 - ⑥ New retaining wall & trail modifications
 - ⑦ Temporary railing Type "K"
 - ⑧ Concrete Barrier Type 26
 - ⑨ Exist raised concrete median to remain
 - ⑩ Tubular Hand Railing
 - ⑪ Type 15 Luminaire, see "Lighting Plans"
 - ⑫ Remove & Salvage Existing Metal Beam Guard Railing
 - ⑬ Remove and replace portion of exist grouted riprap
 - ⑭ Infill Wall Retrofit (Exist Bridge North Side Piers 10 & 11)
 - ⑮ Deck drain, see "Girder Layout" sheets
 - ⑯ Storm Drain Outlet Modification
 - ⑰ 12" Grouted riprap
 - ⑱ Temporary fencing

	Denotes Deck Closure Pour
	Denotes Existing Structure
	Denotes New Structure
	Denotes Existing Chain Link Fence
	Denotes Existing Metal Beam Guard railing
	Denotes Bridge and Street Luminaire
	Denotes High Water Elevation (219.93)
	Denotes Point of Minimum Vertical Clearance
	Denotes Direction of Flow



W. Koo & Associates, Inc.
600 The City Parkway West, Suite 310
Orange, CA, 92868
PH: (714) 456-0280
FAX: (714) 456-0295

MARK	DATE	DESCRIPTION
REVISIONS		
PREPARED UNDER RESPONSIBLE CHARGE OF:		
 <i>Shafi M. Sharifan</i> 7/18/06 DATE		
ORANGE COUNTY RESOURCES AND DEVELOPMENT MANAGEMENT DEPARTMENT GLASSSELL STREET BRIDGE WIDENING OVER SANTA ANA RIVER STRUCTURE PLAN NO. 1		
DESIGNED <u>X. WU</u>		SHEET
DRAWN <u>G. RUELOW</u>	CHECKED <u>S. SHARIFAN</u>	35R
SCALE	DATE 7/19/02	DRAWING NO.
AS SHOWN		OF 70

File Name: \$FILE\$

Border sheet last modified 09-Nov-1999