



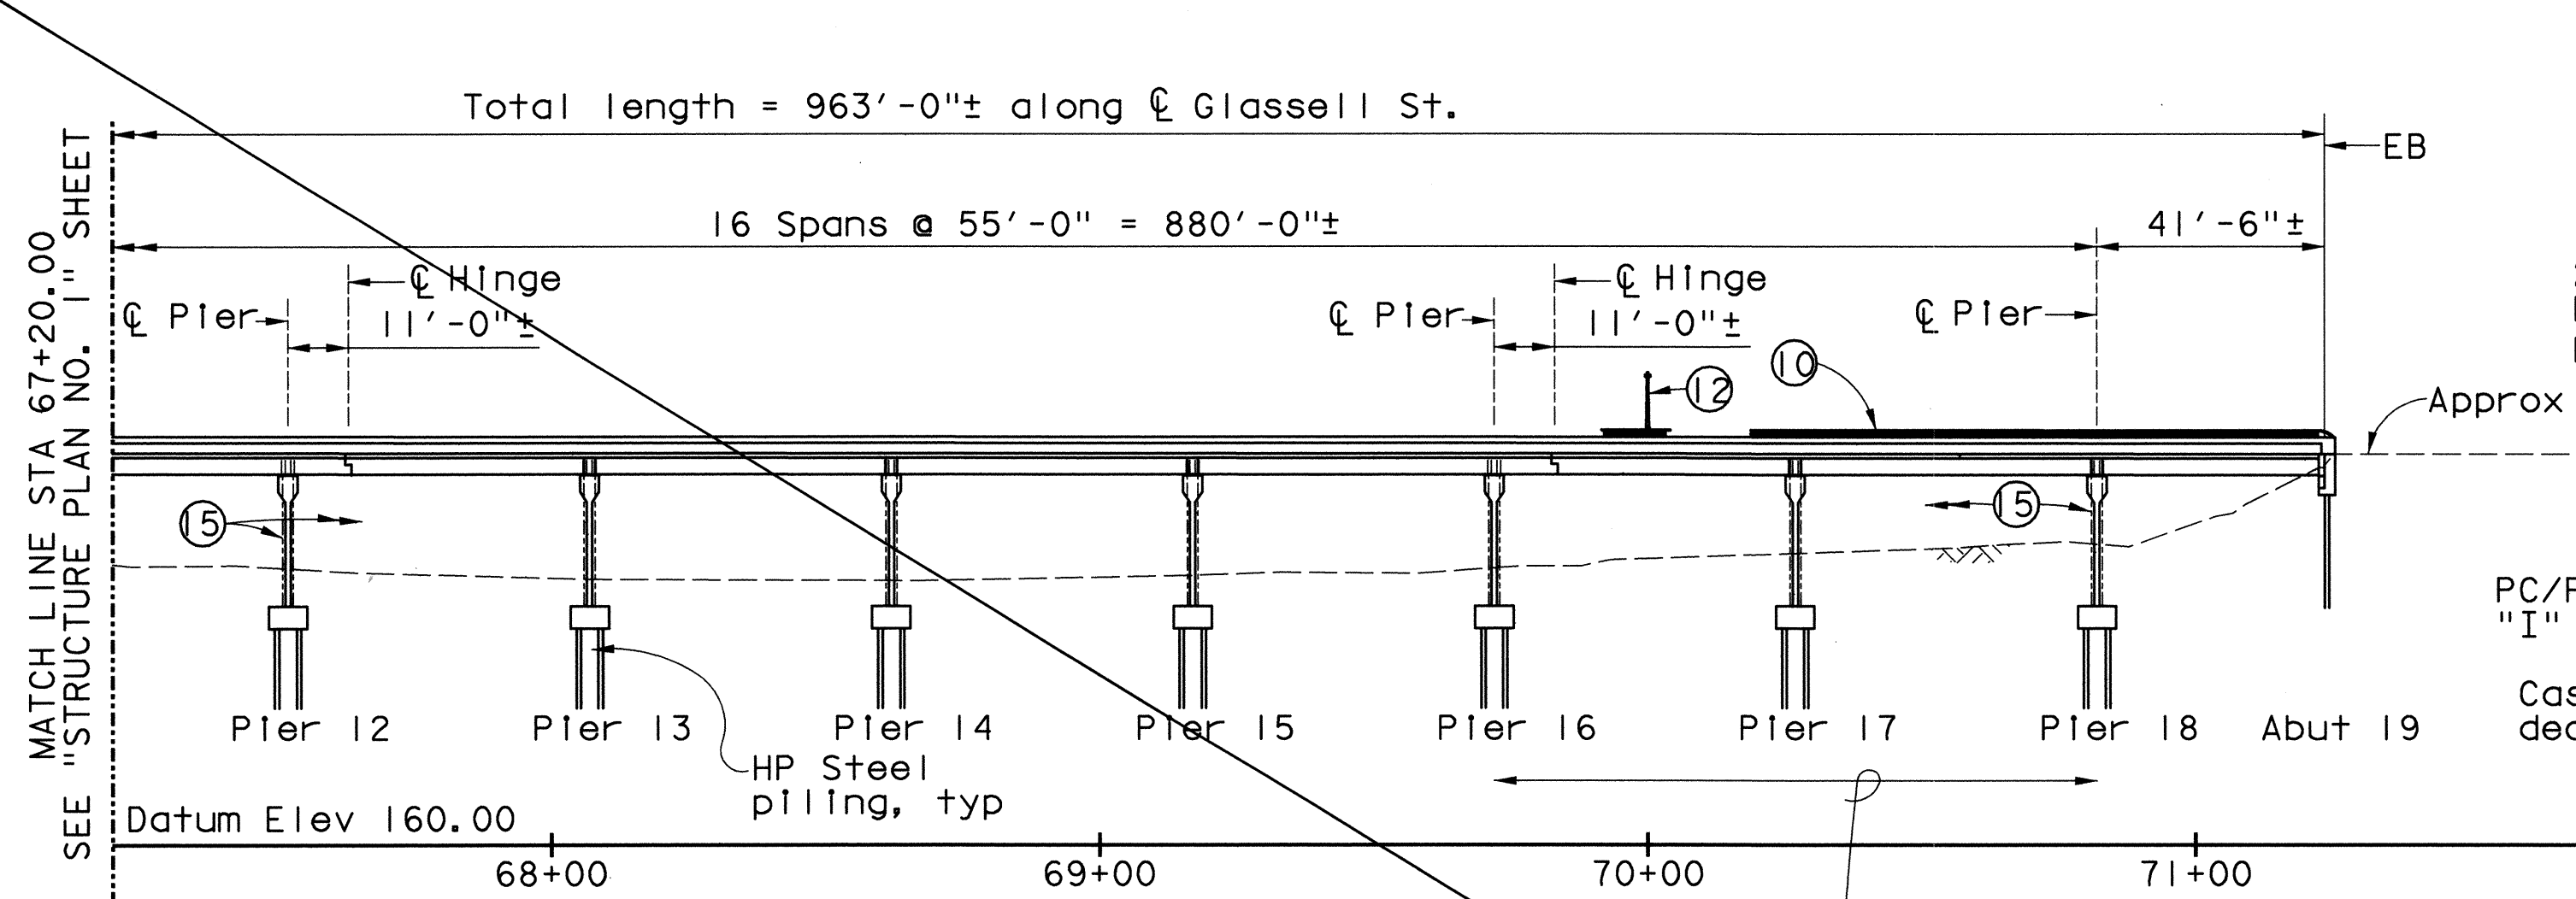

ELEVATION
1" = 30'

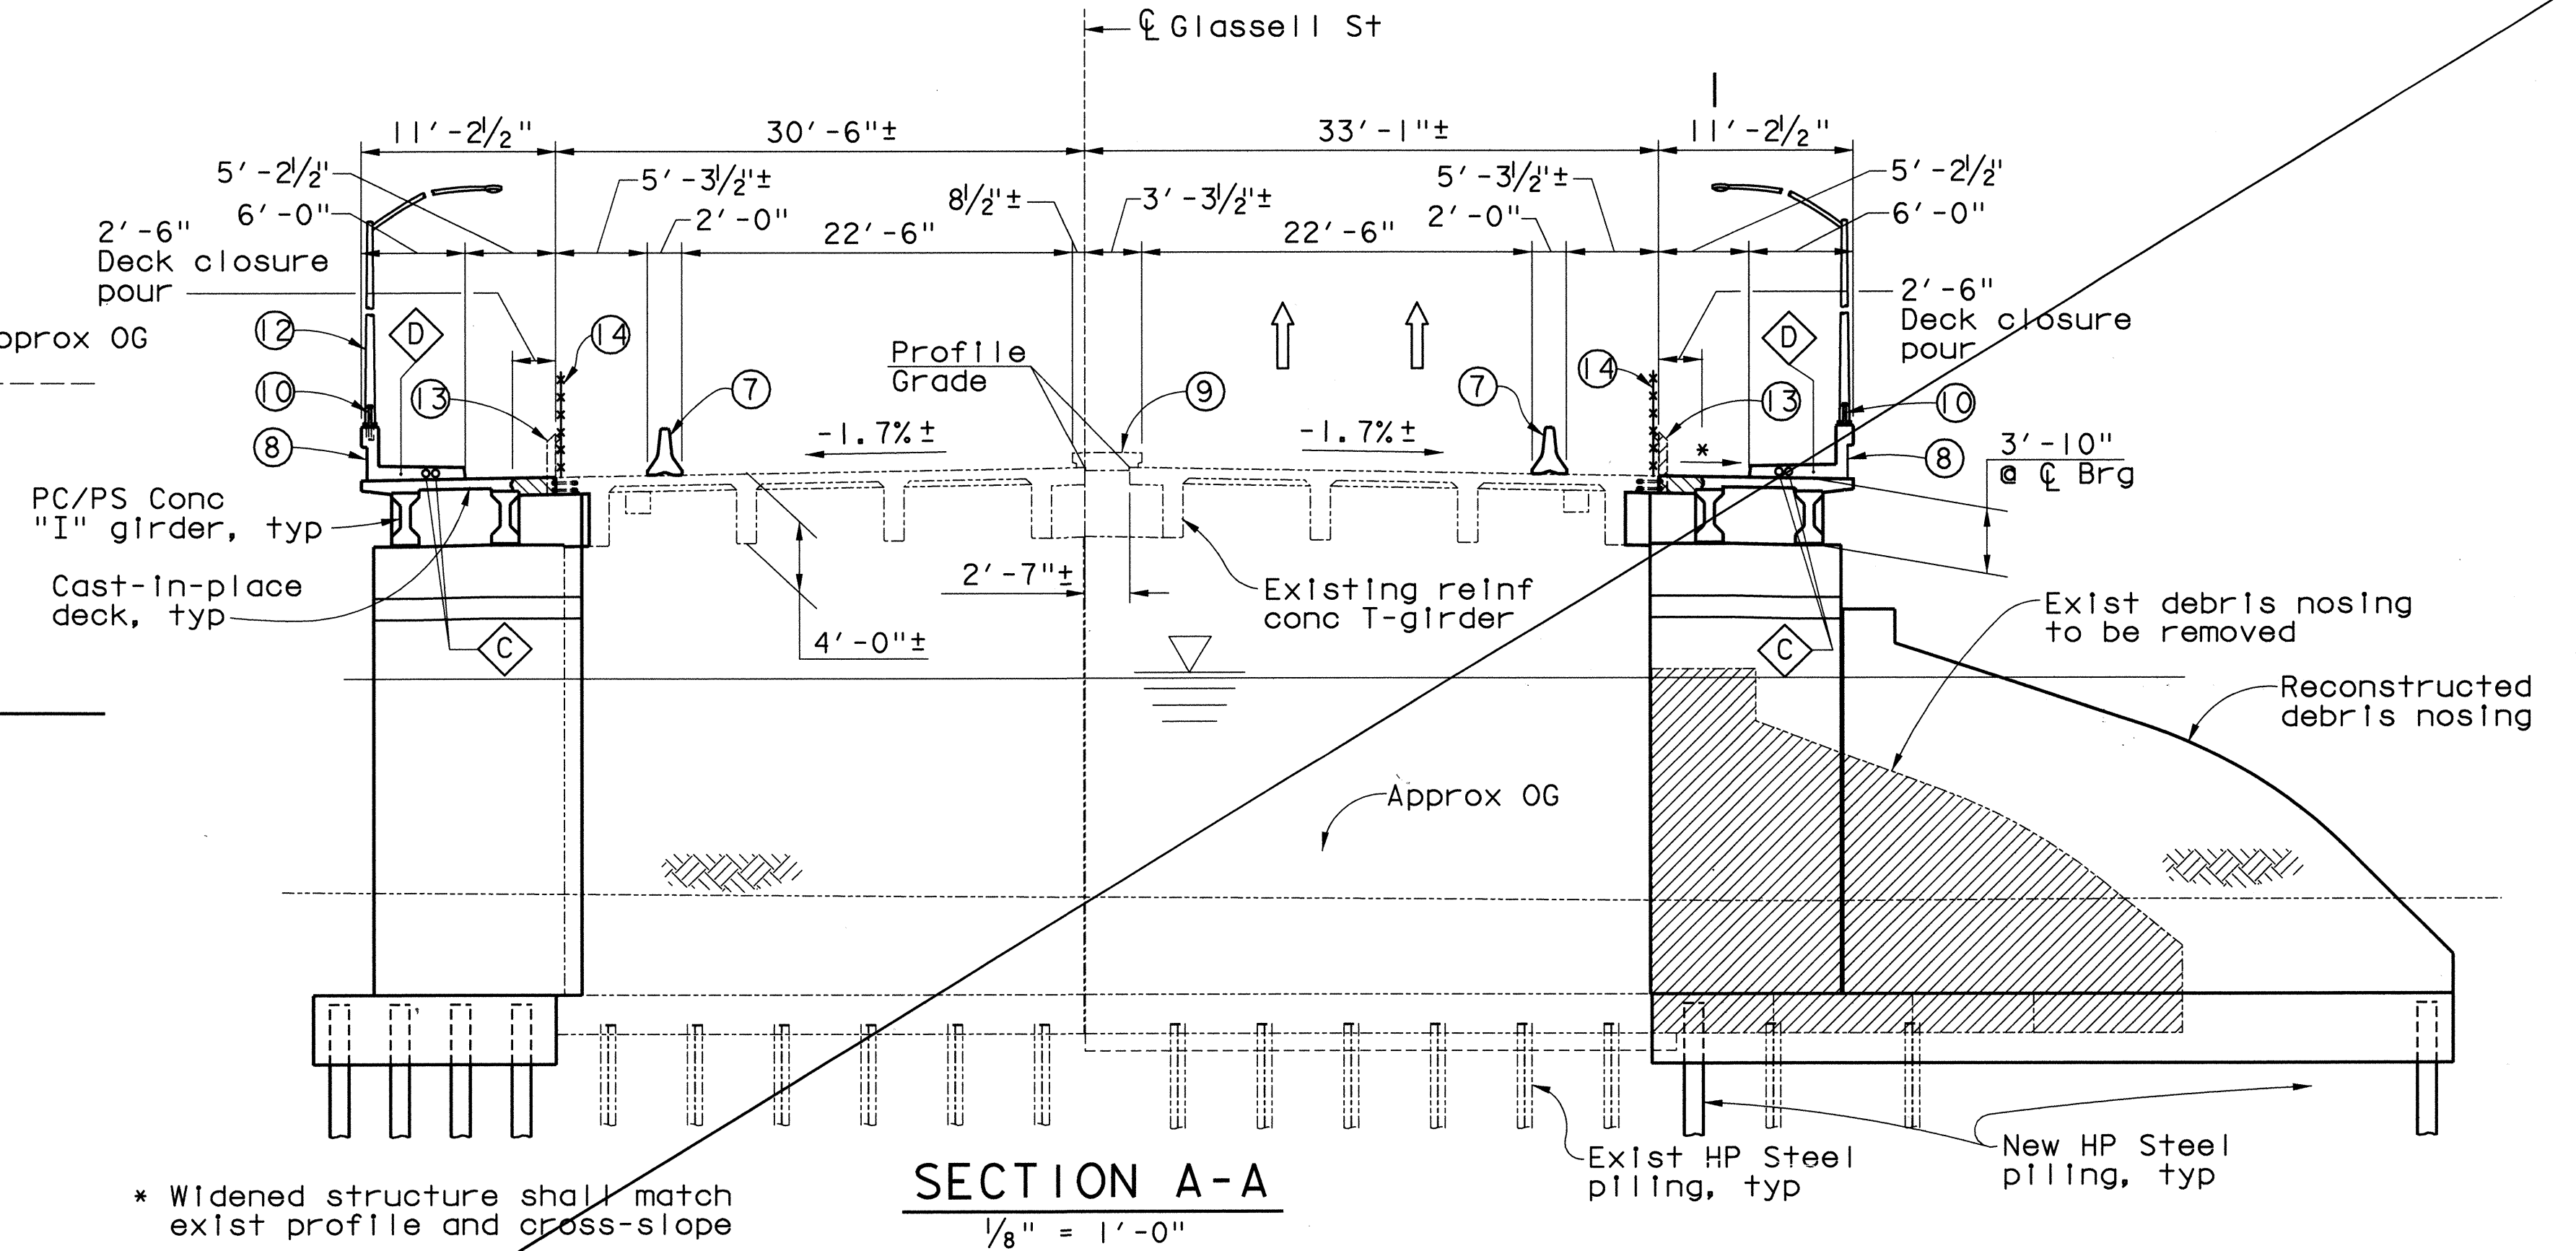


LEGEND

- ① Paint "Glassell St. Bridge" Bridge No. 55C0130"
- ② Remove and reset exist chain link fence
- ③ New PCC sidewalk
- ⑦ Temporary railing Type "K"
- ⑧ Concrete Barrier Type 26
- ⑨ Exist raised concrete median to remain
- ⑩ Tubular Hand Railing
- ⑪ Remove Existing AC Curb
- ⑫ Type 15 Luminaire, see "Lighting Plans"
- ⑬ Remove & salvage Existing Metal Guard Railing for O&M
- ⑭ Temporary Fencing
- ⑮ Infill Wall Retrofit (North Side Exist Bridge Piers 12-18)
- ⑯ Deck Drain
- ⑰ Storm Drain Outlet Modification
- ⑱ Remove exist type N markers & 36"± post tube delineators

- Denotes Deck Closure Pour
- Denotes Bridge Removal (Portion)
- Denotes Existing Structure
- Denotes New Structure
- Denotes Existing Chain Link Fence
- Denotes Existing Metal Beam Guard railing
- Denotes Bridge Lighting
- Denotes Existing Marker or Sign

UTILITY LEGEND

- Existing utility (SCE) Overhead Electrical Lines to be protected In-place
- Future Utility Opening
- Conduit for Bridge Lighting, see "Lighting Plans"

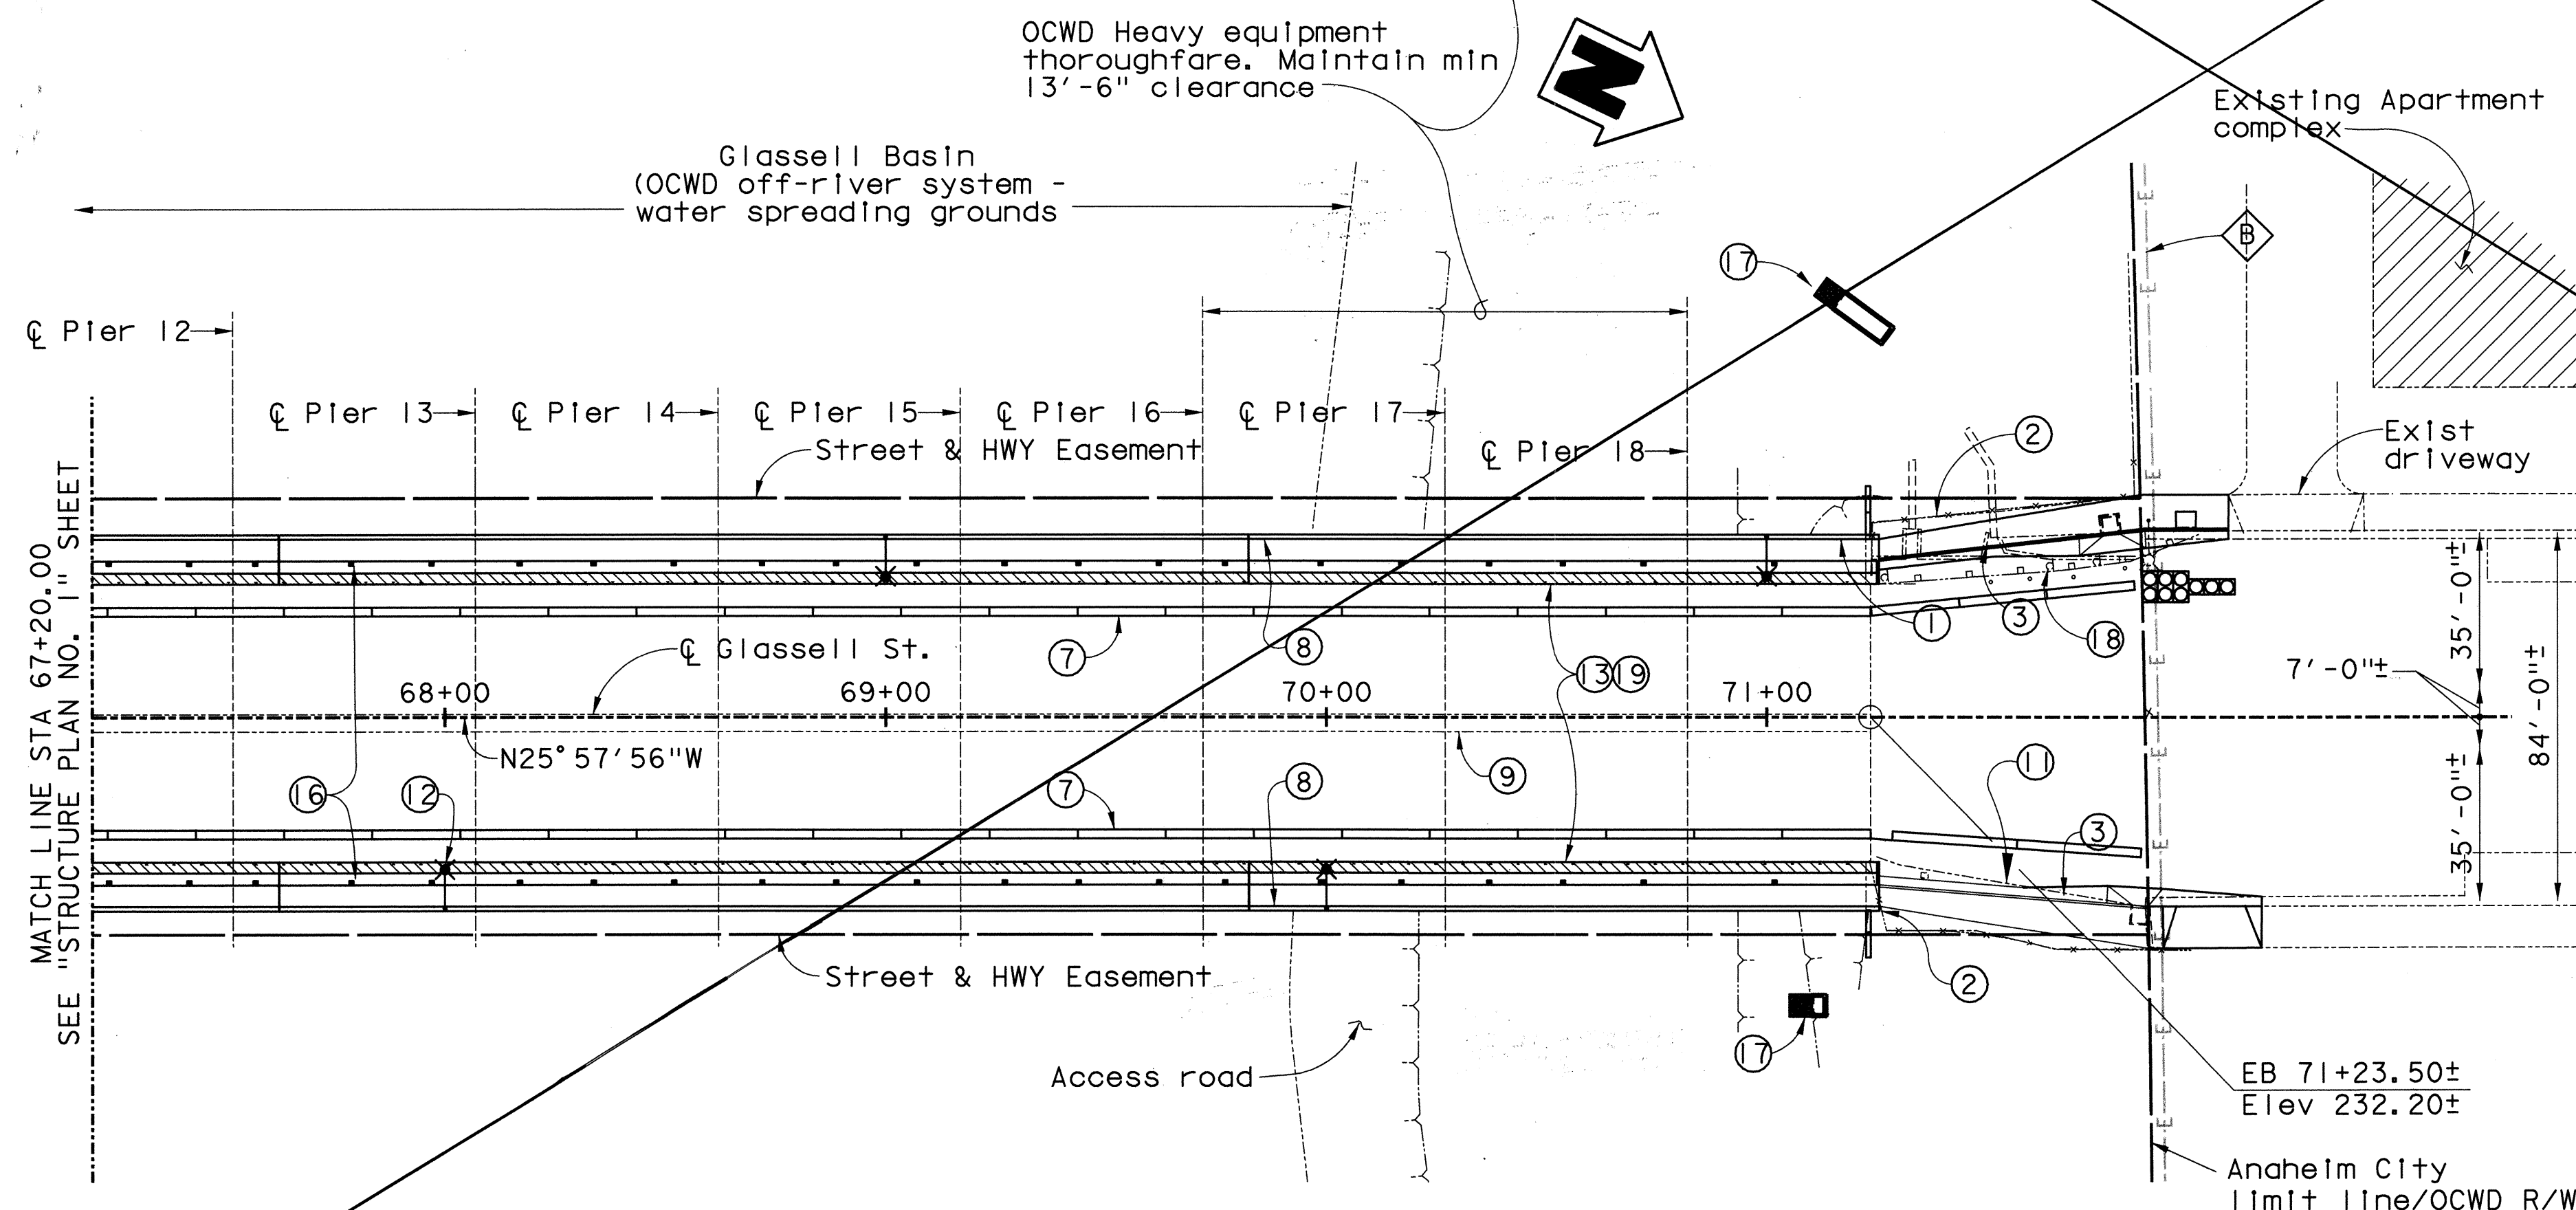

PLAN
1" = 30'

SUPERSEDED AND REPLACED BY SHEET 36R.

W. Koo & Associates, Inc.
600 The City Parkway West, Suite 310
Orange, CA 92668
PH: (714) 456-0280
FAX: (714) 456-0295

ORANGE COUNTY
PUBLIC FACILITIES AND RESOURCES DEPARTMENT

GLASSELL STREET BRIDGE WIDENING
OVER SANTA ANA RIVER

STRUCTURE PLAN NO. 2

MARK	DATE	DESCRIPTION
REVISIONS		
PREPARED UNDER RESPONSIBLE CHARGE OF:		
DESIGNED	X. WU	
DRAWN	G. BUELOW	CHECKED
SCALE	AS SHOWN	DATE
DATE	7/19/02	DRAWING NO.

SHEET	36
OF	70

Note: Contractor shall verify all controlling field dimensions before ordering or fabricating any material

Date Plotted: \$DATE\$

File Name: \$FILES\$

Border sheet last modified 05-Nov-1999