


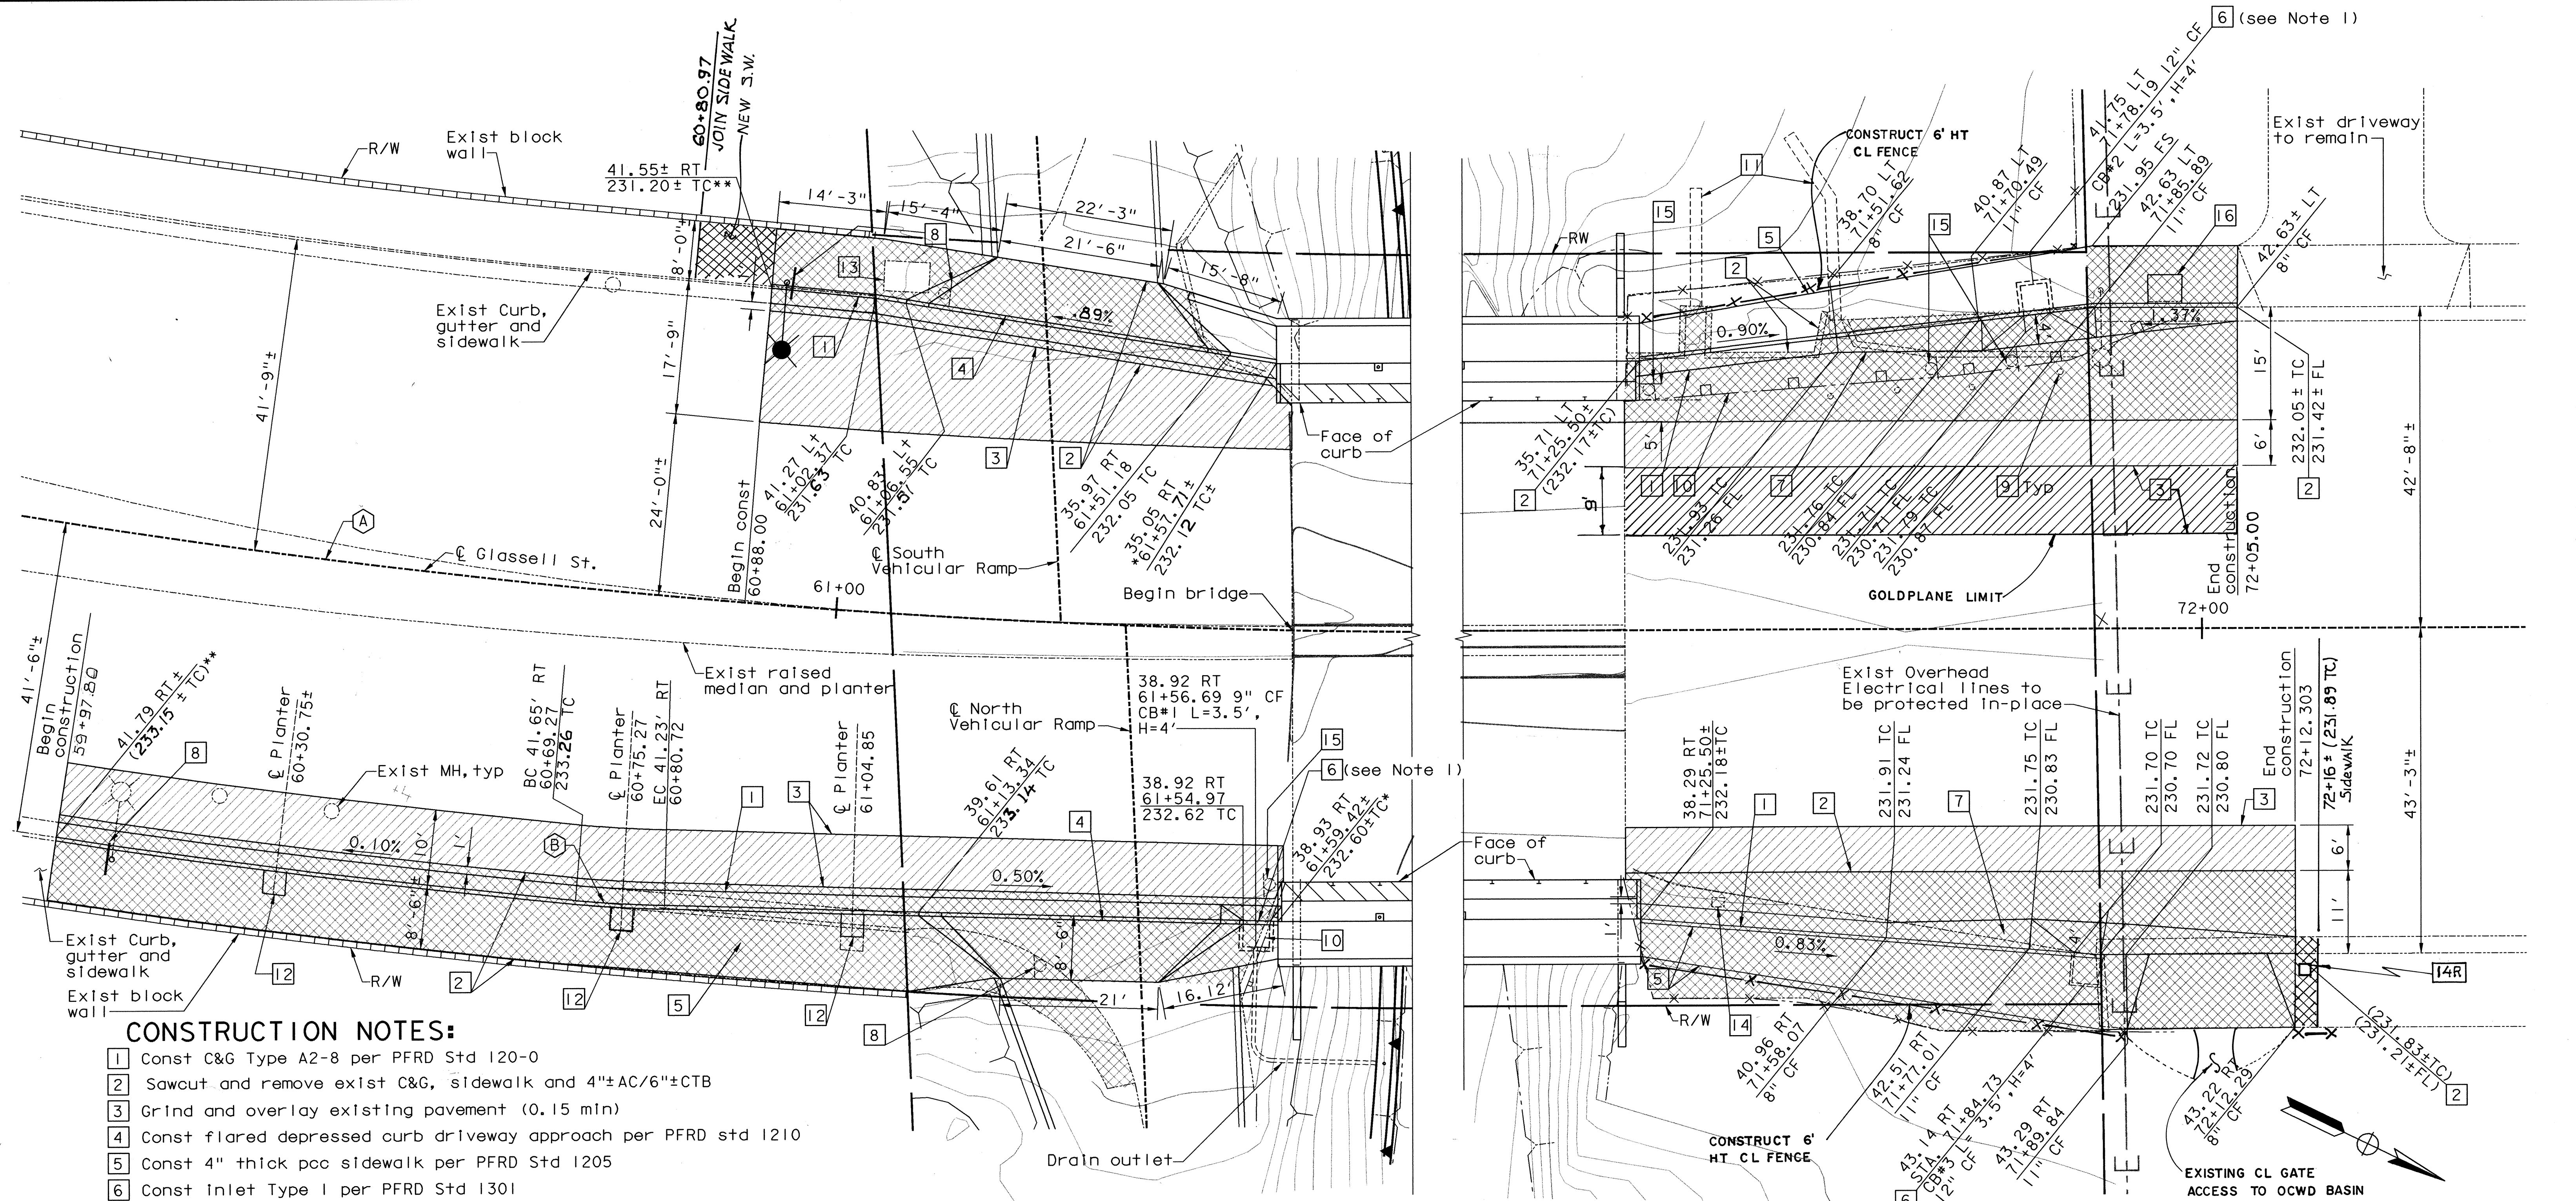

CONSTRUCTION NOTES:

- 1 Const C&G Type A2-8 per PFRD Std 120-0
- 2 Sawcut and remove exist C&G, sidewalk and 4"±AC/6"±CTB
- 3 Grind and overlay existing pavement (0.15 min)
- 4 Const flared depressed curb driveway approach per PFRD std 1210
- 5 Const 4" thick pcc sidewalk per PFRD Std 1205
- 6 Const Inlet Type I per PFRD Std 1301
- 7 Const local depression per PFRD Std 1310
- 8 Remove exist R28 sign on metal post and relocate to street light
- 9 Remove exist 36"± post tube delineators
- 10 Remove exist metal beam guard railing
- 11 Remove exist 18"± CSP and AC berm and Inlet
- 12 Remove and replace exist tree. Const 3' x 3' opening in sidewalk
- 13 Exist irrigation control pull box to remain. Raise lid to match new sidewalk
- 14 Exist traffic control pull box relocated. Raise lid to elevation of new AC pavement
- 15 Remove and salvage exist object Marker
- 16 Const 3' x 3' opening in sidewalk around exist tree
- 17 Remove and reset exist chain link fence

Note: Contractor shall verify all controlling field dimensions before ordering or fabricating any material

A) Glasell St.	B) East Curb
R = 1200.00	R = 200.00
Δ = 28° 44' 23"	Δ = 03° 23' 38"
T = 300.96	T = 5.93
L = 601.92	L = 11.847

Notes:

1. For drainage details not shown, see "Glasell Approach Storm Drain Plan and Profile No. 1" sheet.
- * Match top of sidewalk on the bridge
- ** Match top of exist curb

PLAN

1" = 10'

LEGEND

- Limits of cold mill of existing AC pavement.
- Limits of removal of exist C&G, sidewalk and 4"±AC/6"±CTB
- New Luminaire, see "Lighting Plans"
- Exist Luminaire to be protected in place. See "Lighting Plans"
- Exist sign or marker
- Relocate sign onto new light standard

W. Koo & Associates, Inc. 600 The City Parkway West, Suite 310 Orange, CA 92668 PH: (714) 456-0280 FAX: (714) 456-0295	
ORANGE COUNTY PUBLIC FACILITIES AND RESOURCES DEPARTMENT GLASSELL STREET BRIDGE WIDENING OVER SANTA ANA RIVER GLASSELL APPROACH MODIFICATION PLAN	
DESIGNED: X. WU DRAWN: G. BUELOW AS SHOWN	CHECKED: S. SHARIFAN DATE: 7/19/02 DRAWING NO.
SHEET 6 OF 70	SHEET OF 70