
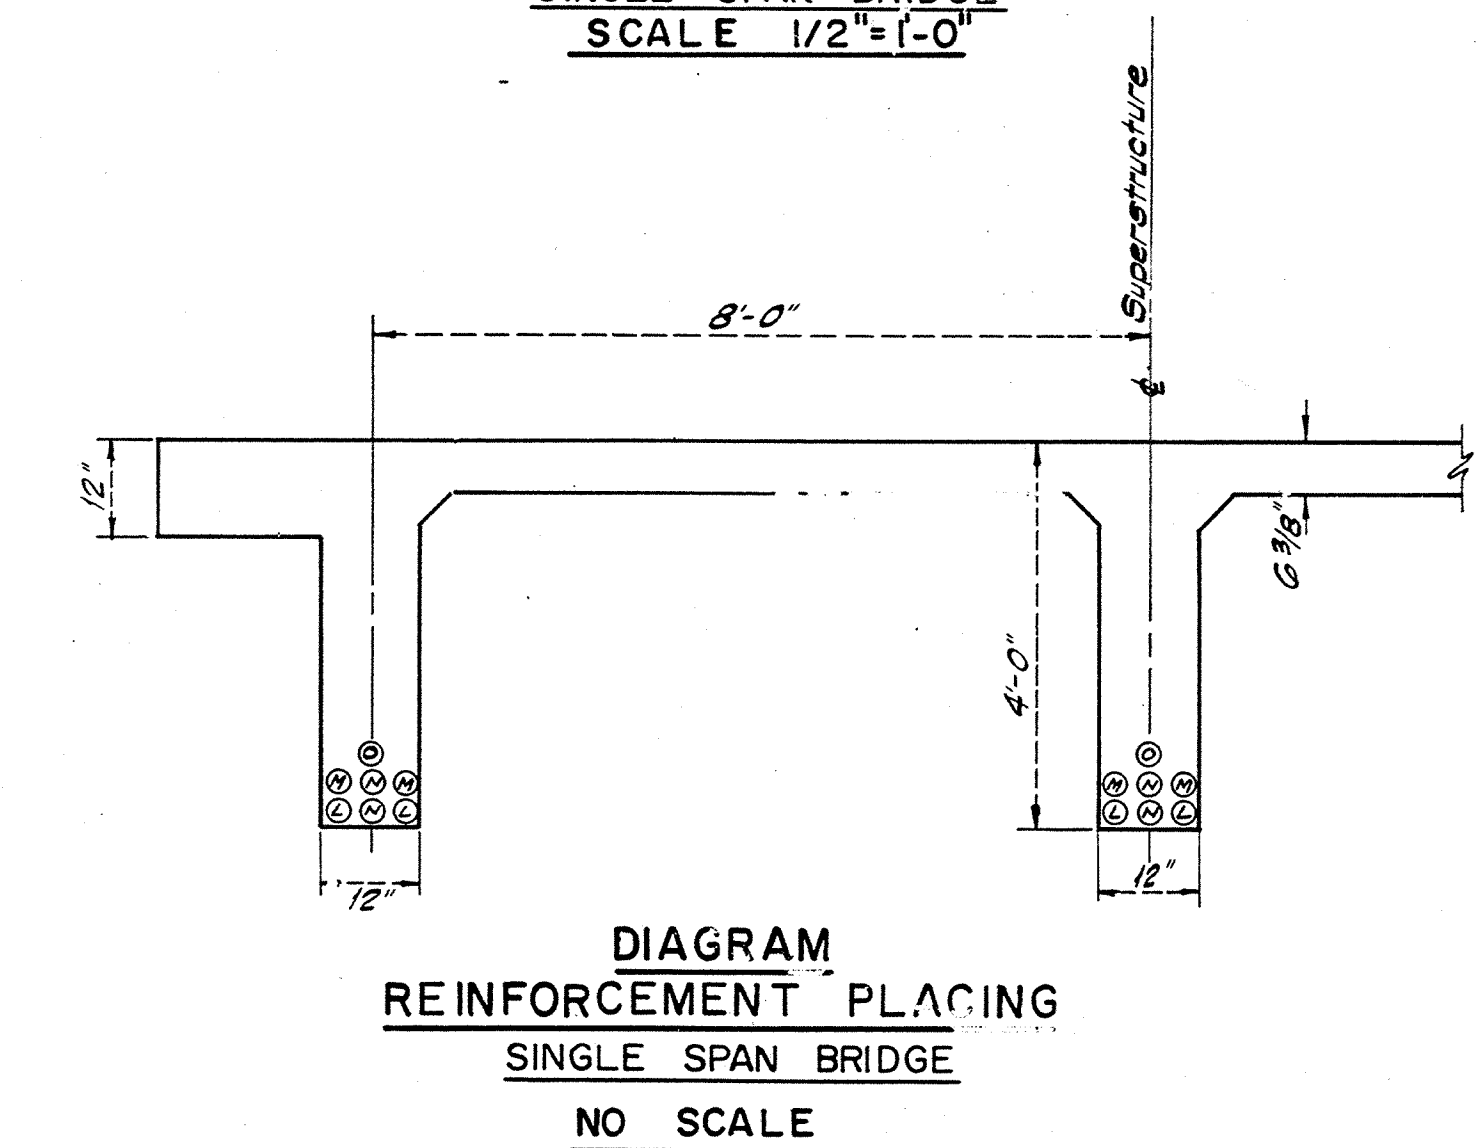
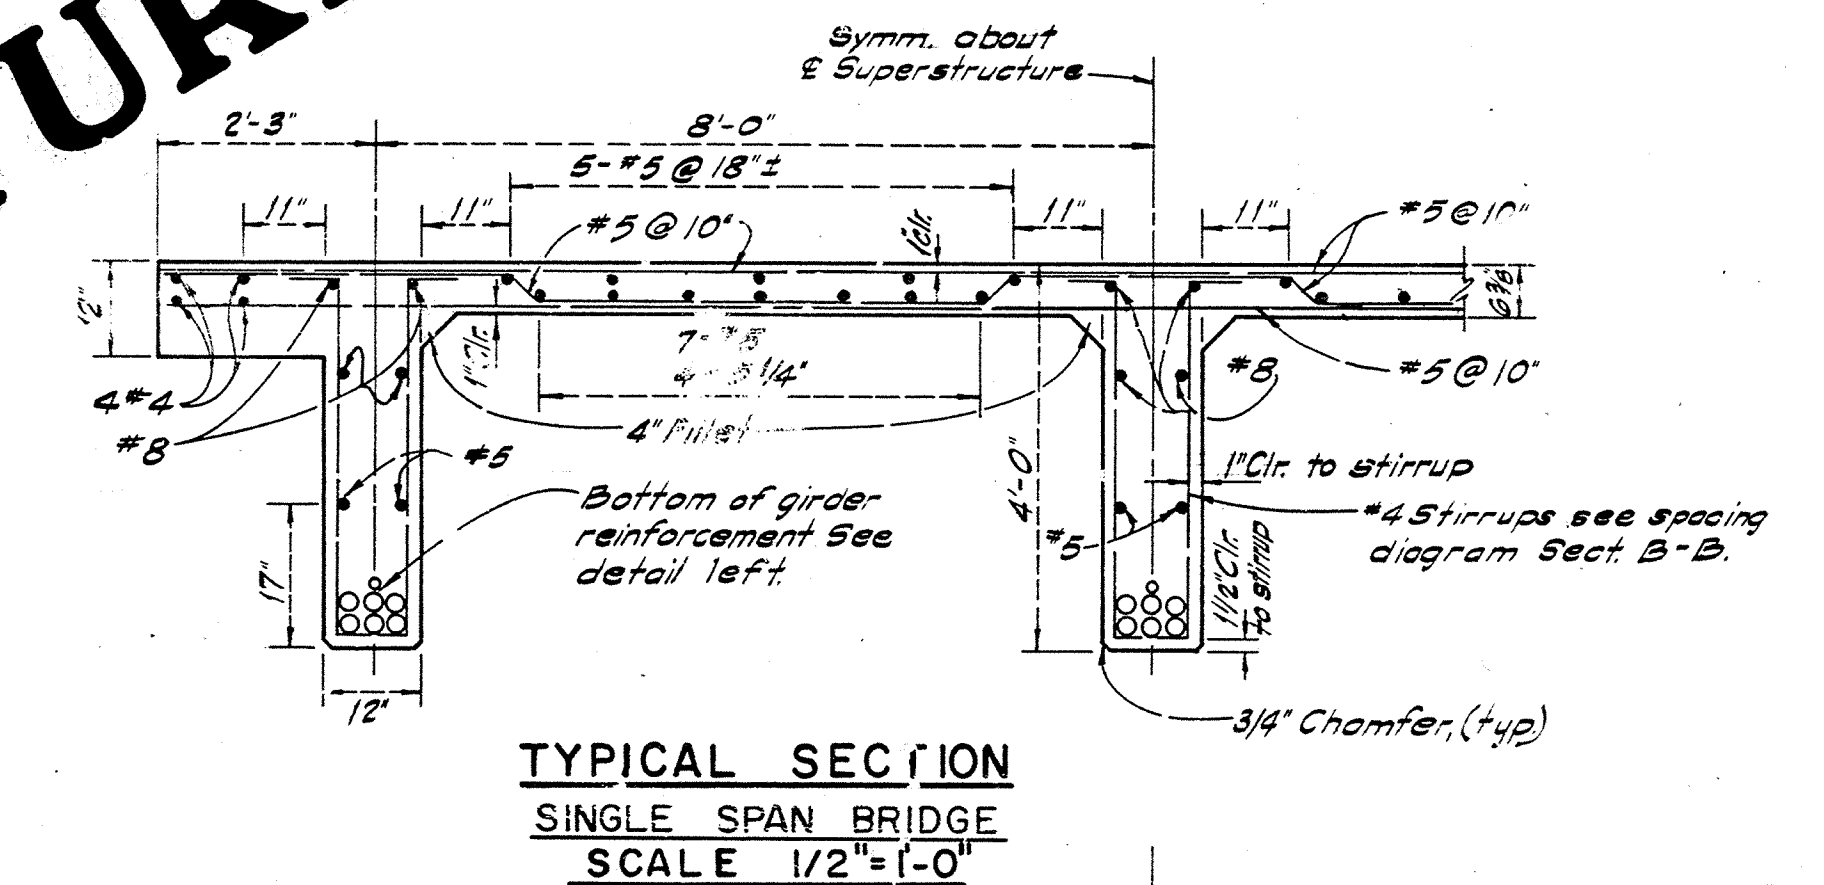
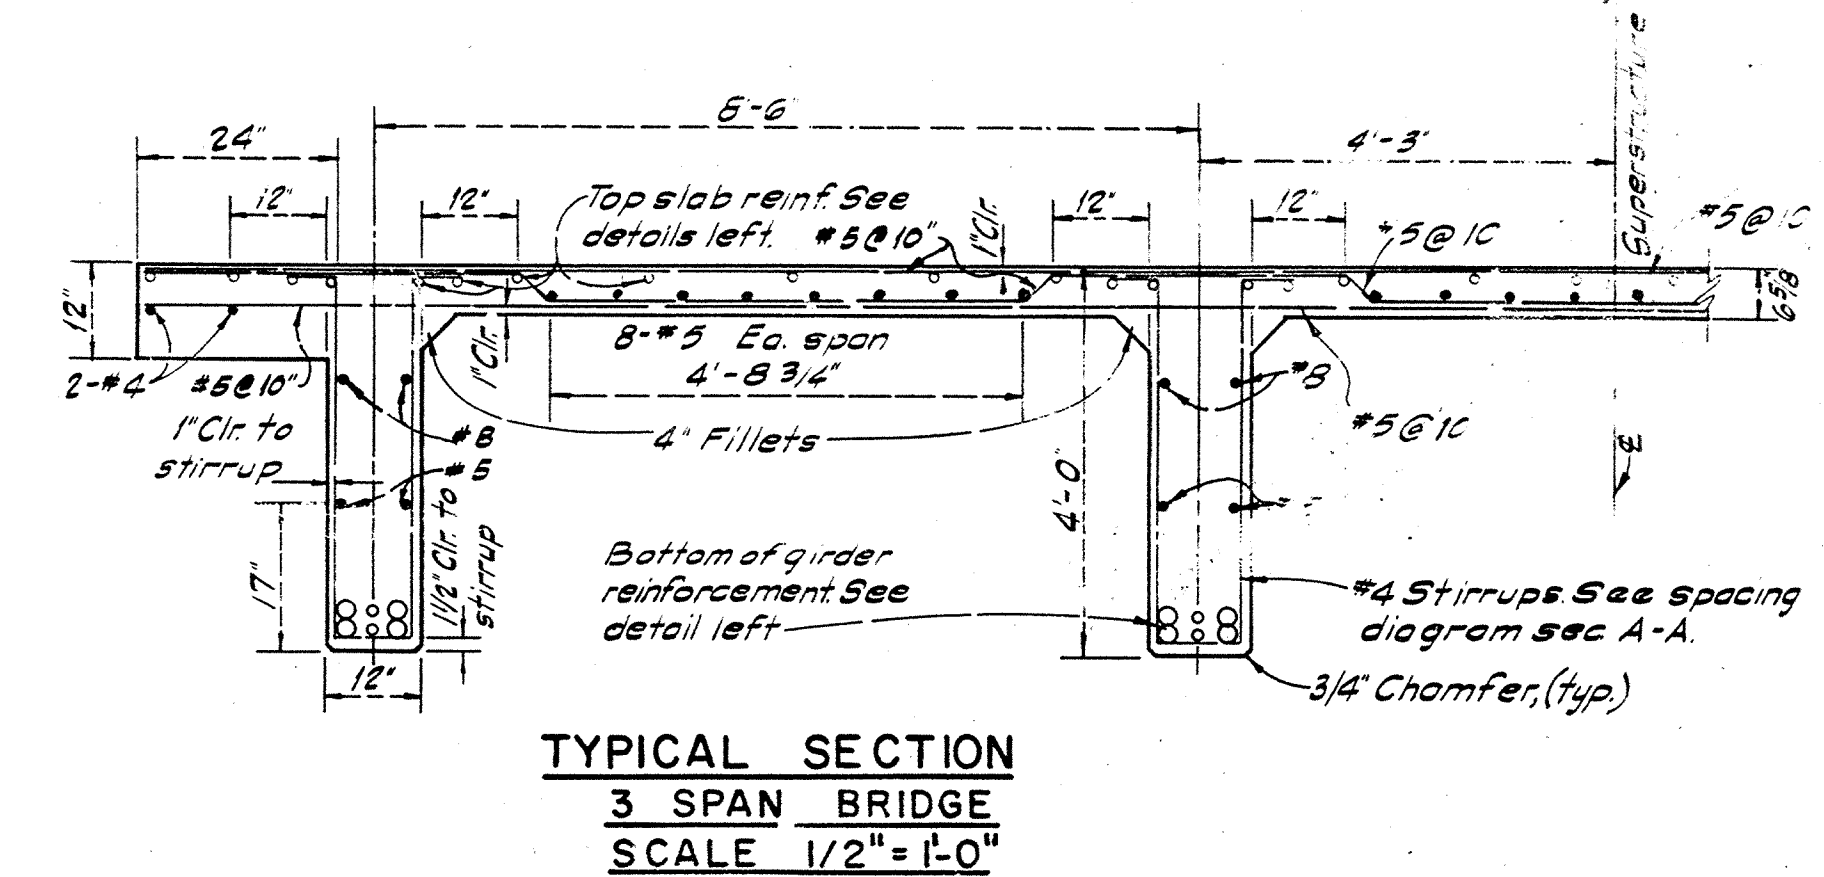
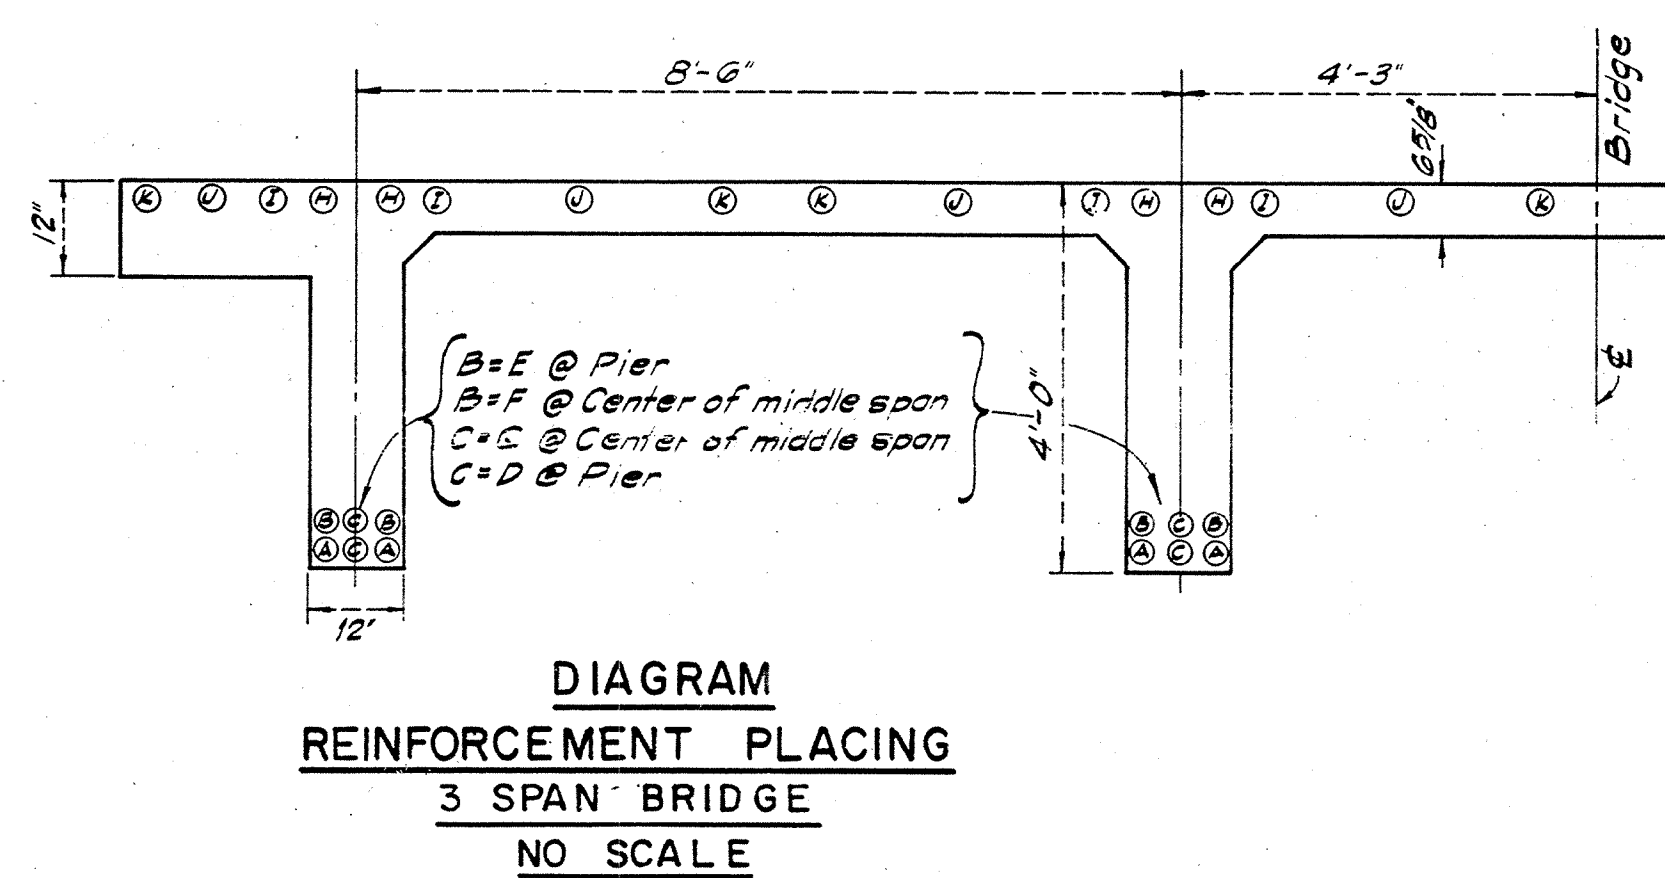
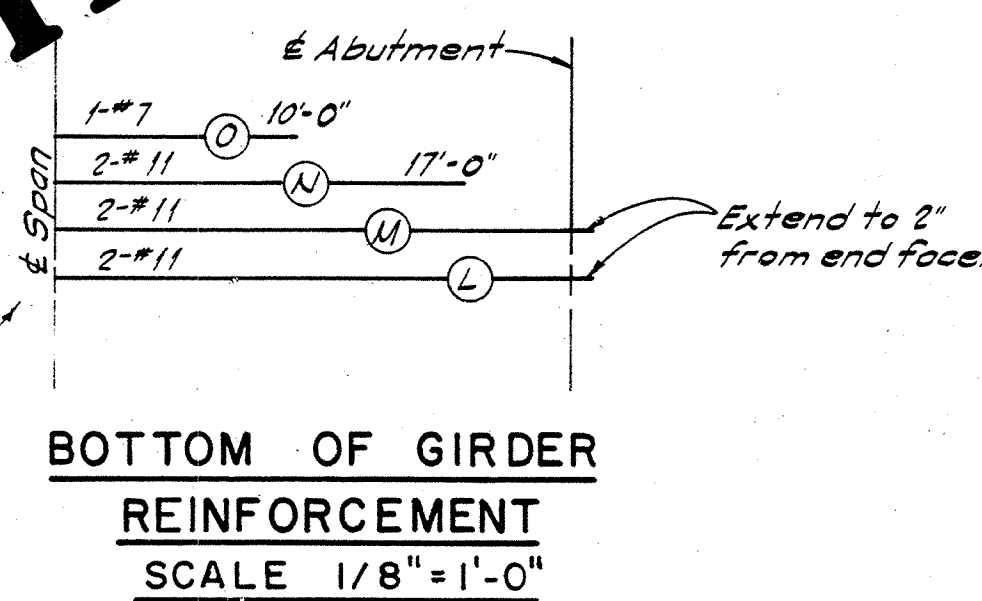
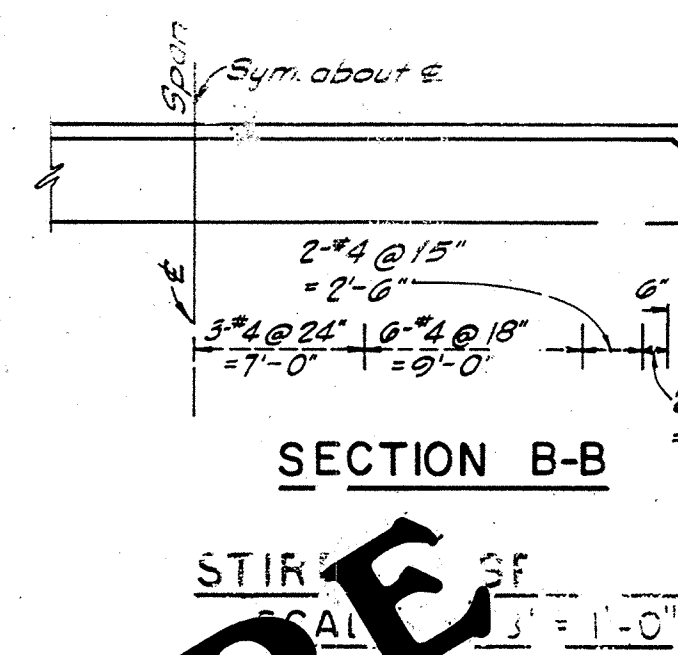
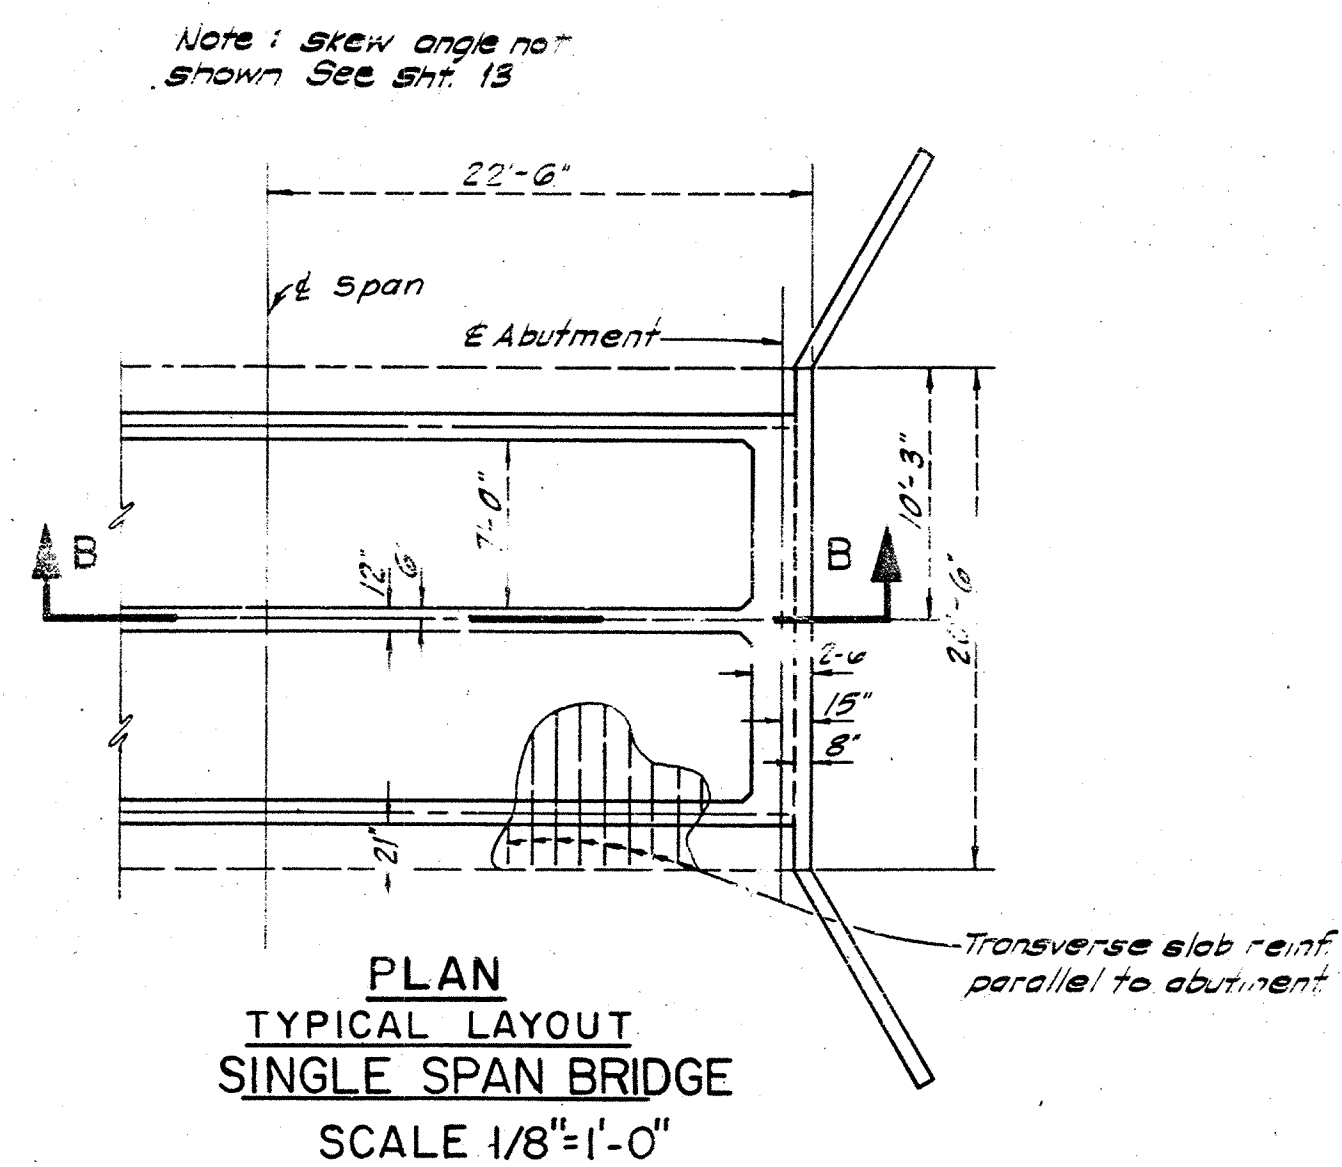
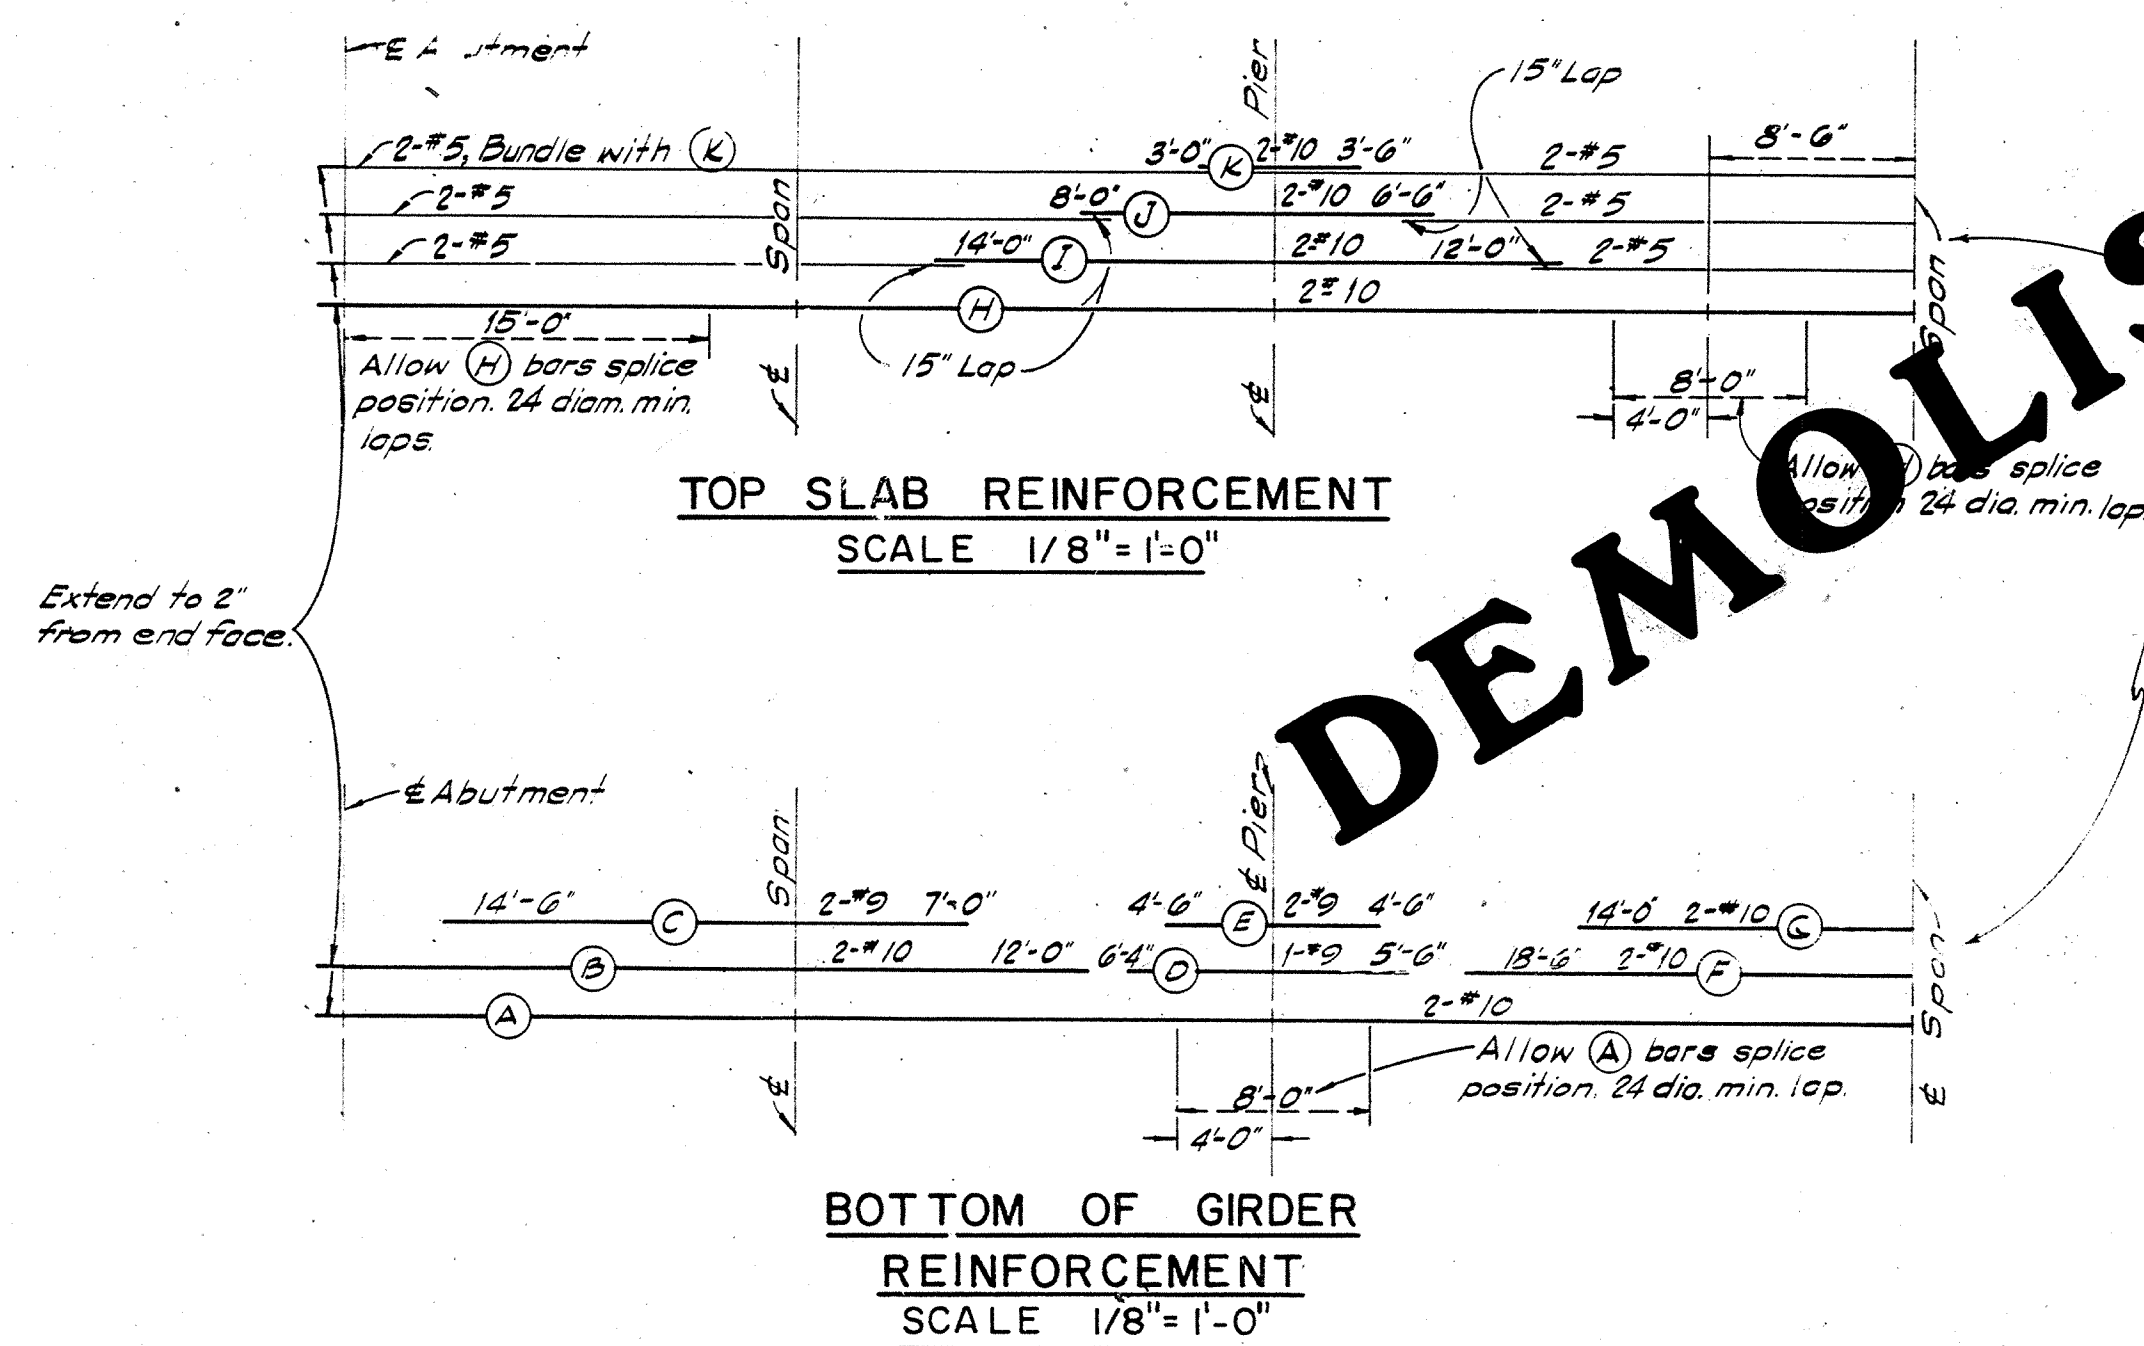
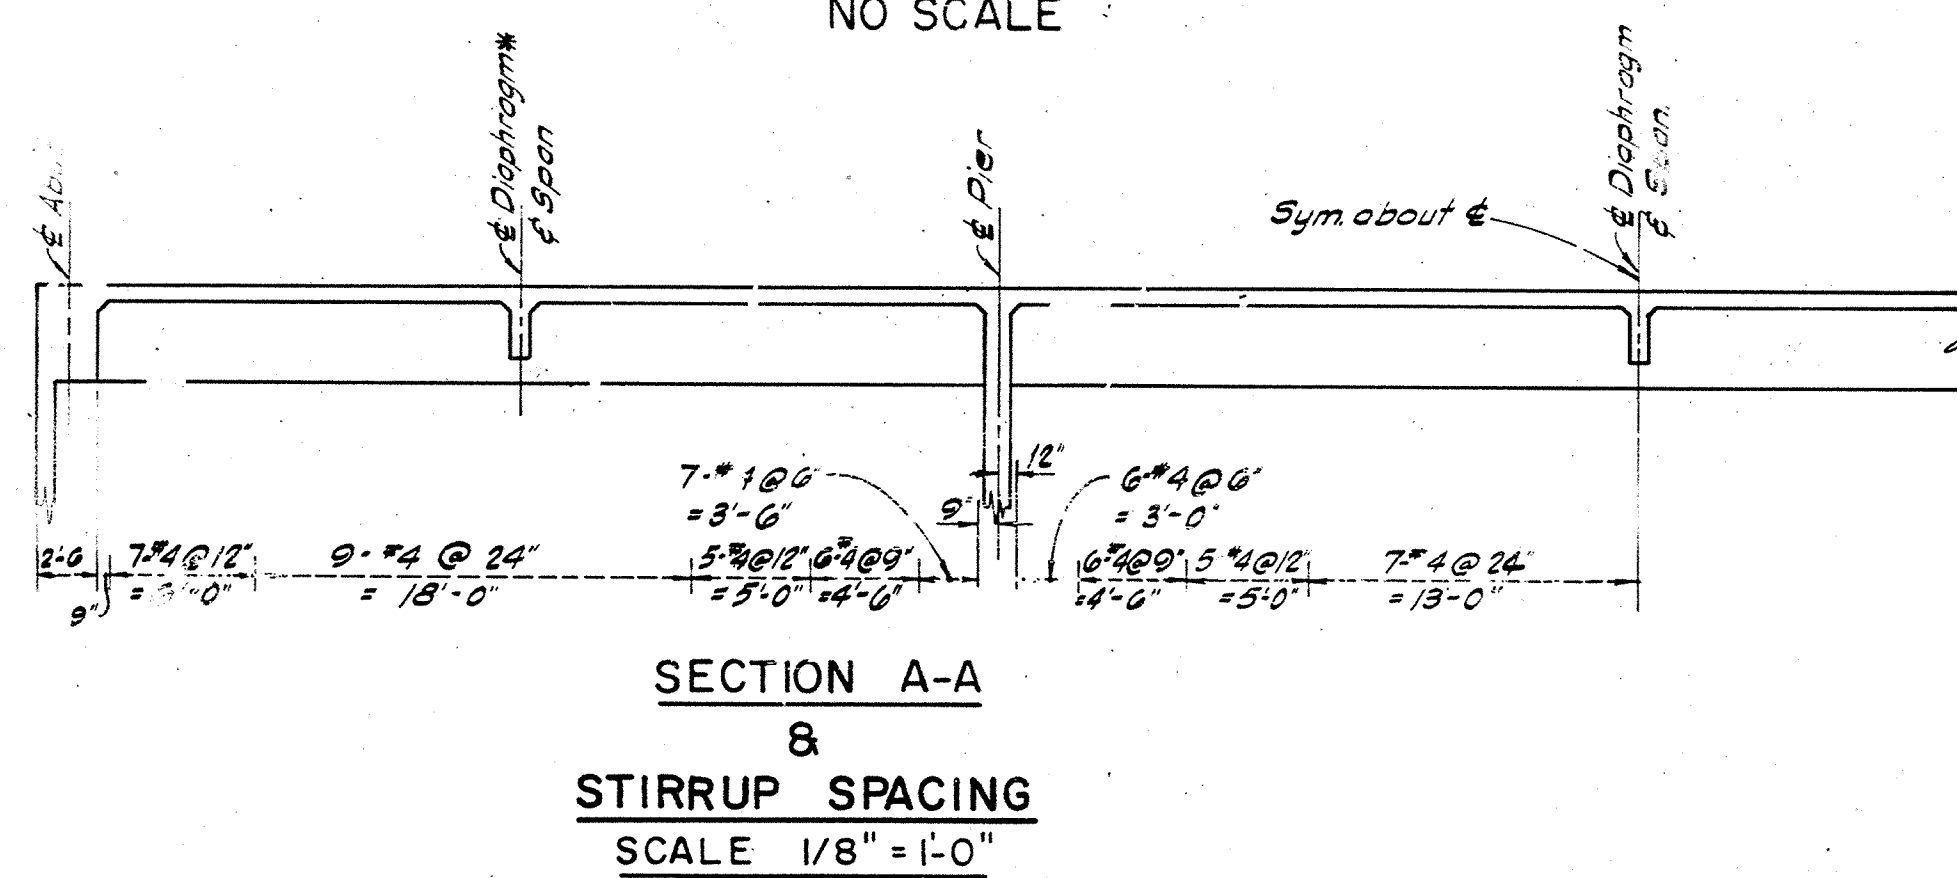


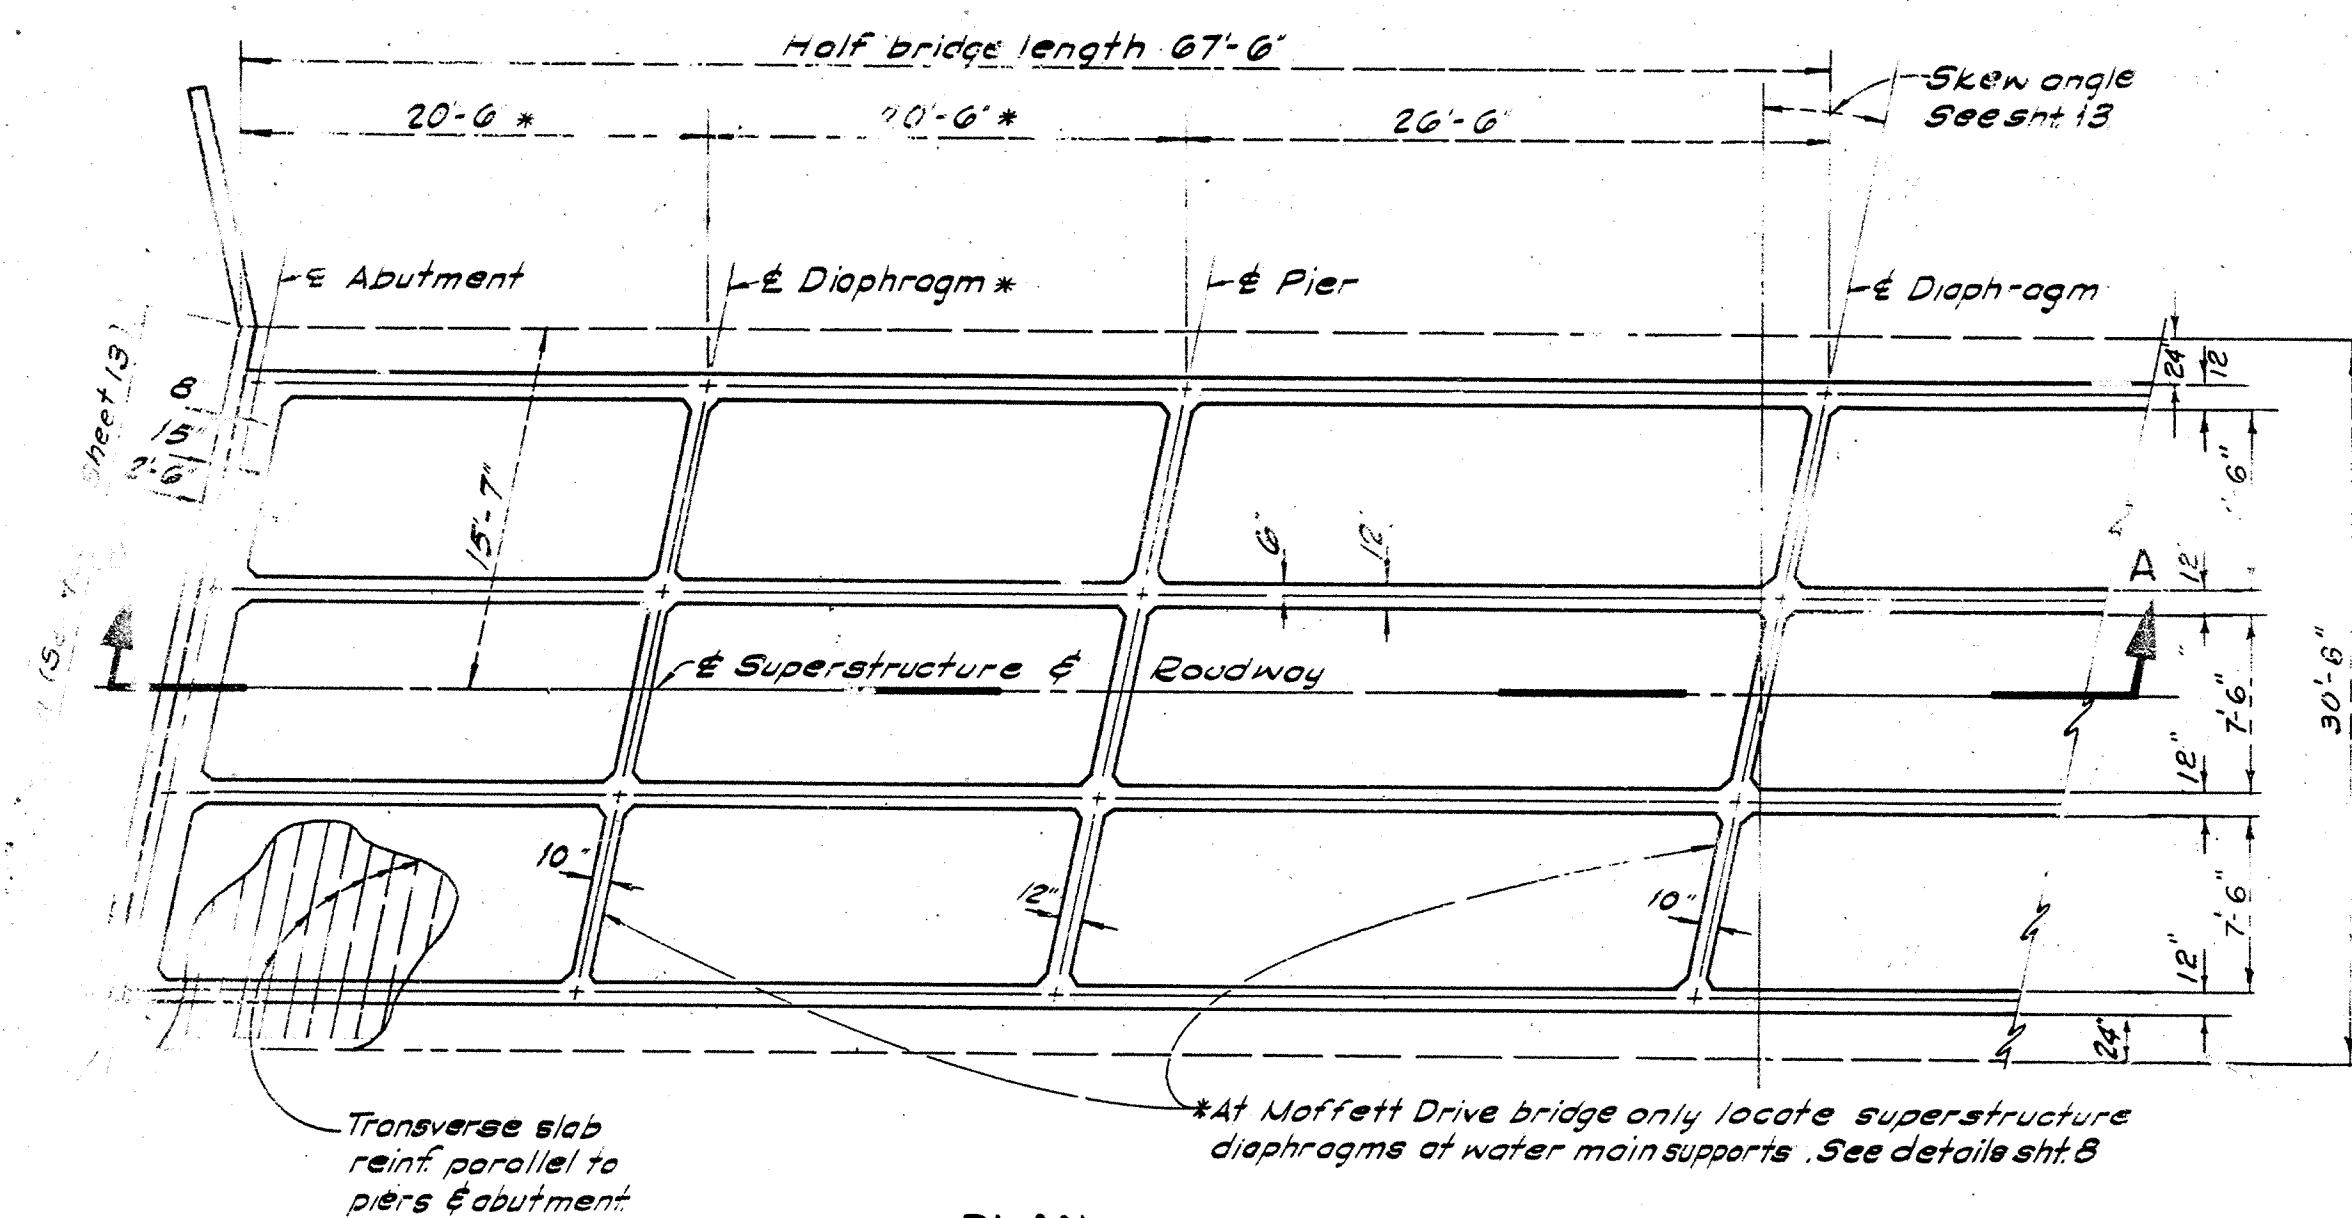

PRELIMINARY REVISION CODE			A		
Disregard Prints Bearing Earlier Codes			6-63		
REVISIONS			ORANGE COUNTY FLOOD CONTROL DISTRICT		
MARK	DATE	DESCRIPTION	PETERS CANYON CHANNEL		
			T-BEAM BRIDGE ALT.		
			DETAILS		
			REINFORCEMENT DETAILS		
DESIGNED	ELC		RECOMMENDED	J. L. C. C.	
DRAWN	RM	CHECKED	DESIGN DIVISION ENGINEER		
SUBMITTED	JWH	DESIGN ENGINEER	SCALE	DATE	DWG. NO
			AS SHOWN	JULY 1963	F06-101-2-A