


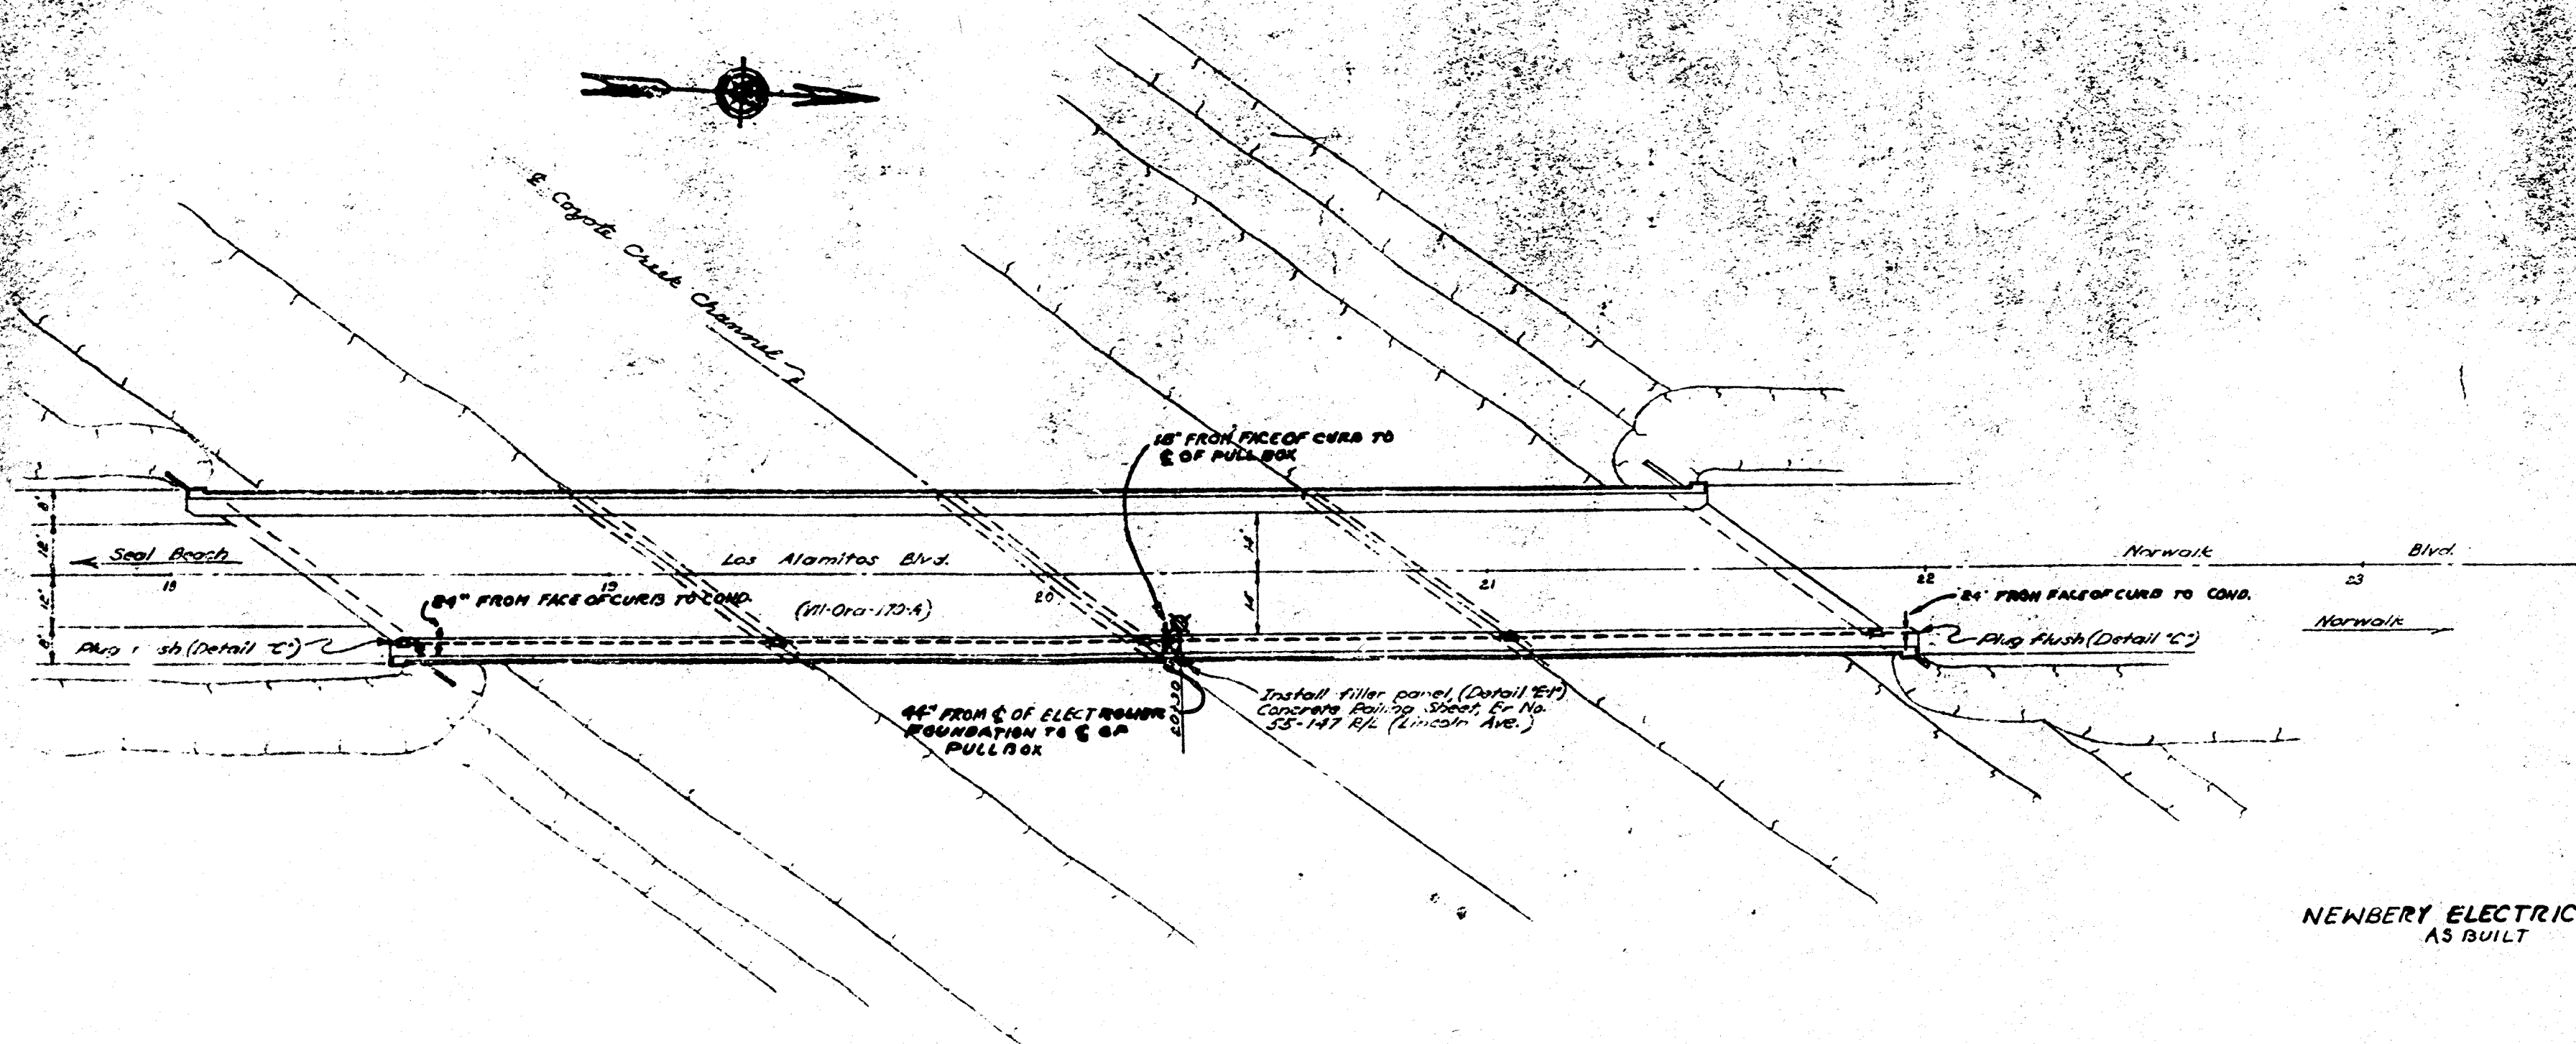

DATE	7/2/54	BY	W.M.
SCALE	1"=20'	FILE	55C-0052
PROJECT	COYOTE CREEK BRIDGE		
SHEET	11 OF 11		

SEP 17 1954
W.M.

BRIDGE DEPARTMENT



NEWBERY ELECTRIC CORP.
AS BUILT

R.D.F.

(11108)
AS BUILT CONSTRUCTION PLANS-BRIDGE
Sheet 11 of 11
Red. 22.5:1
Velium

Notes -
1. For Electrical Legend see Coyote Creek Bridge - Lighting Plan (Br. No. 55-147 R/L) (Lincoln Ave.)
2. For Electrical Details and "Lighting Reinforcement" sheets see Coyote Creek Bridge - Plans (Br. No. 55-147 R/L) (Lincoln Ave.)

NOTE: THIS PLAN ACCURATE FOR LIGHTING ONLY

STATE OF CALIFORNIA DEPARTMENT OF PUBLIC WORKS DIVISION OF HIGHWAYS			
COYOTE CREEK BRIDGE			
55C-52 LIGHTING PLAN			
SCALE AS NOTED	BRIDGE 55-147	FILE	DRAWING

#11108
Los Alamitos BR
over COYOTE CREEK - Approv Sept/1954
CO-38
55C-0052
Thomas 796-J1