


FED. ROAD DIST. NO.	STATE	PROJ. NO.	FISCAL YEAR	SHEET NO.	TOTAL SHEETS
7	CAL.			29	26

DATE	COUNTY	ROUTE	SECTION	SHEET NO.	TOTAL SHEETS
VII	Ora	170	A	10	10

DESIGNED BY: *Edna S. K. [Signature]*
 DATE APPROVED: SEPTEMBER 27, 1954
 APPROVED BY: *E. M. Webb [Signature]*

"As Built"
 No Corrections
 C.E. Hill Jr. P.E.
 3-7-56

BRIDGE DEPARTMENT

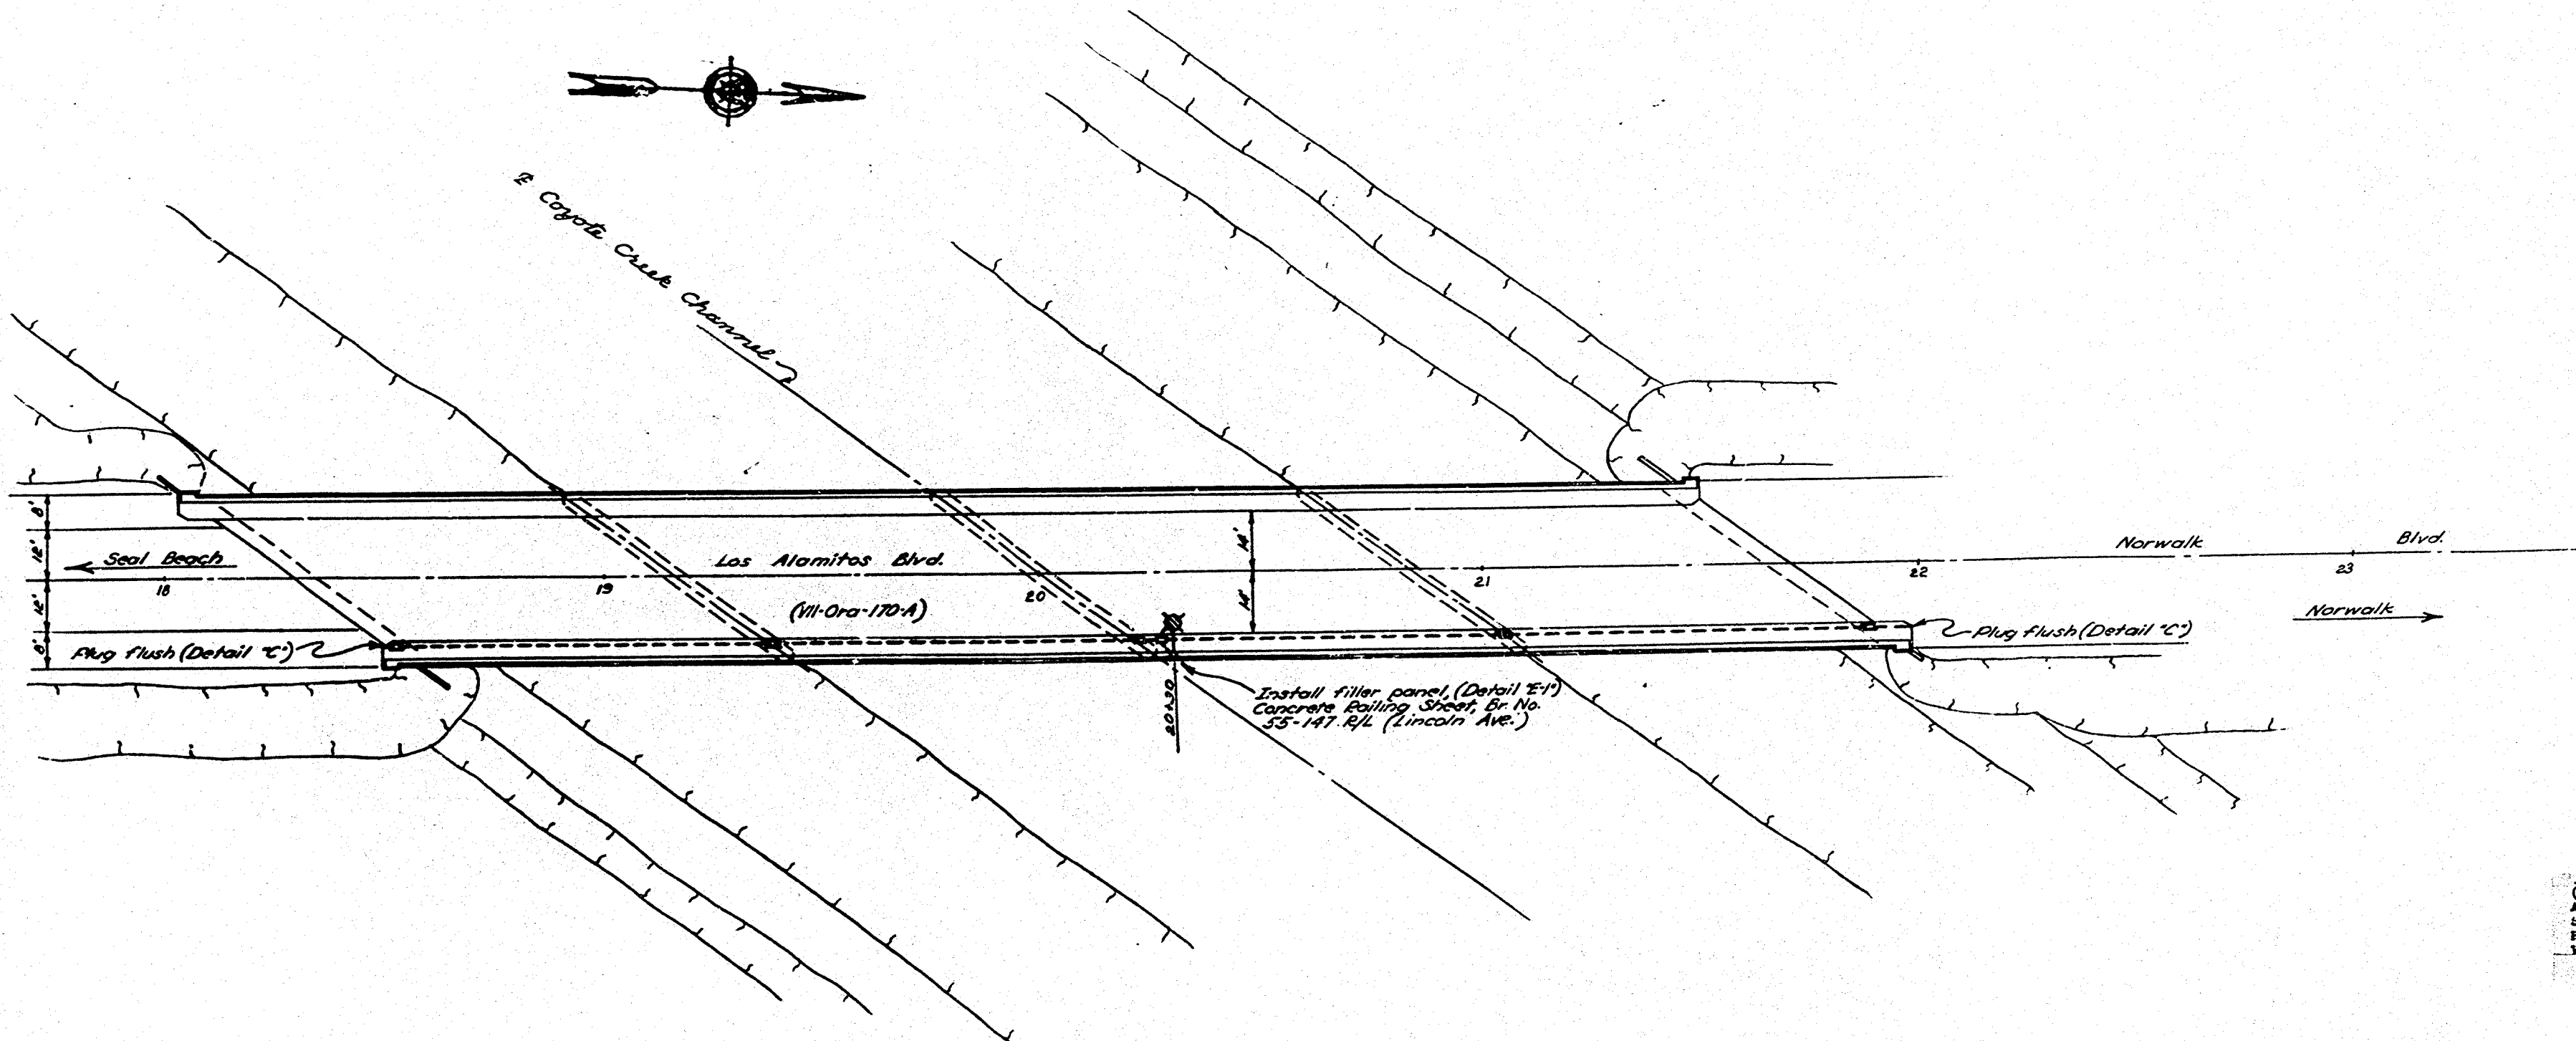

PLAN
1"=20'

Notes:
 1. For Electrical Legend see Coyote Creek Bridge-Lighting Plan (Br No. 55-147 R/L) (Lincoln Ave.)
 2. For "Electrical Details" and "Lighting Reinforcement" sheets see Coyote Creek Bridge-Plans (Br No. 55-147 R/L) (Lincoln Ave.)

(11108)
 AS BUILT CONSTRUCTION PLANS-BRIDGE
 Sheet 10 of 11
 Date: 22, 5-1
 William

NOTE: THIS PLAN ACCURATE FOR LIGHTING ONLY

STATE OF CALIFORNIA DEPARTMENT OF PUBLIC WORKS DIVISION OF HIGHWAYS			
COYOTE CREEK BRIDGE			
55C-52		LIGHTING PLAN	
SCALE As Noted	BRIDGE 36-106	FILE	DRAWING

Bridges (11108)