




1. Contractor shall provide 2 sa. renewable padlocks as required. PSI-Best Co.
2. Hinged access door.
3. Contractor to furnish Photo Cell.
4. Contractor to furnish one 15A circuit breaker for control circuit and three #12 THW stranded conductors with tracers.
5. The control cabinet shall be mounted on a 12-1/2" x 4-1/4" mounting collar pad to be supplied by the cabinet manufacturer.

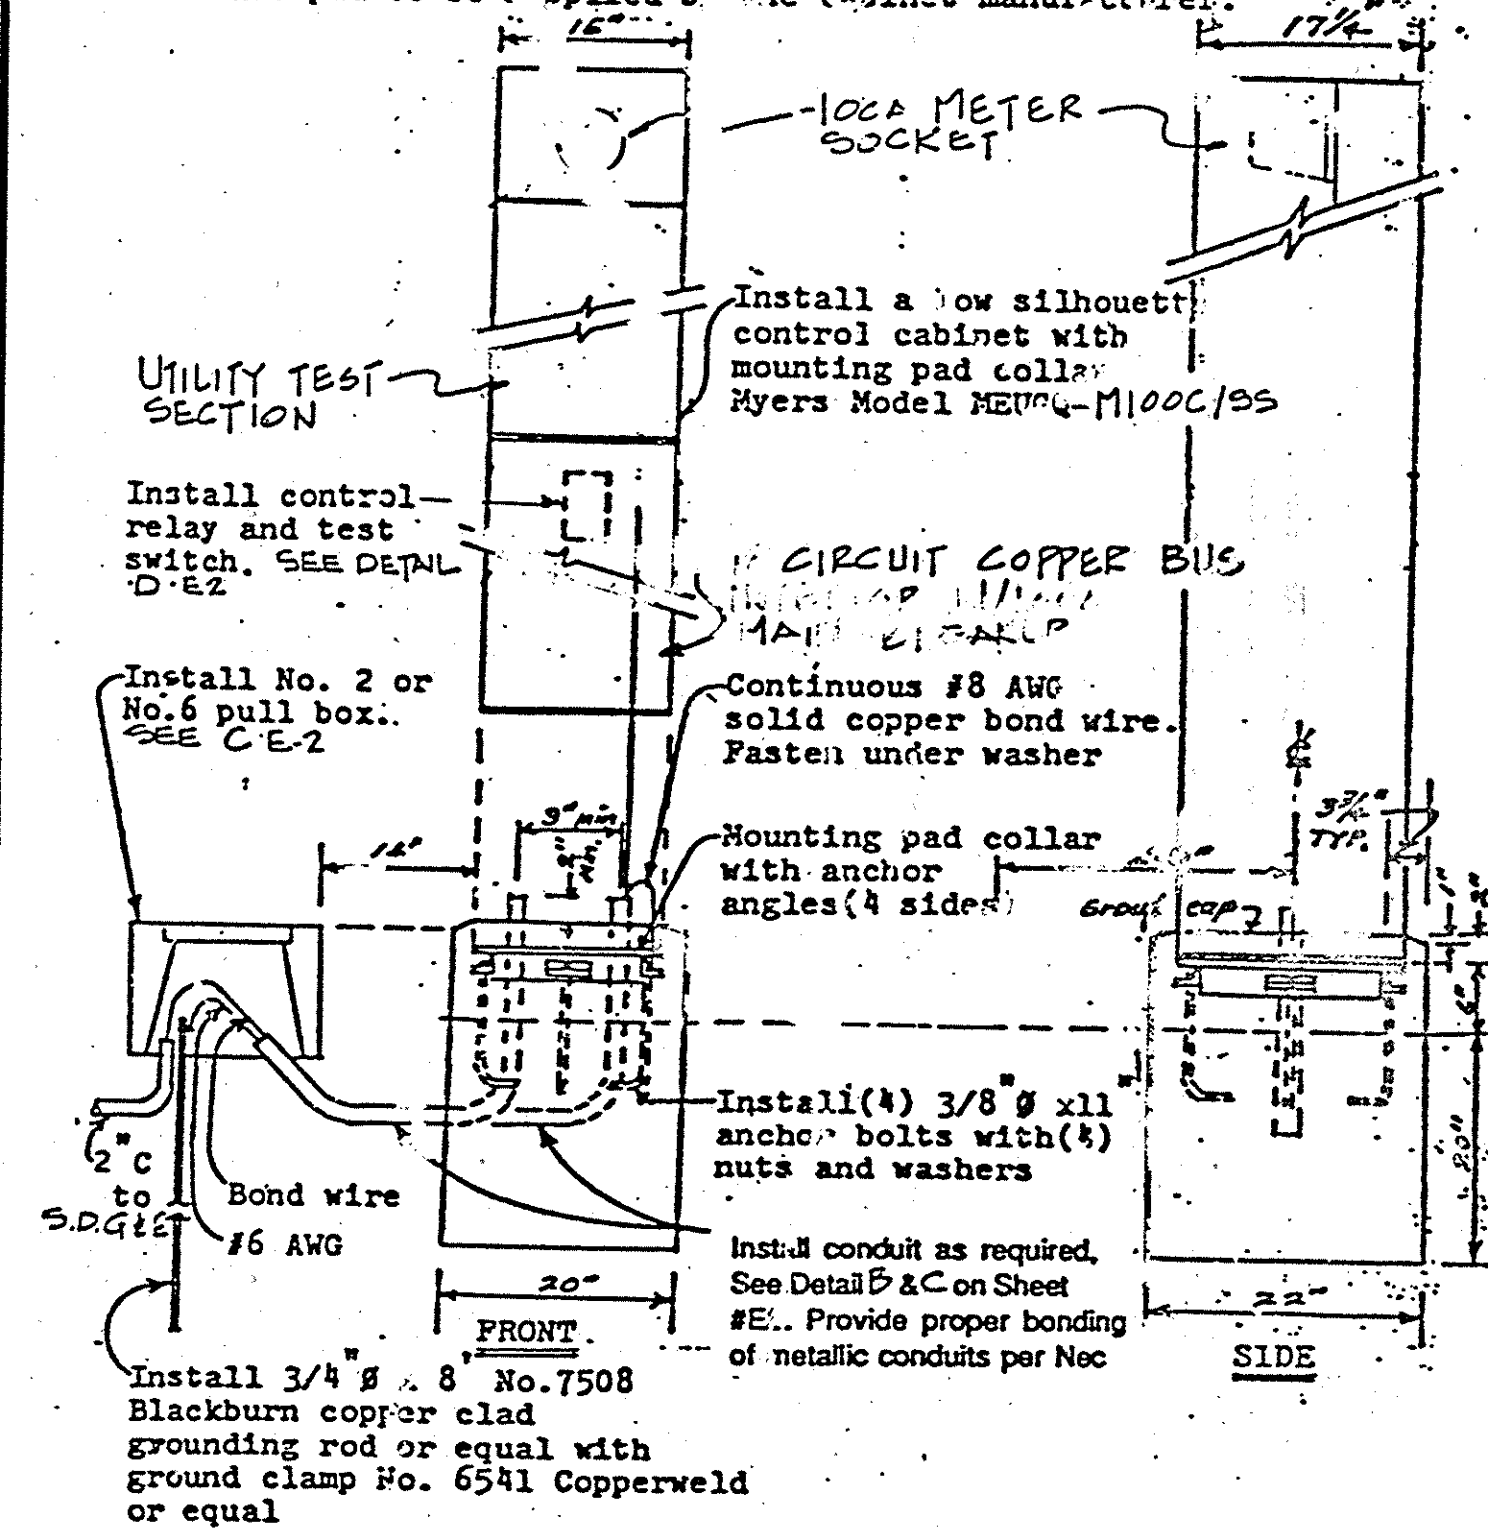

MULTIPLE CIRCUIT CONTROL CABINET & FOUNDATION

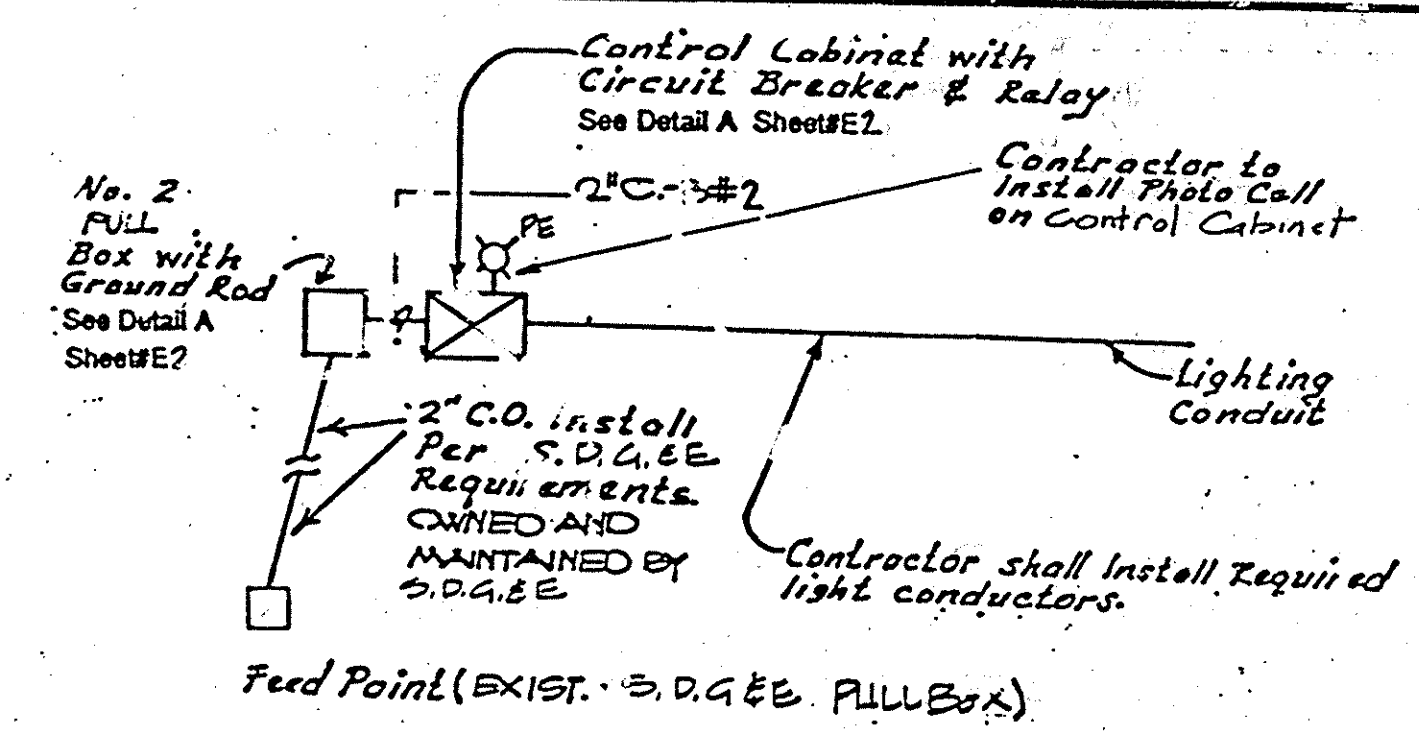


DETAIL OF FEED POINT W/ P.E.

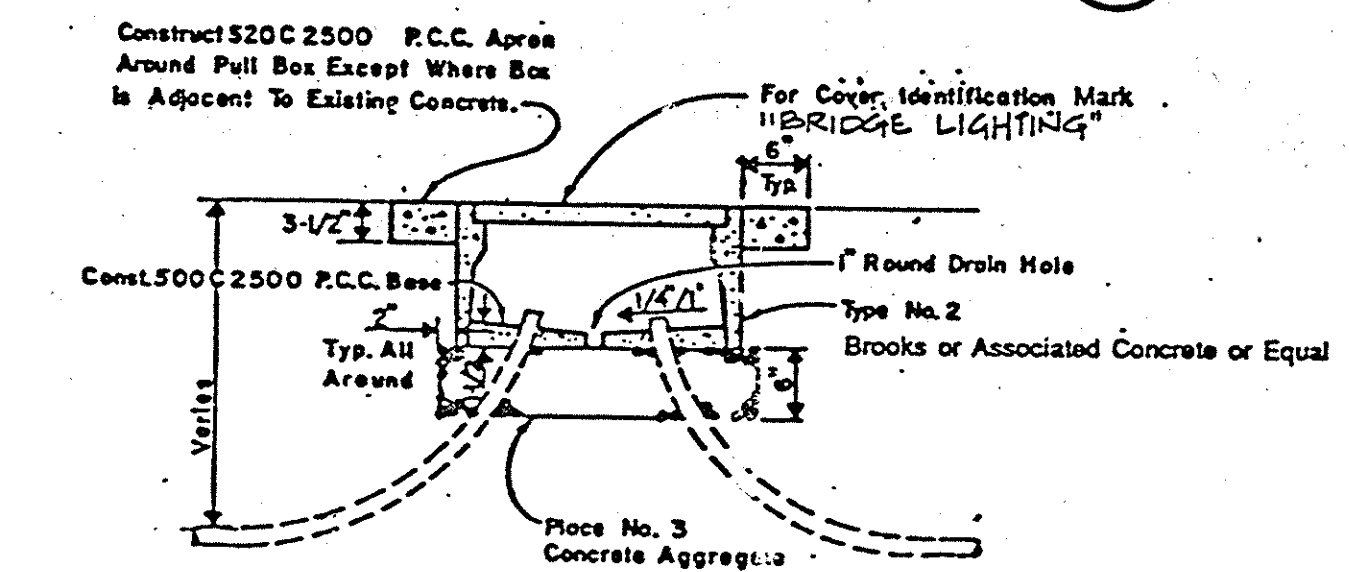


TYPICAL PULL BOX INSTALLATION

PULL BOX TYPE NO. 2

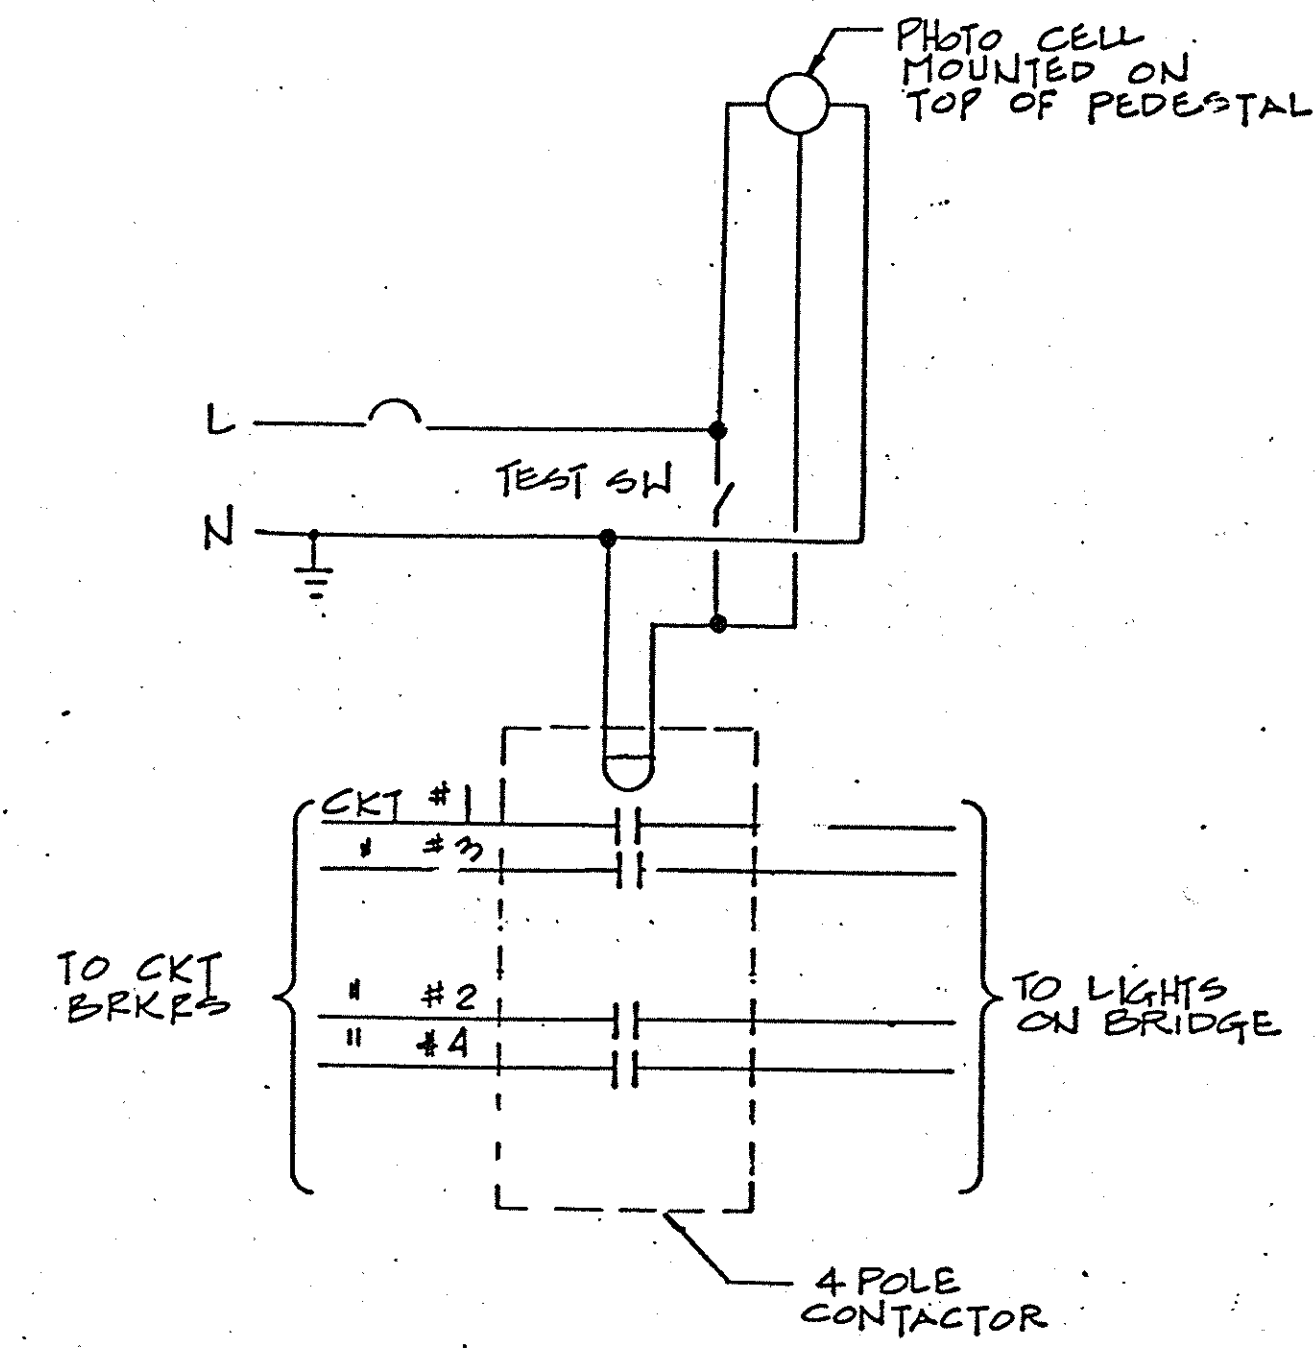


CONTROL DIAGRAM

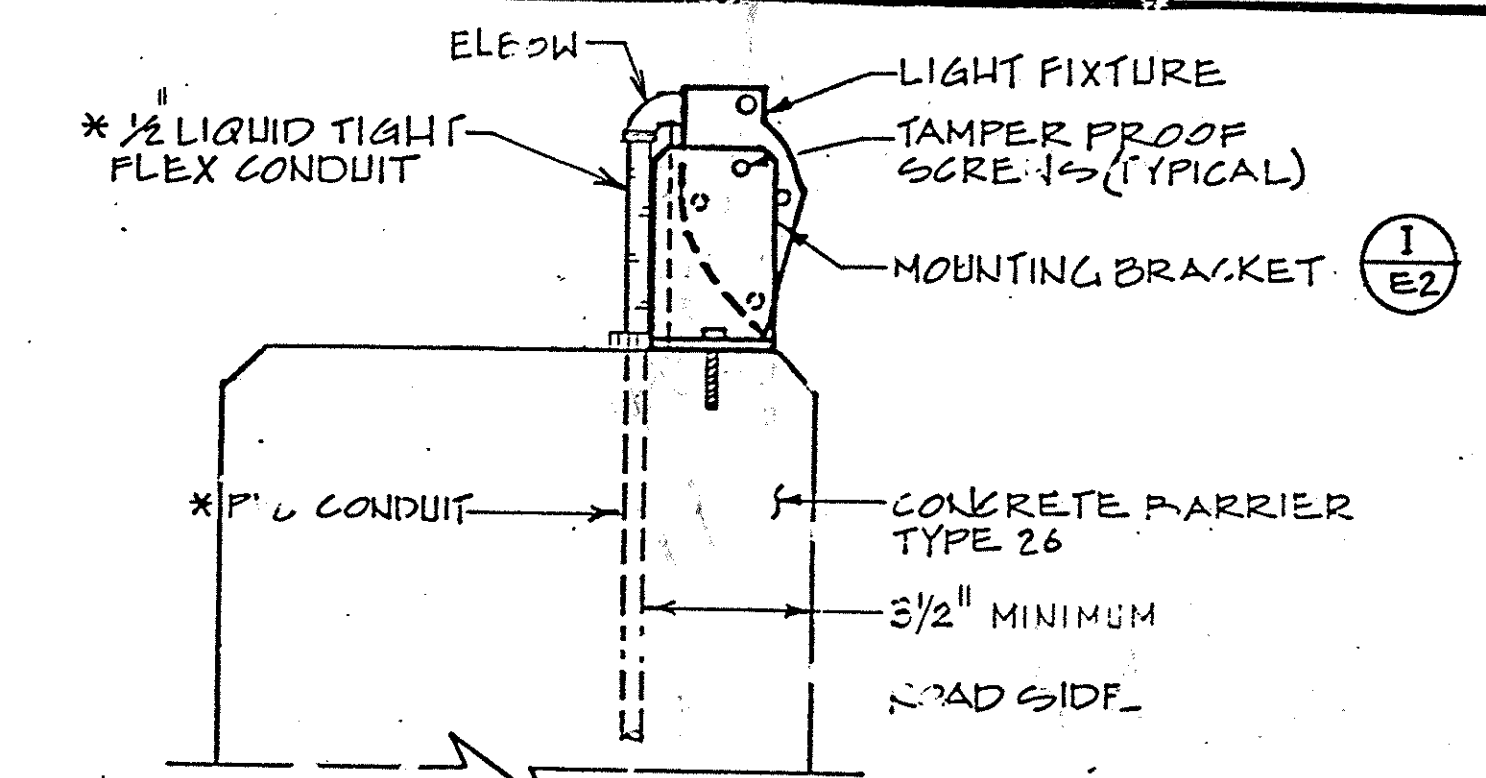


* CONTRACTOR SHALL PROVIDE A GROUND WIRE CONTINUOUS FROM PANEL GROUND THROUGH ALL NON-METALLIC CONDUIT AND LIQUID TIGHT FLEX CONDUITS TO FIXTURES.

FIXTURE MOUNTING DETAIL


1/4" = 1'-0"

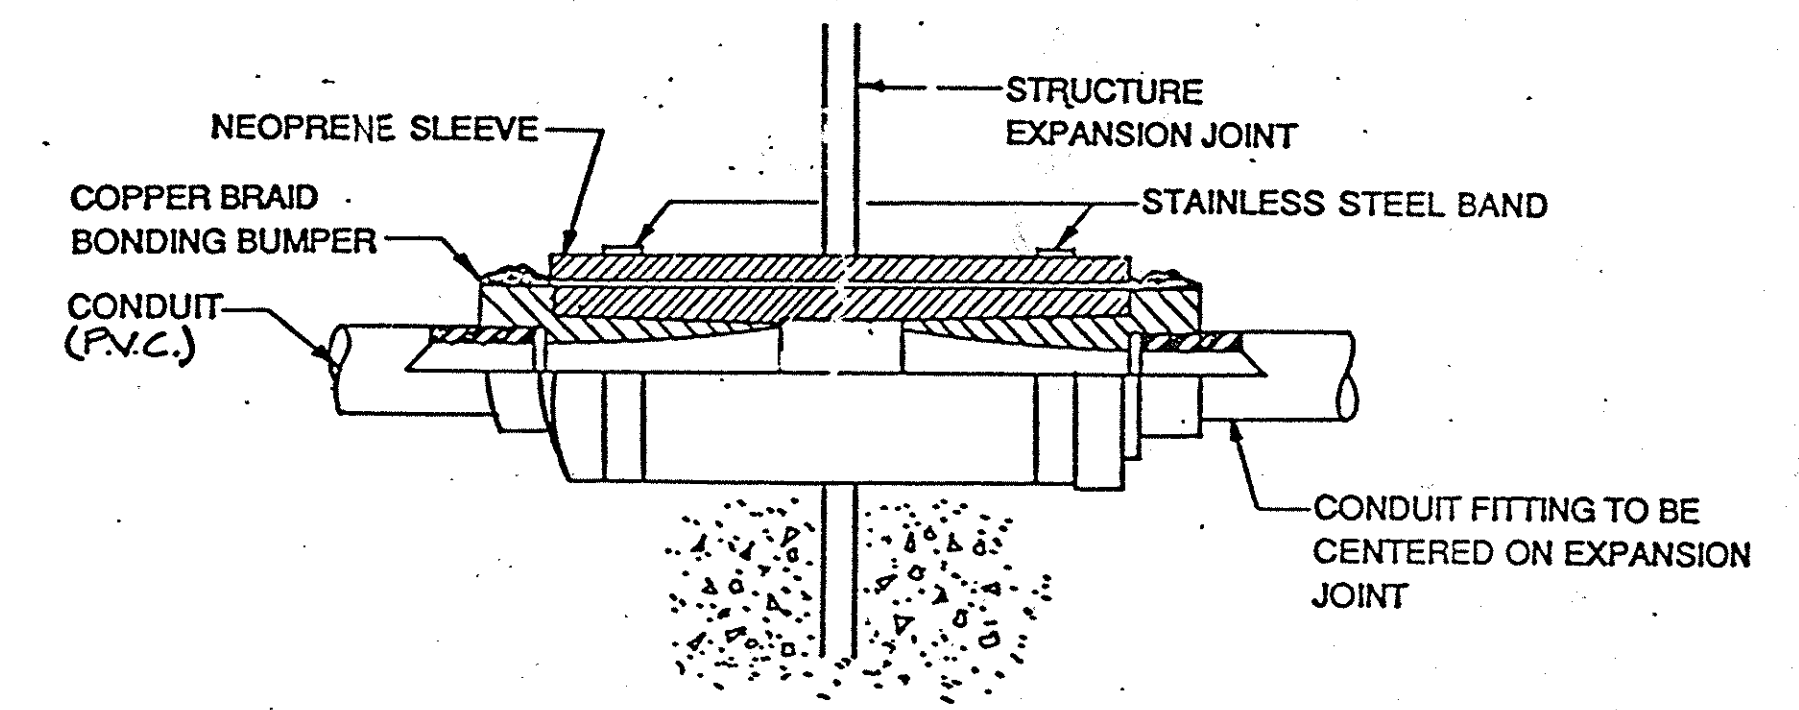

DETAIL Y CONDUIT EXPANSION DEFLECTION FITTING

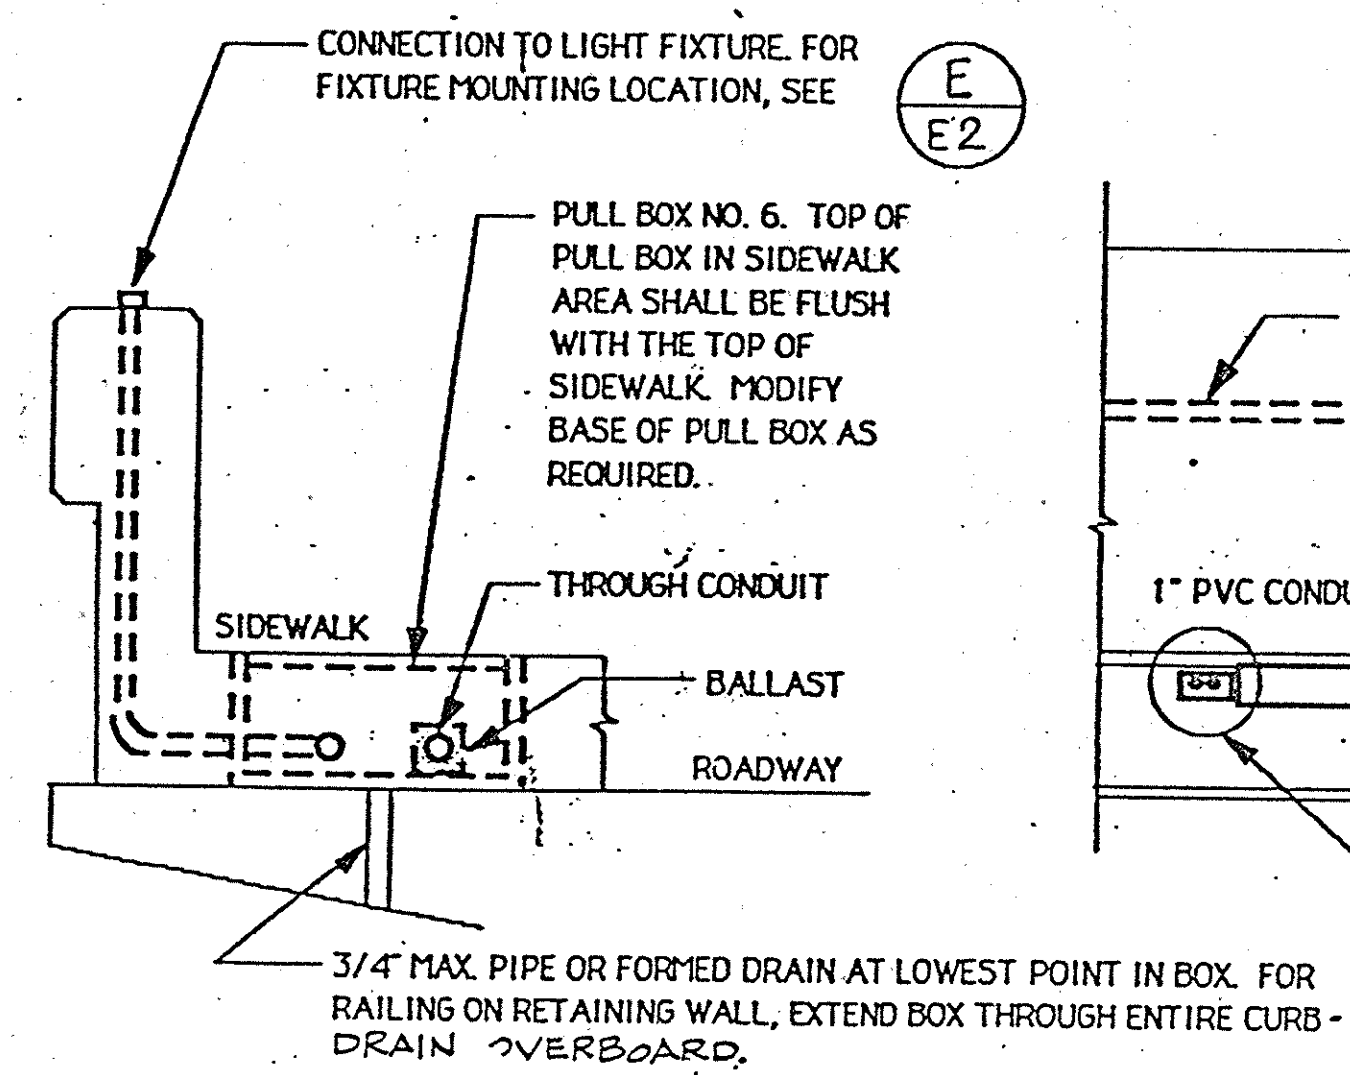

SECTION

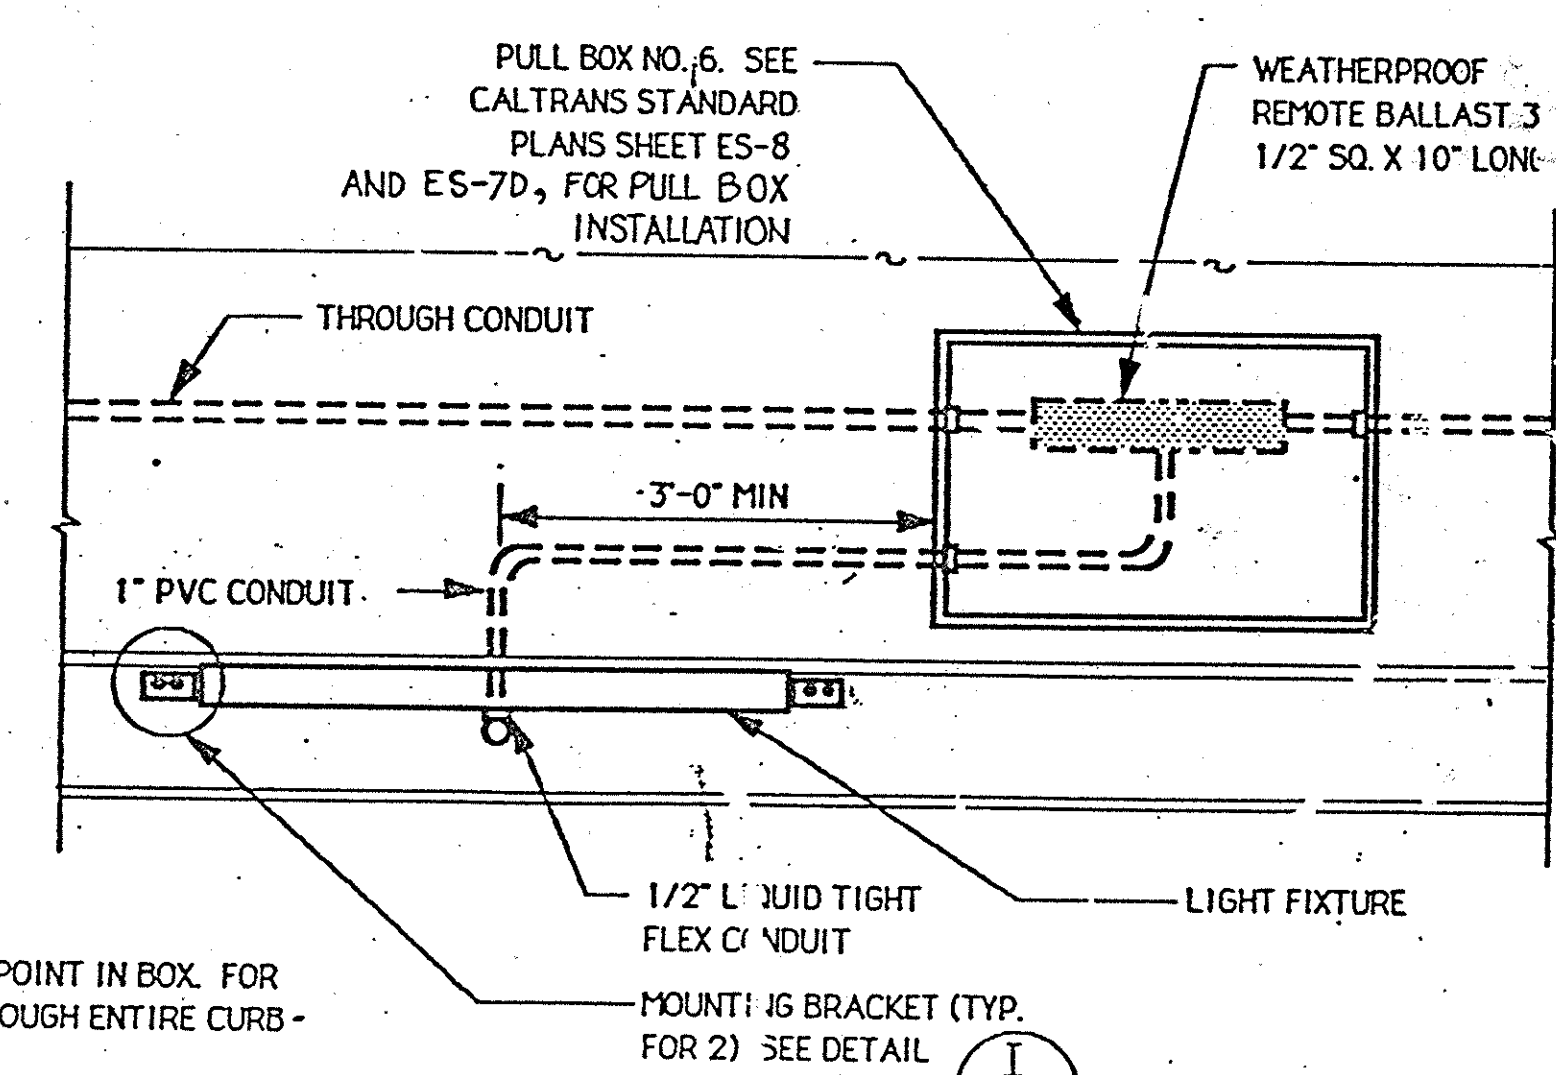


TOP VIEW


FIXTURE & PULL BOX NO. 6 MOUNTING DETAIL

3/4" = 1'-0"

FOR CONCRETE BARRIER TYPE 26

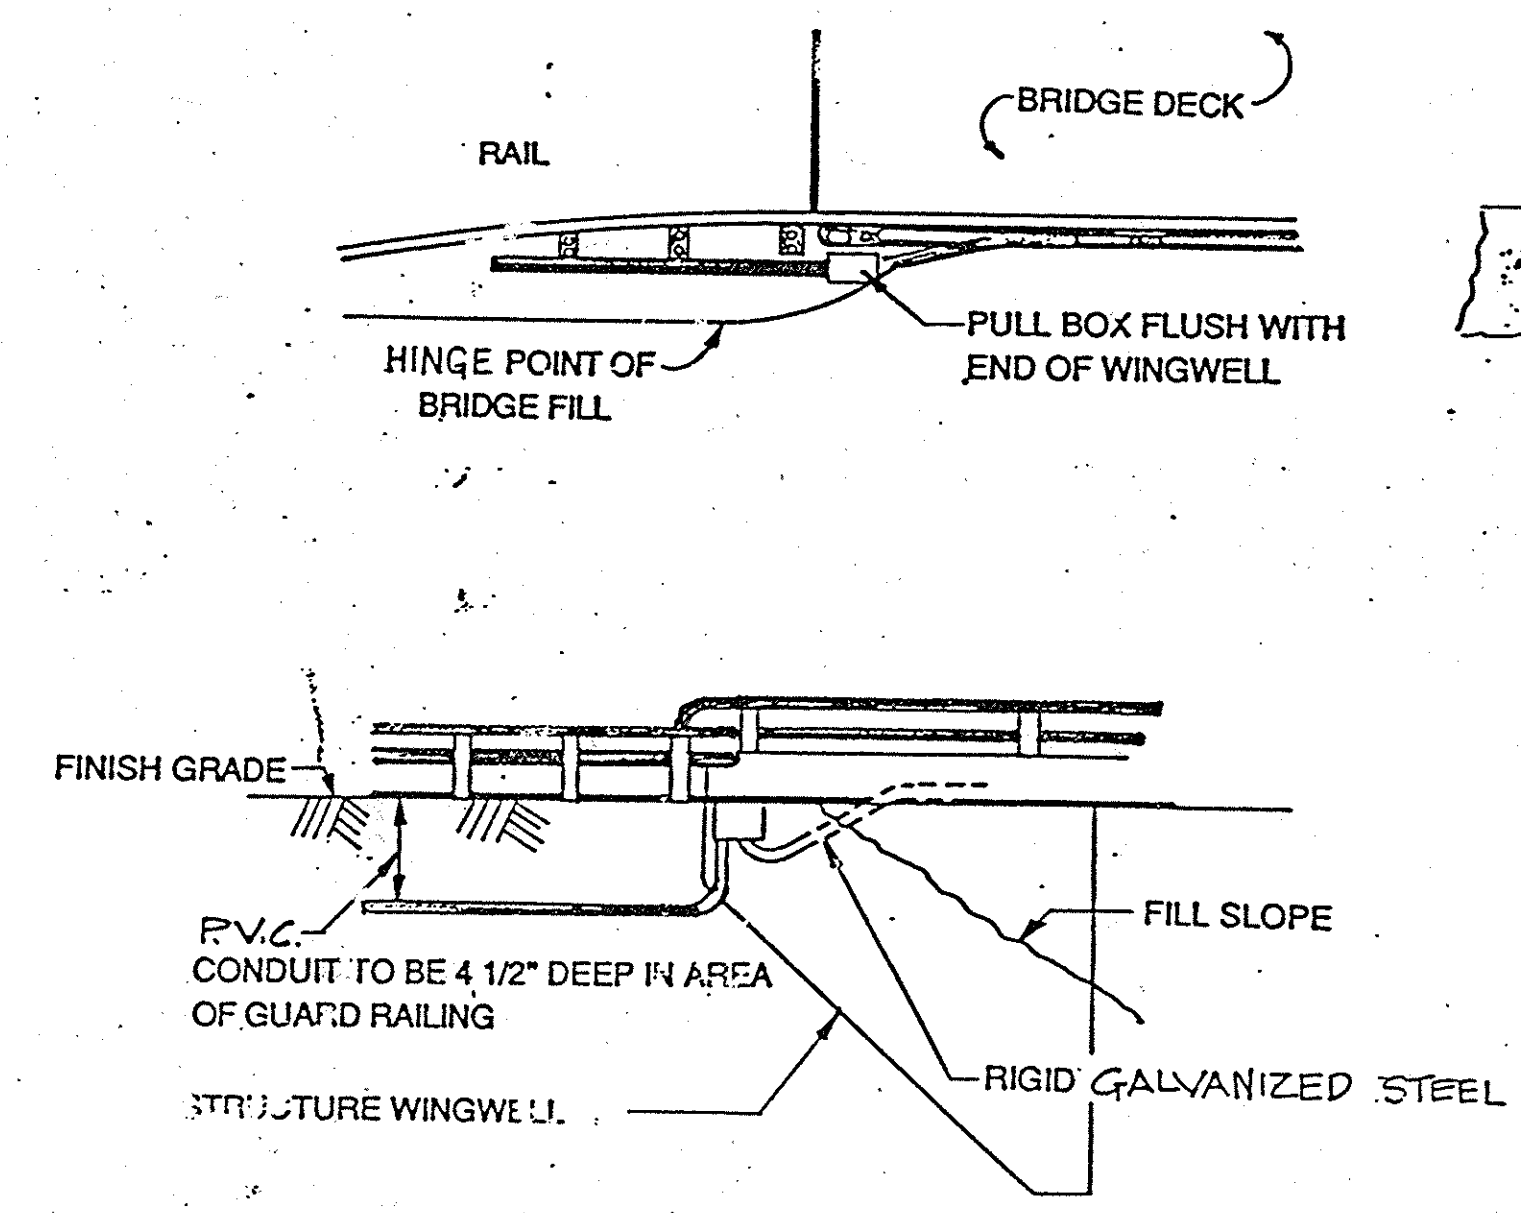


DETAIL I CONDUIT TERMINATION

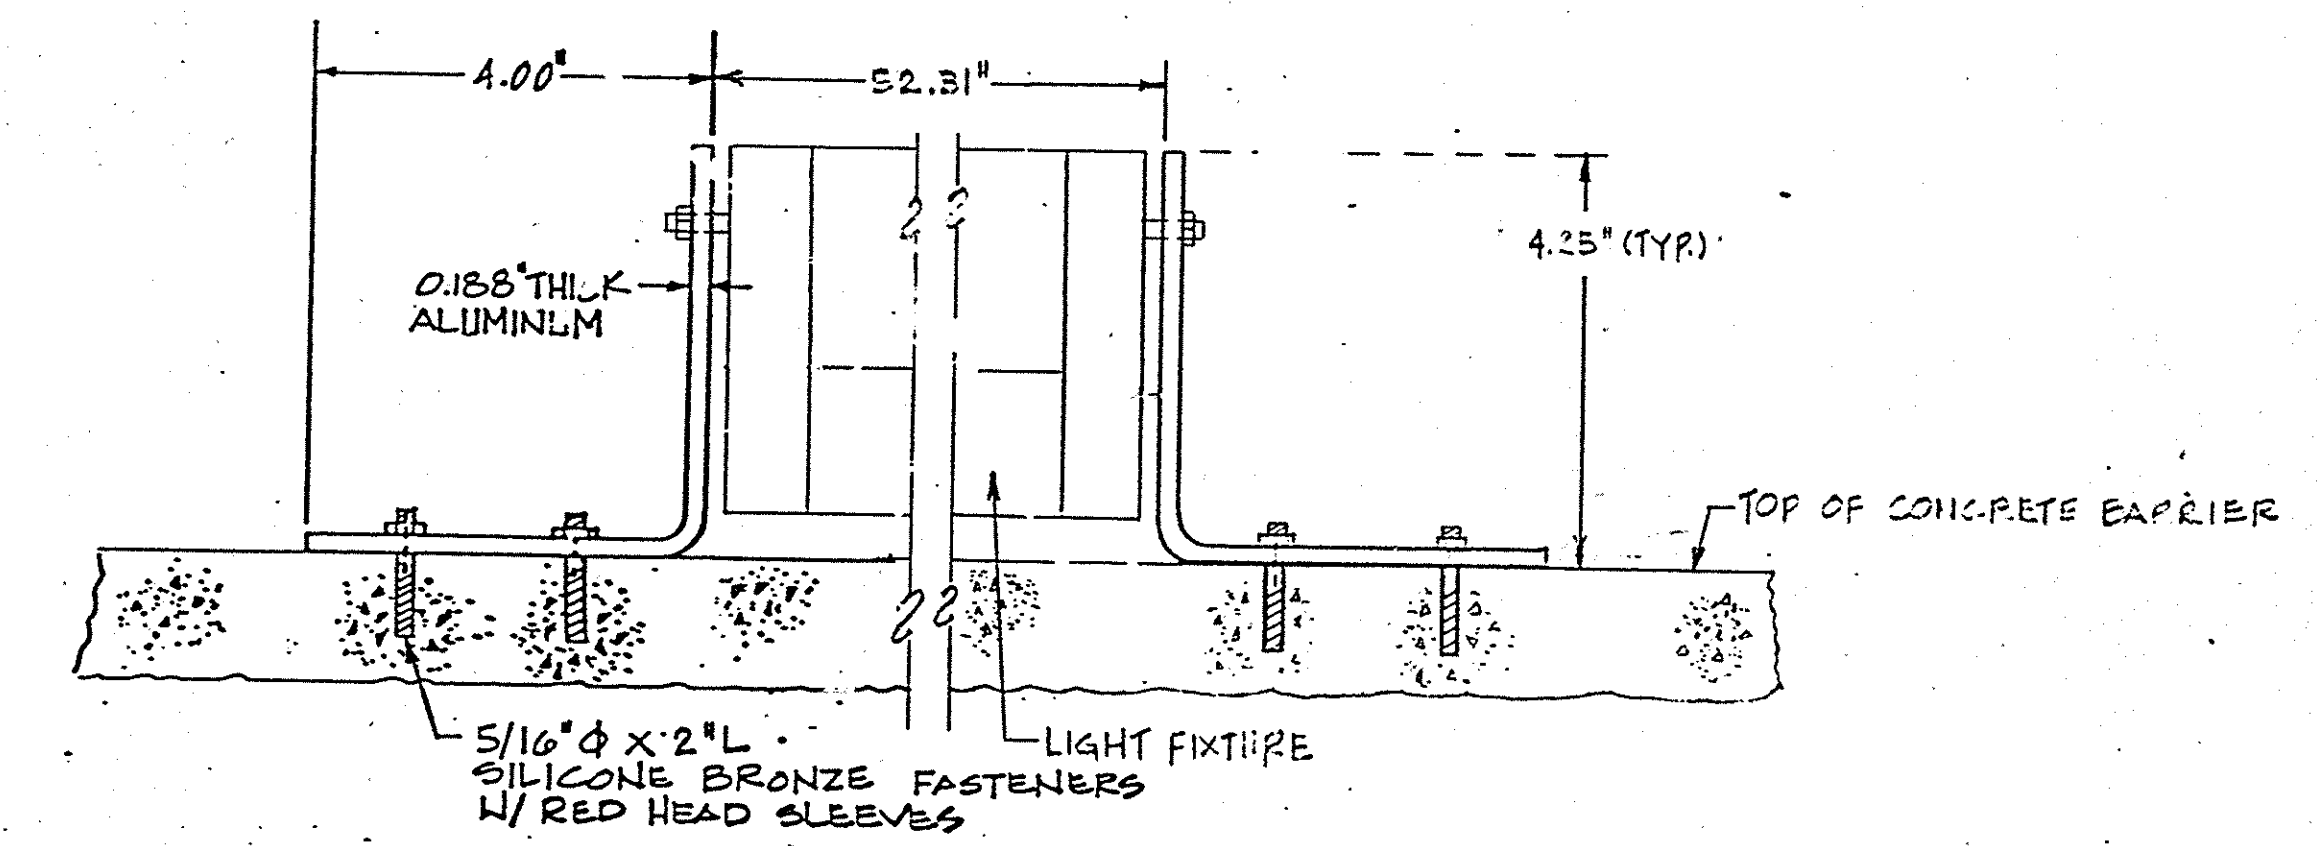

MOUNTING BRACKET DETAIL

1 1/2 0 1 2
3 inches on original drawing

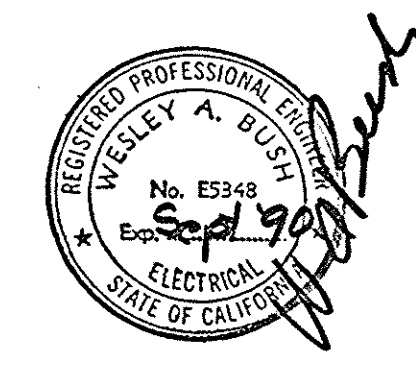

SPARVAN INCORPORATED
ELECTRICAL & CONTROL SYSTEM ENGINEERS
4140 NORSE WAY
LONG BEACH, CA 90808
PHONE (213) 425-1233

ORANGE COUNTY ENVIRONMENTAL MANAGEMENT AGENCY		OSO PARKWAY BRIDGE OVER ARROYO TRABUCO	
BRIDGE LIGHTING DETAILS		SHEET 57 OF 76	
DATE	DESCRIPTION	PREPARED UNDER SUPERVISION OF	DATE
DESIGNED	REVISIONS	SCALE	DWG. NO.
DRAWN	CHECKED	W.A.B.	AS SHOWN