



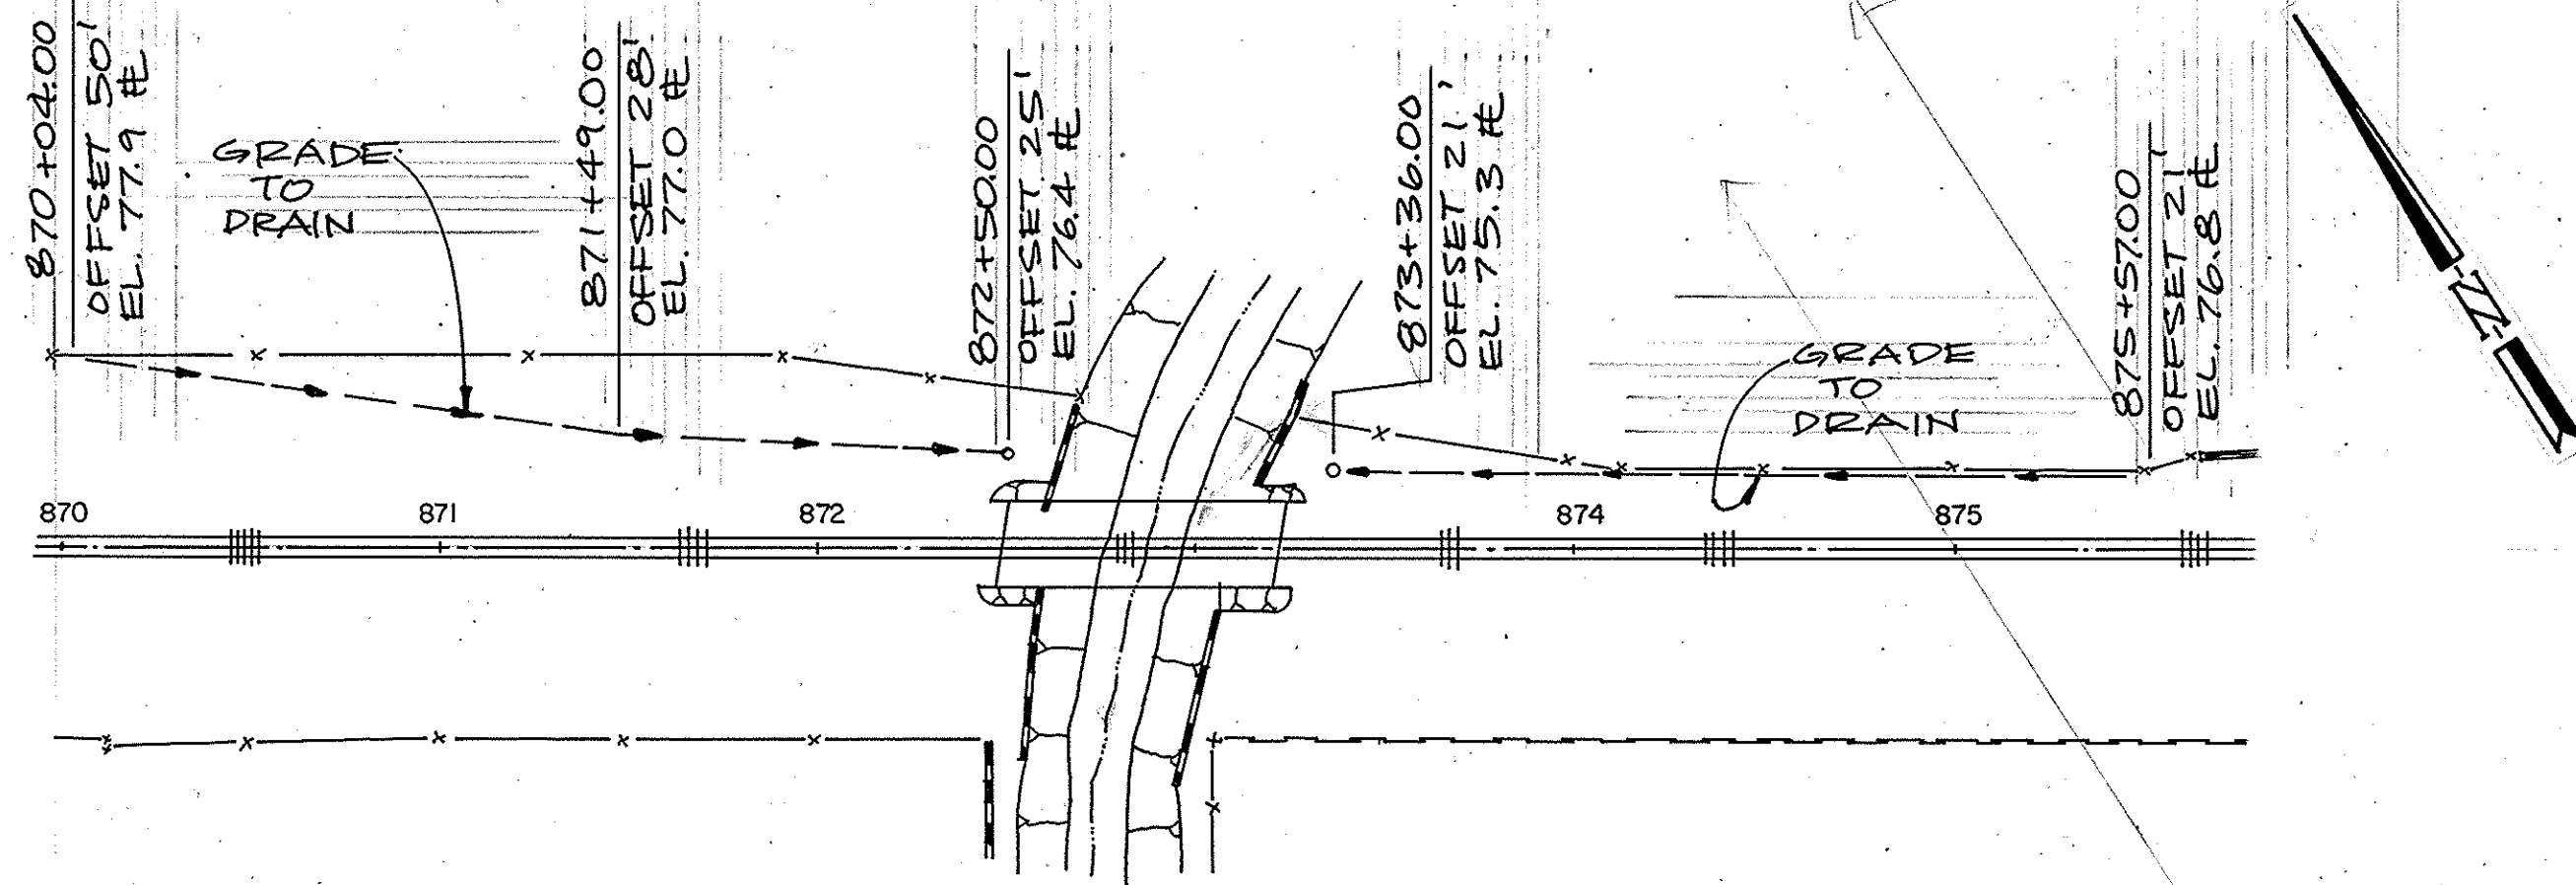


GRADING PLAN

SCALE: 1" = 50'

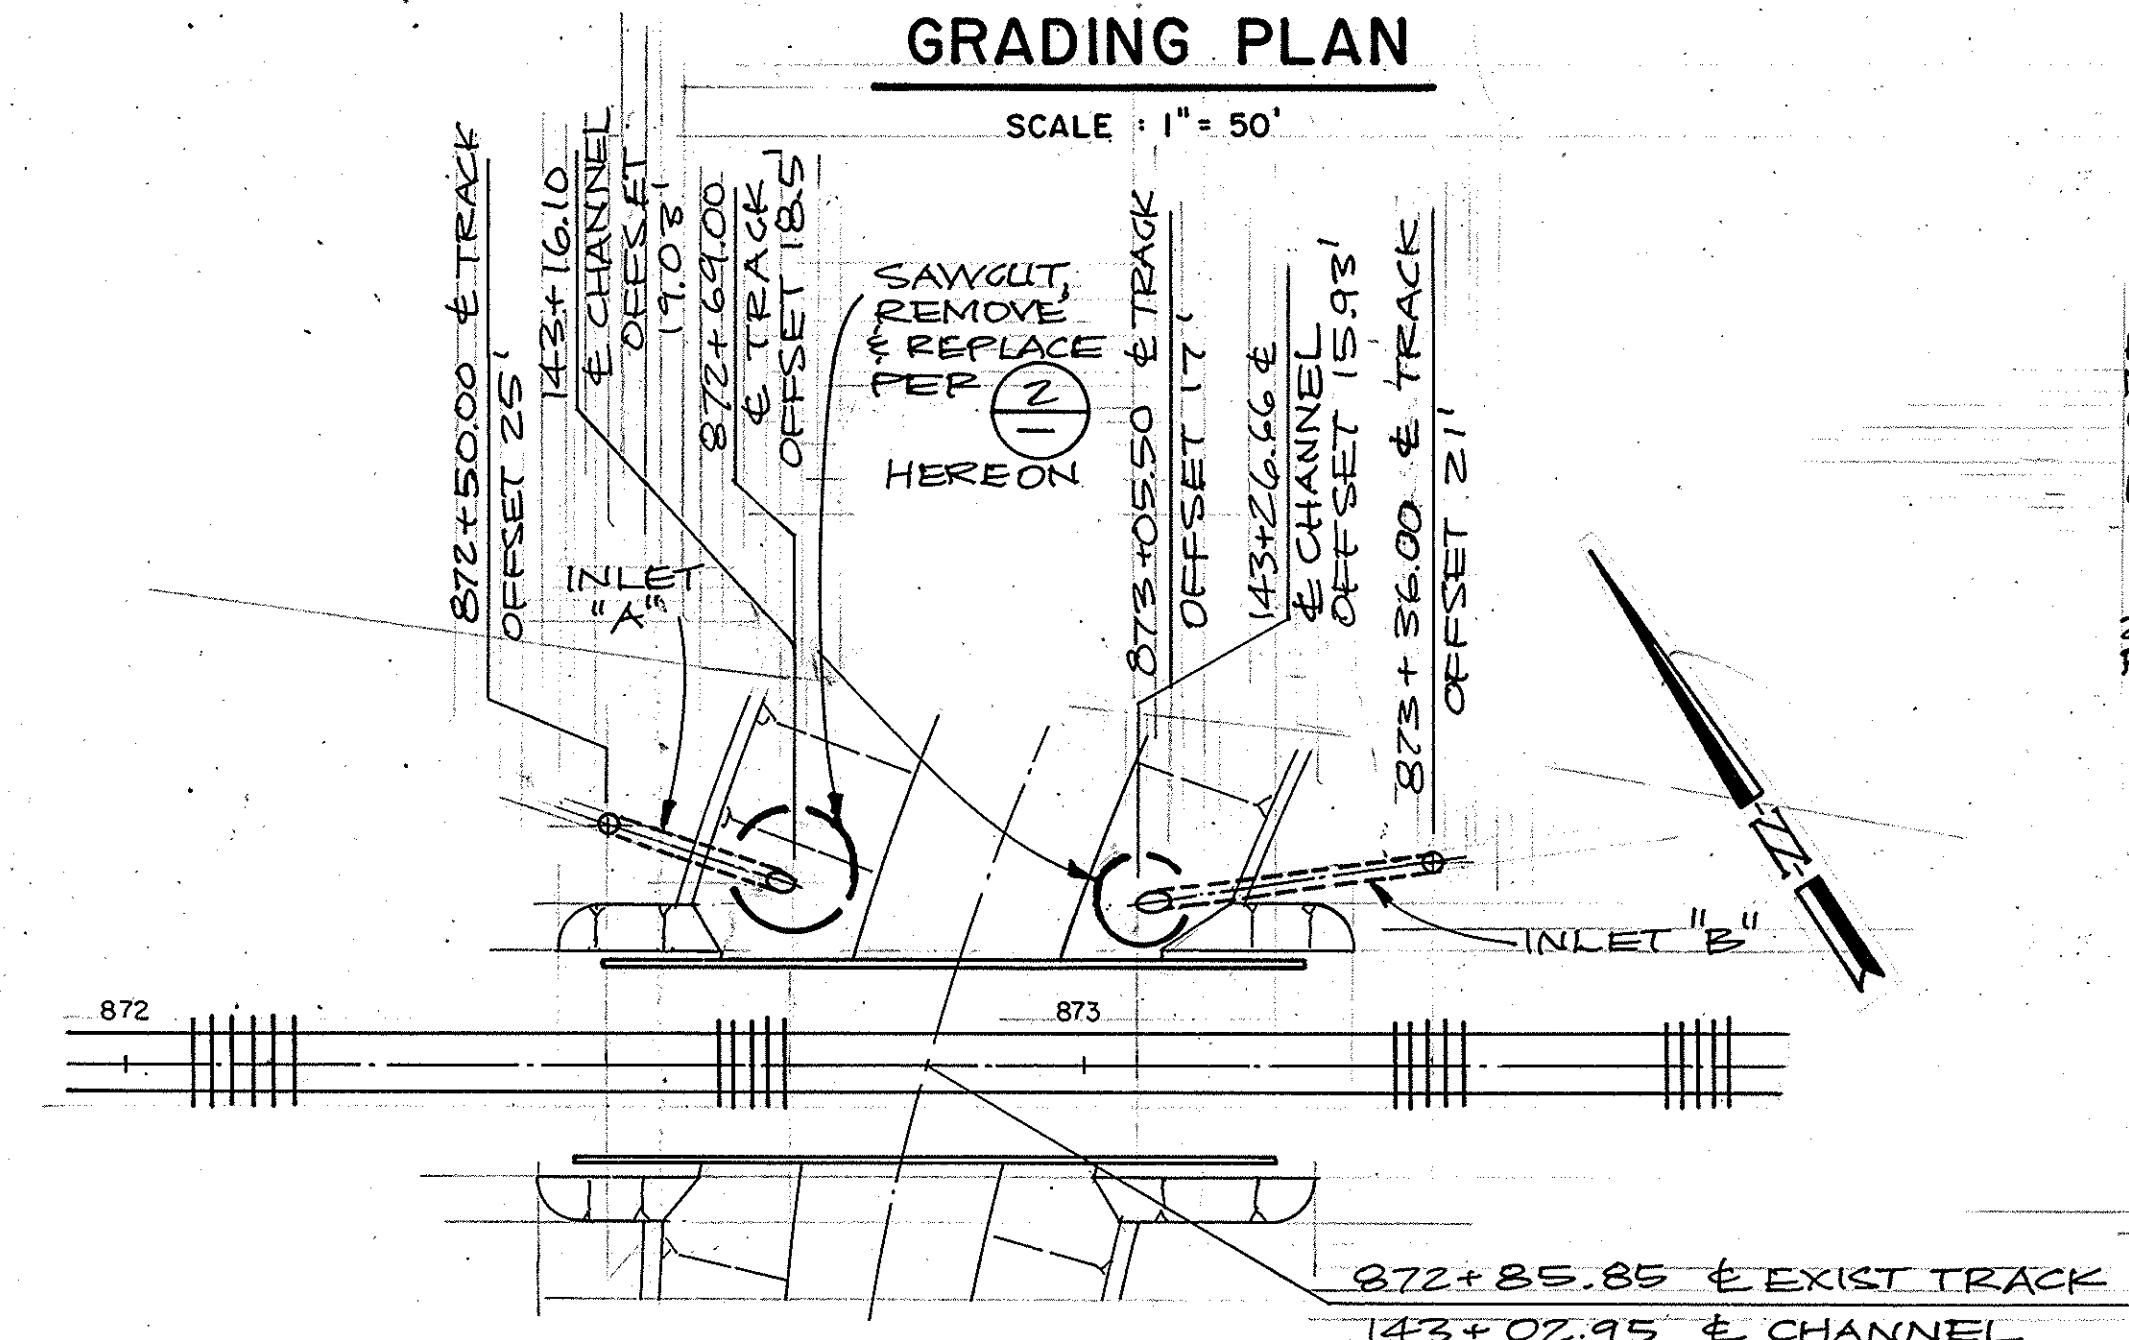

INLET LOCATION PLAN


SCALE: 1" = 20'

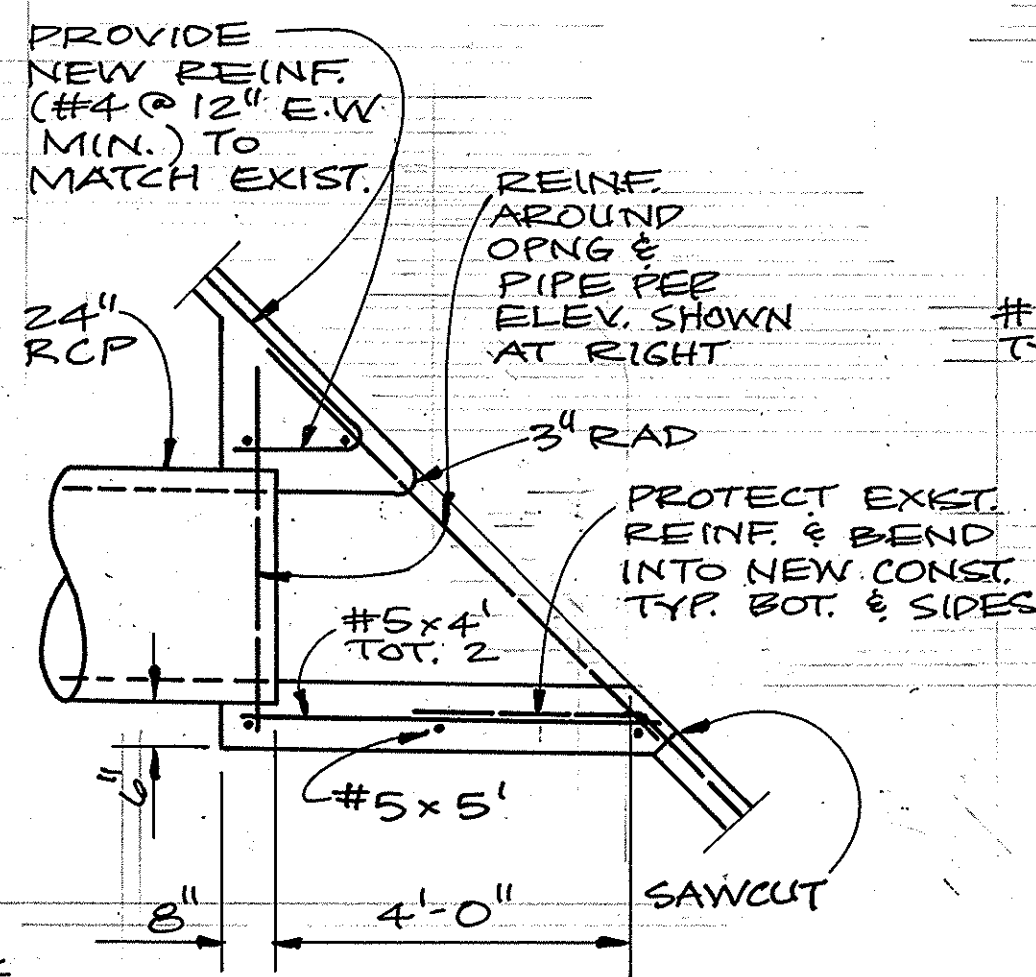

SECTION

RCP CHANNEL CONNECTION


NO SCALE

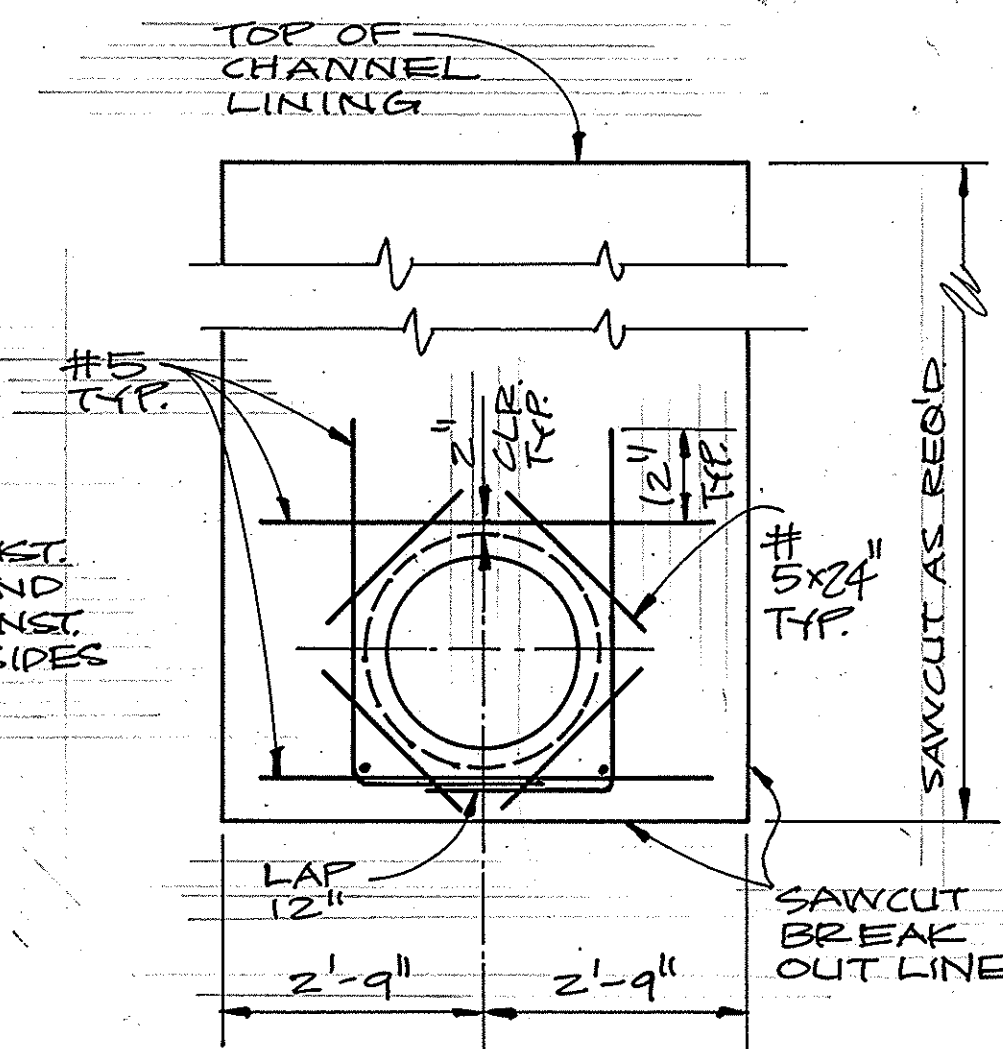

ELEVATION


RCP CHANNEL CONNECTION

2

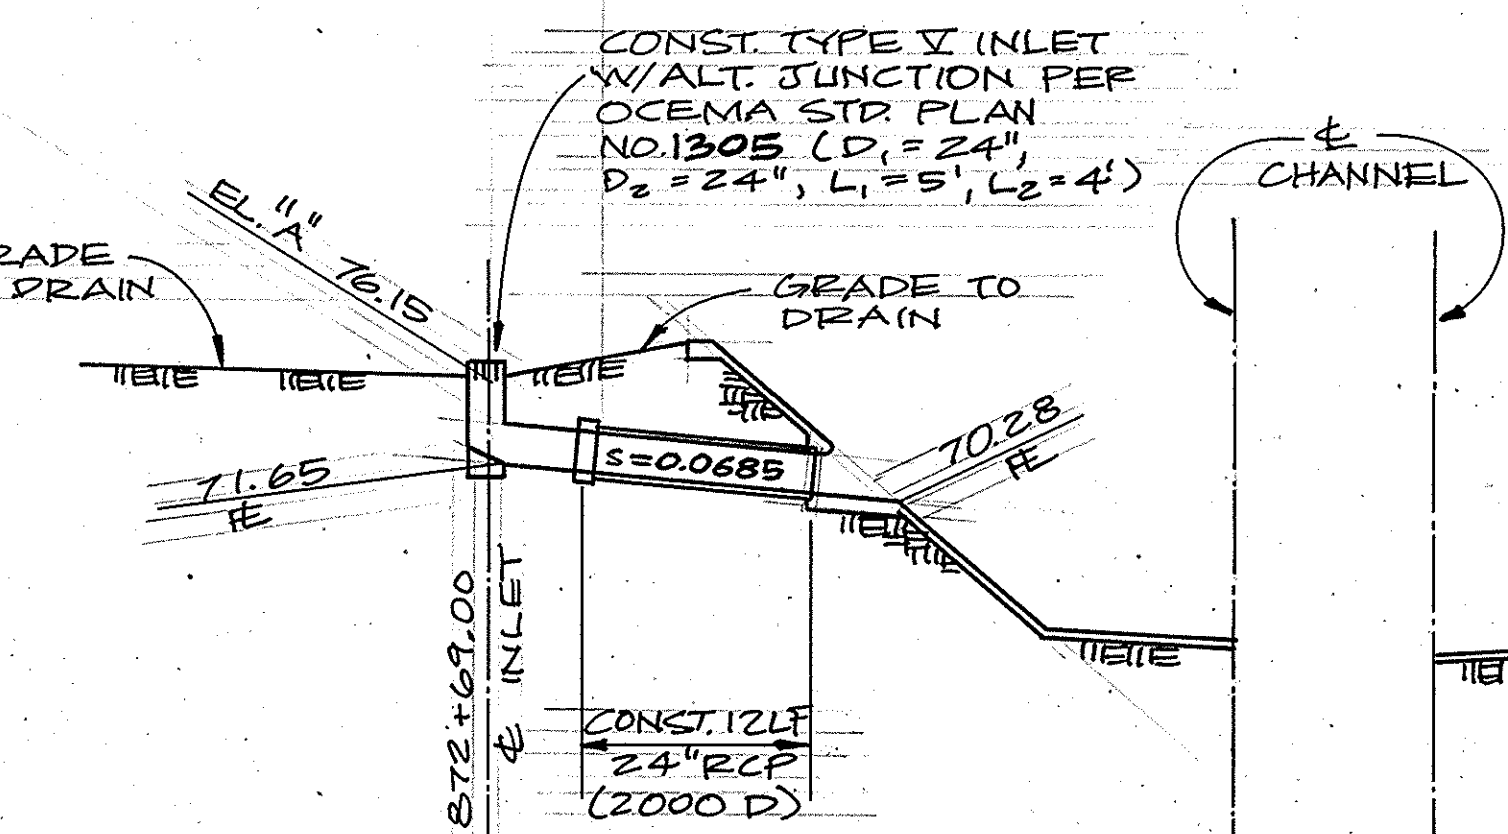


PROFILE INLET "A"

SCALE: 1" = 10'

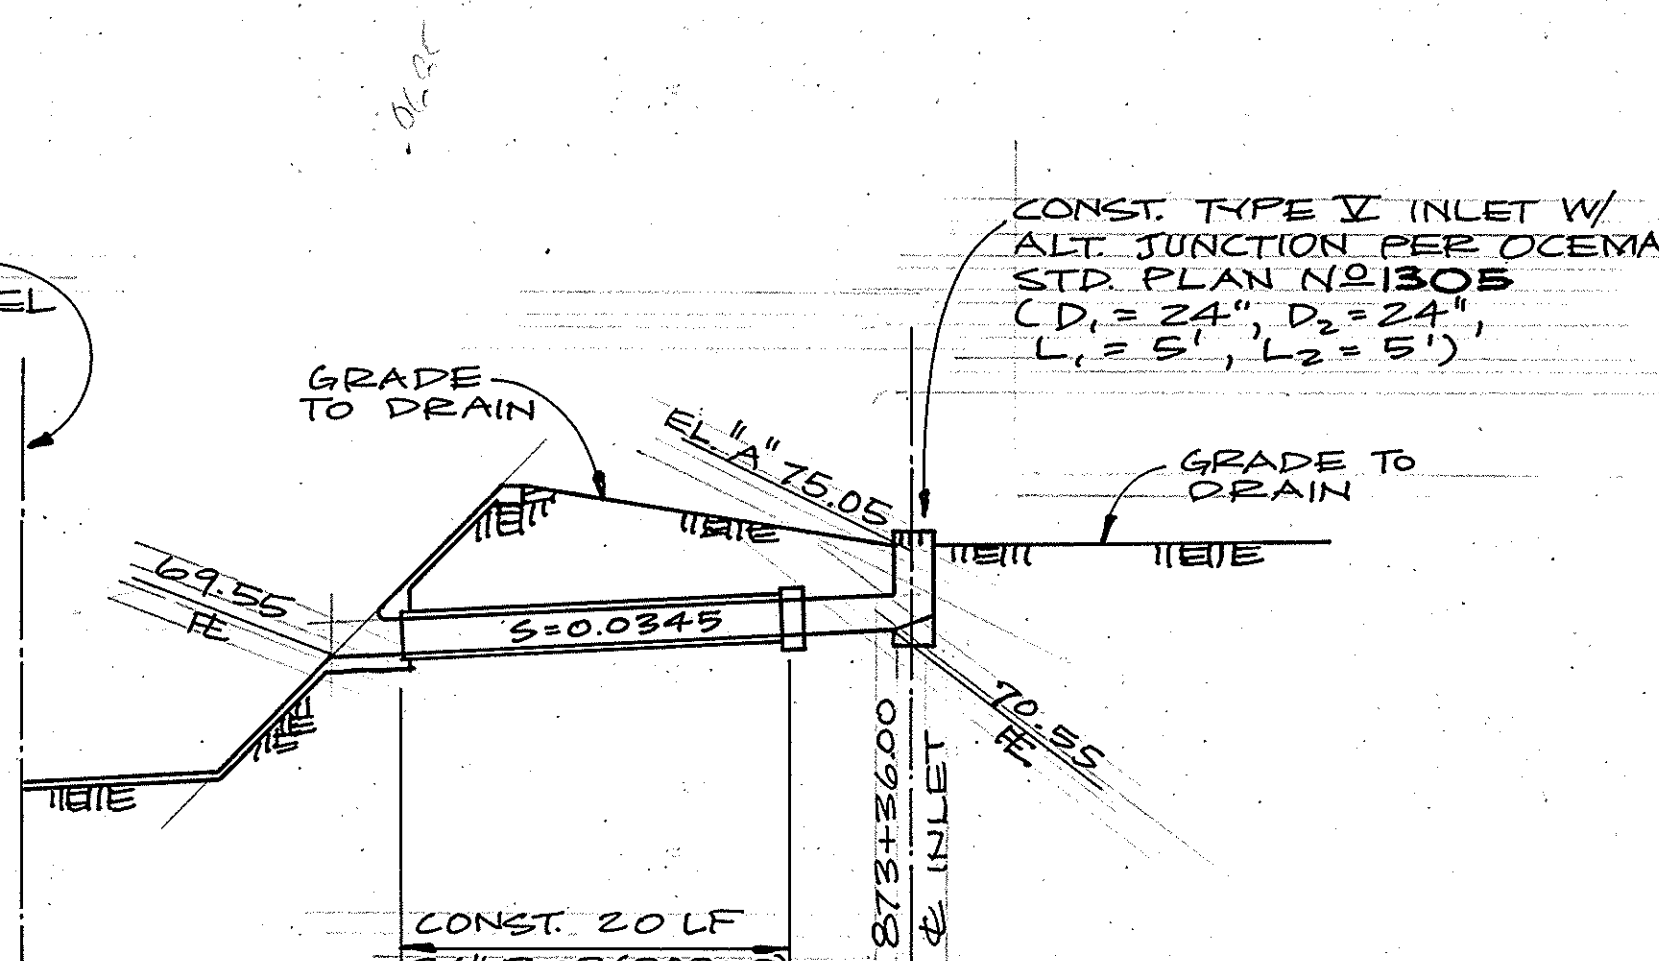


PROFILE INLET "B"

SCALE: 1" = 10'

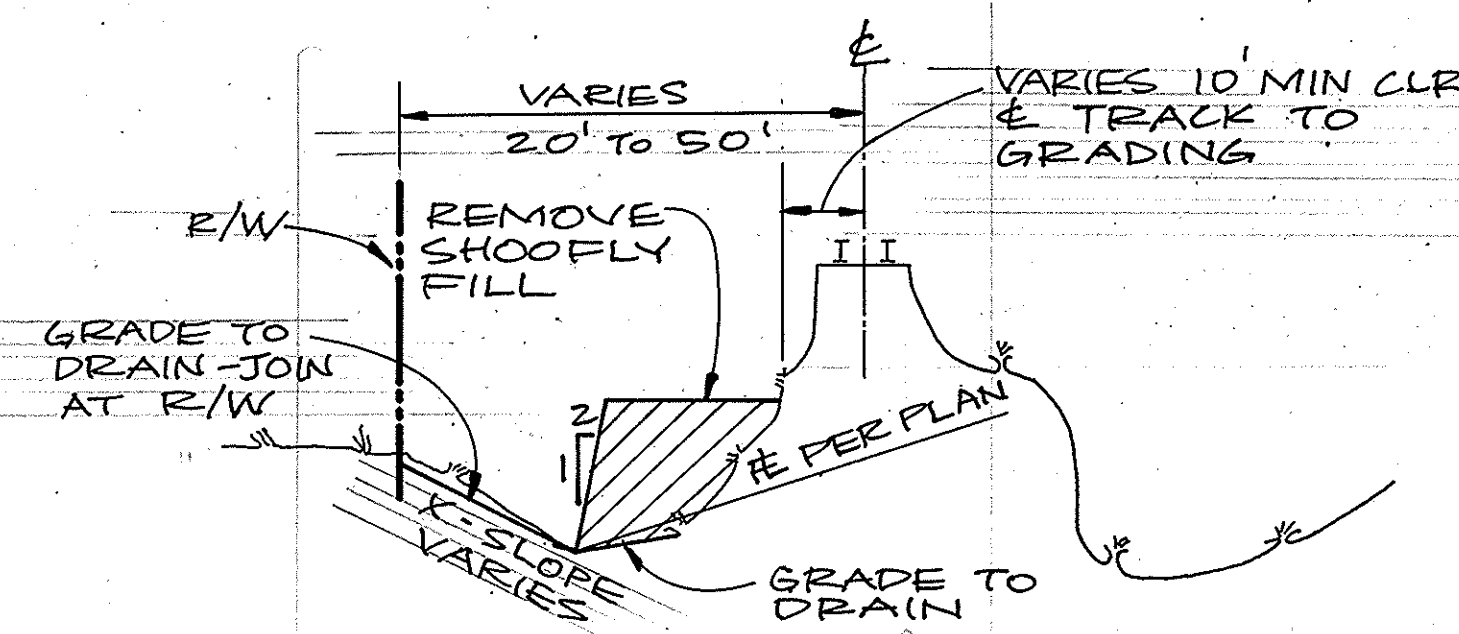


TYPICAL SECTION

NO SCALE

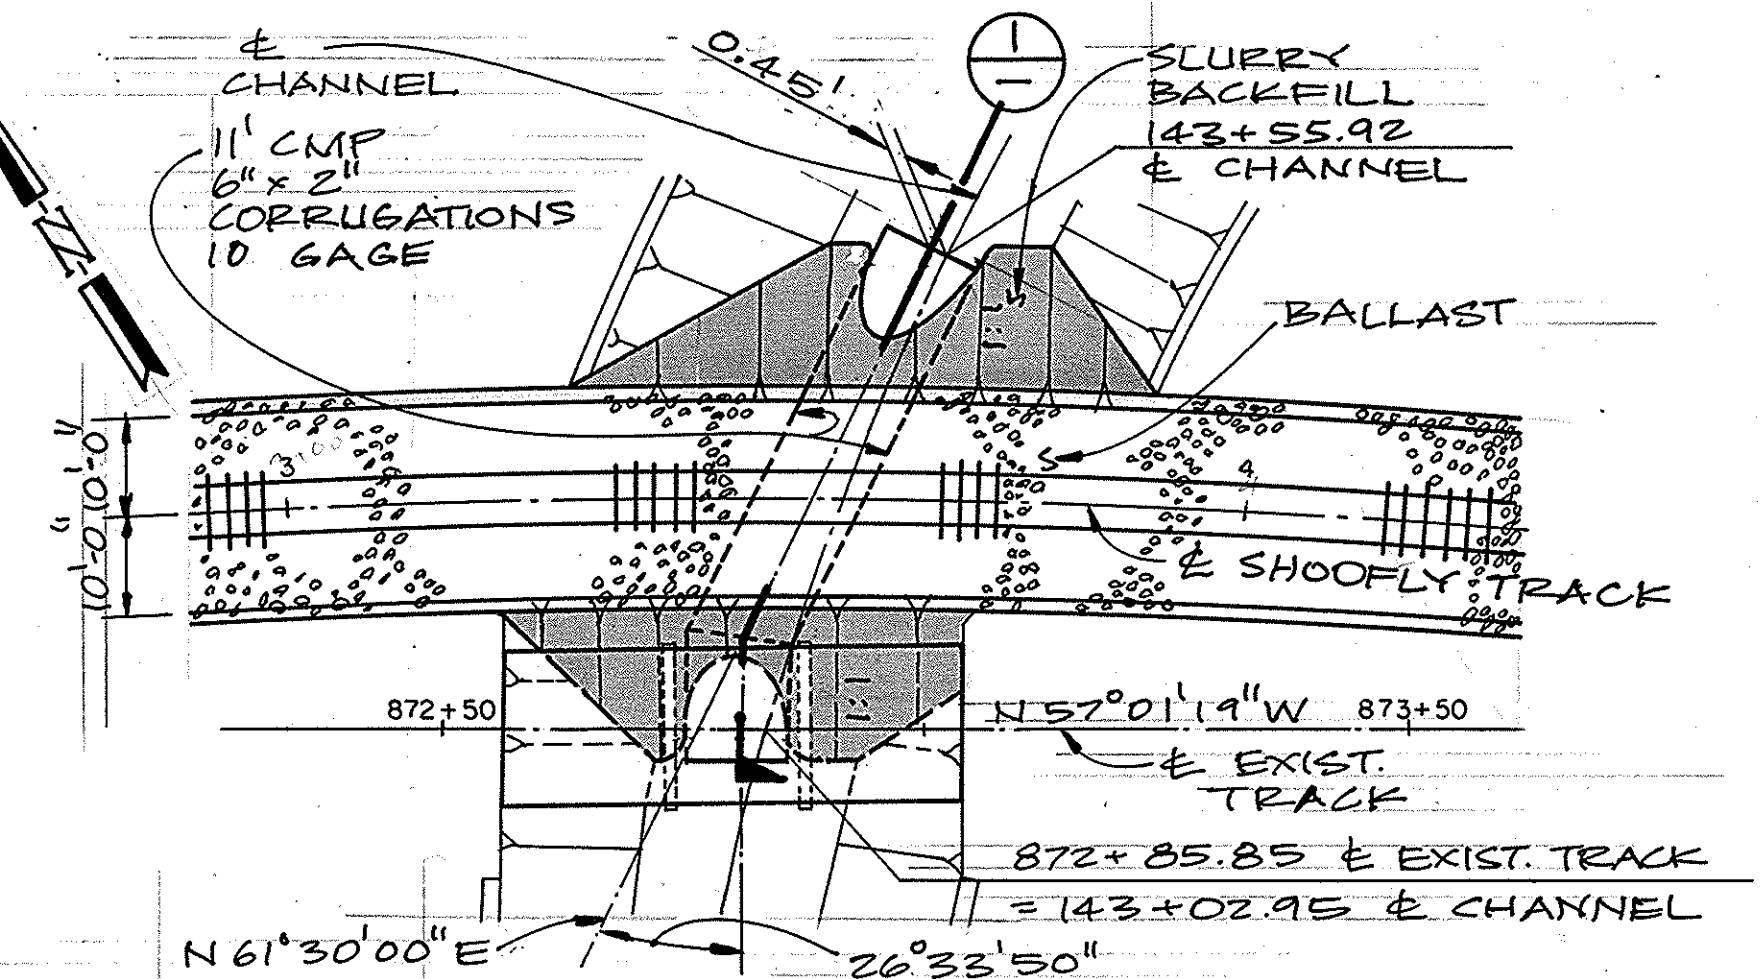


SHOOFLY CULVERT PLAN

SCALE: 1" = 20'

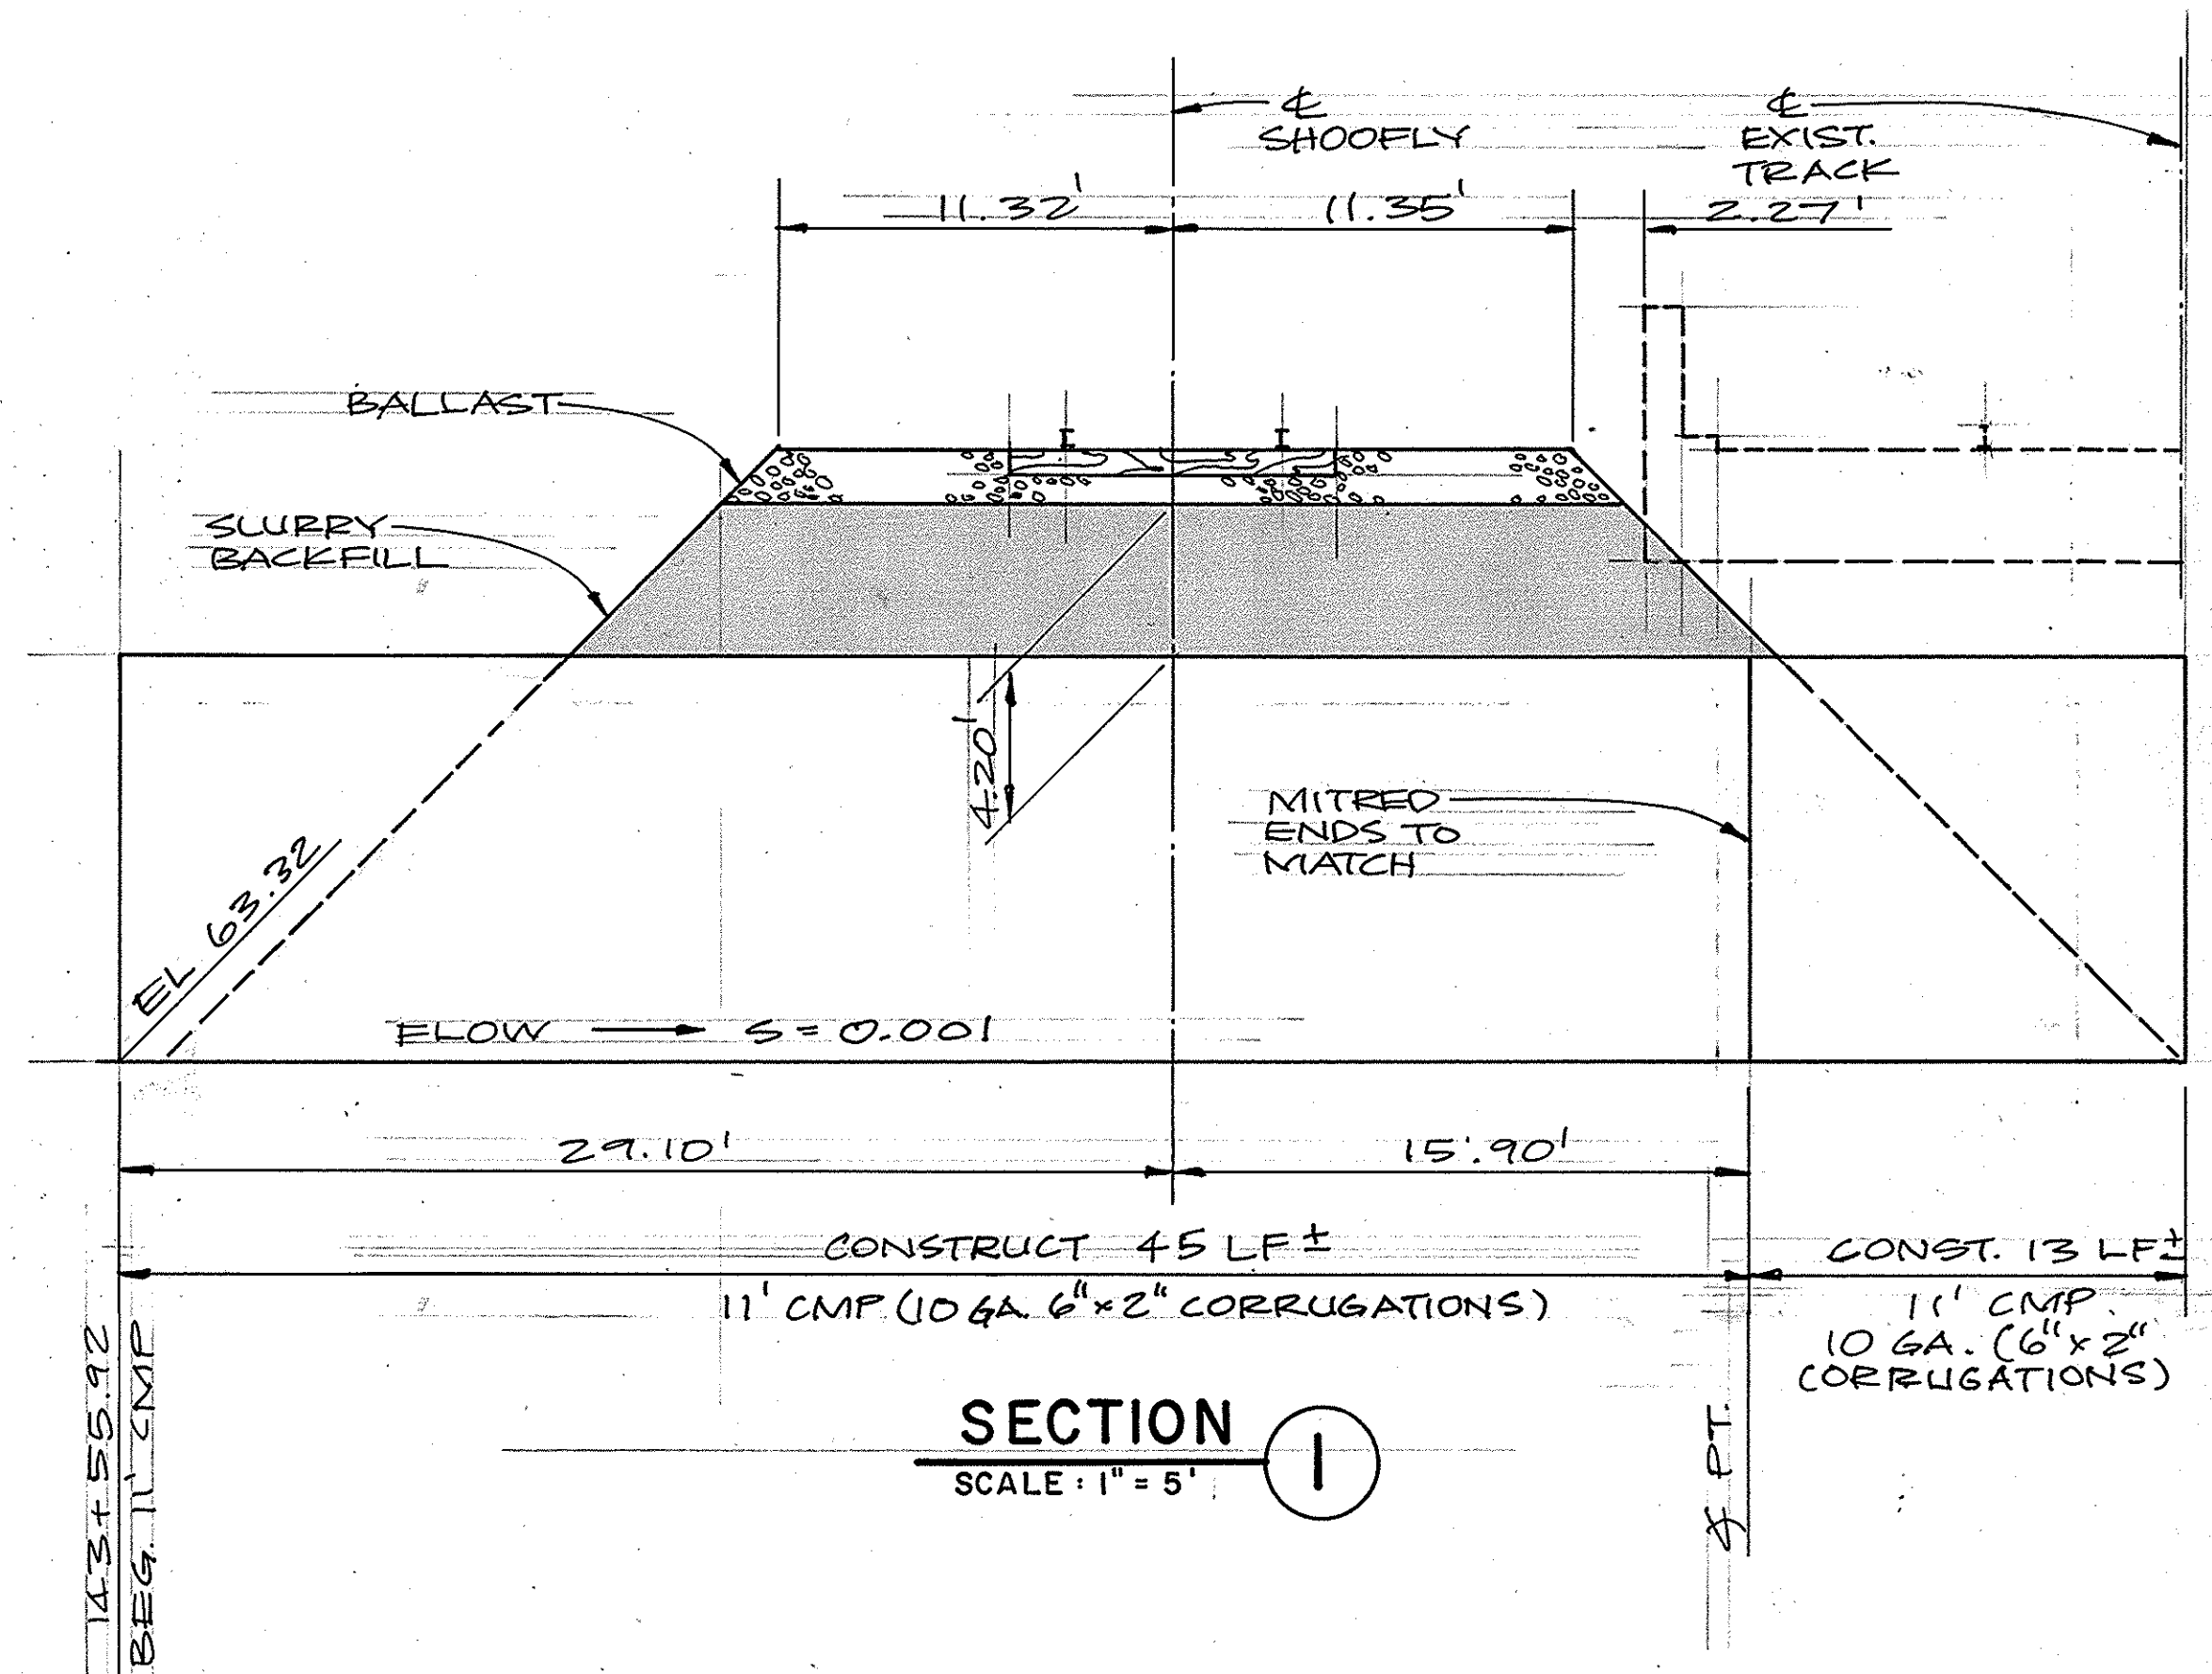

SECTION 1

SCALE: 1" = 5'

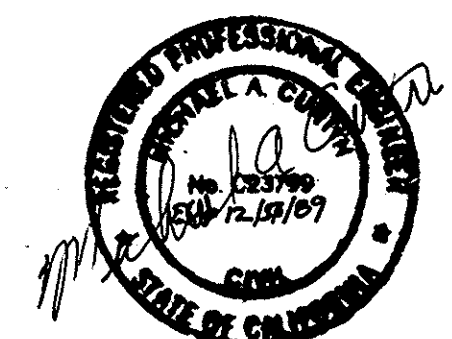

ORANGE COUNTY ENVIRONMENTAL MANAGEMENT AGENCY			
FULLERTON CREEK(A03) CHANNEL			
CHANNEL DRAINAGE DETAILS			
MARK	DATE	DESCRIPTION	PREPARED UNDER SUPERVISION OF
DESIGNED: M.A.C. SCALE: AS SHOWN			
DRAWN: N.O. CHECKED: M.A.C.			
DATE: 12/14/07			
DWG. NO. 9			
SHEET 9 OF 11			