
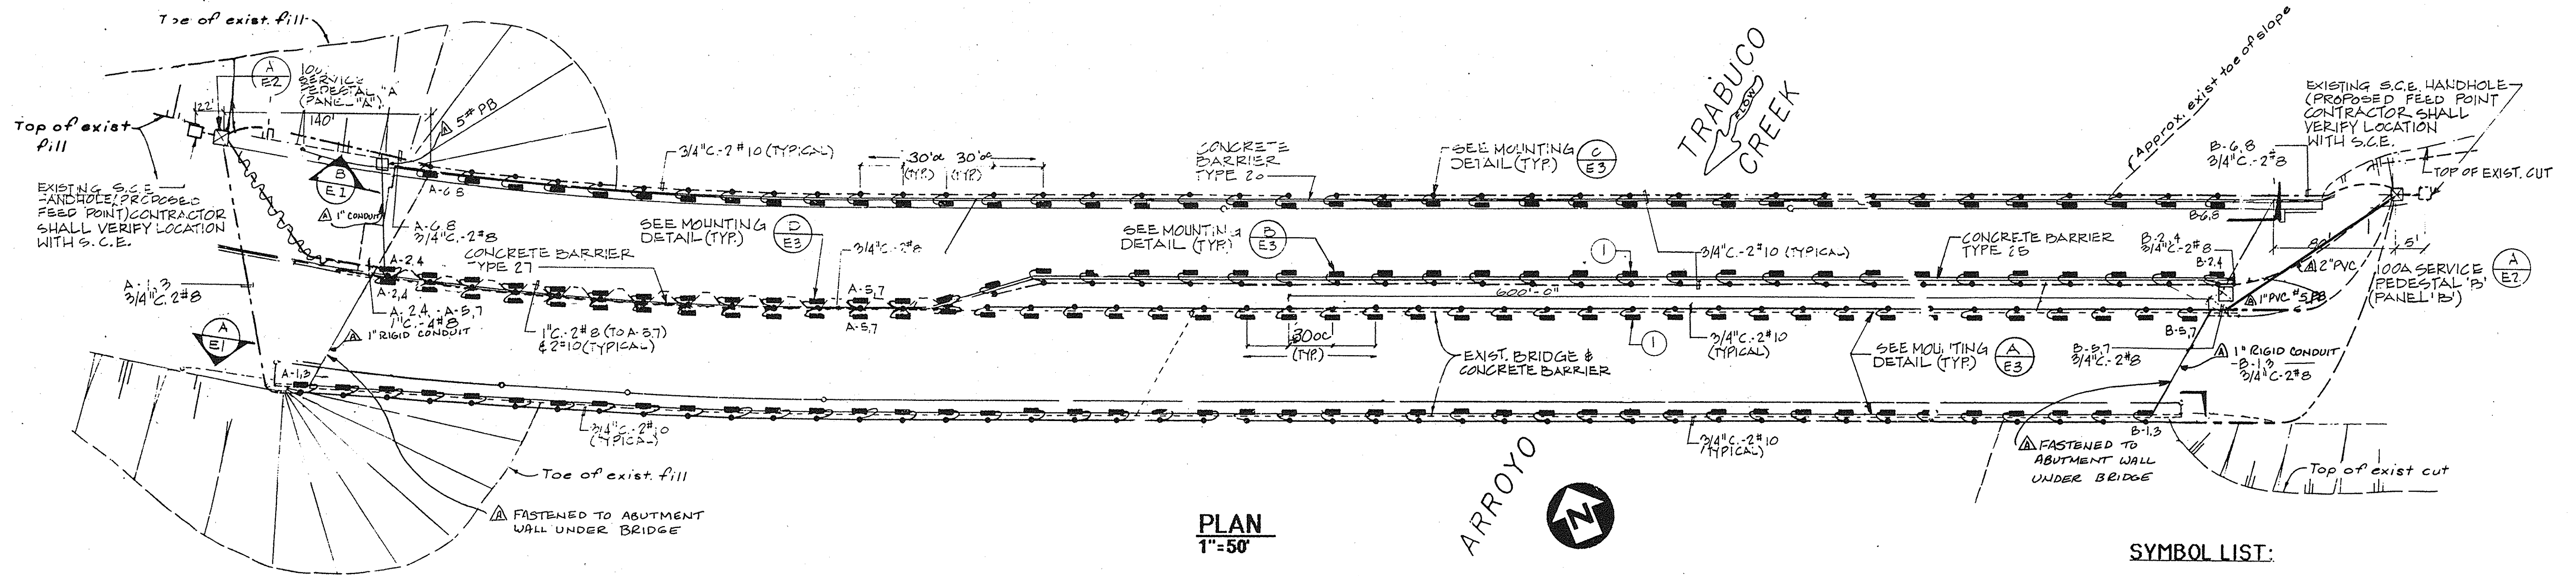


SOUTH ELEVATION
NTS

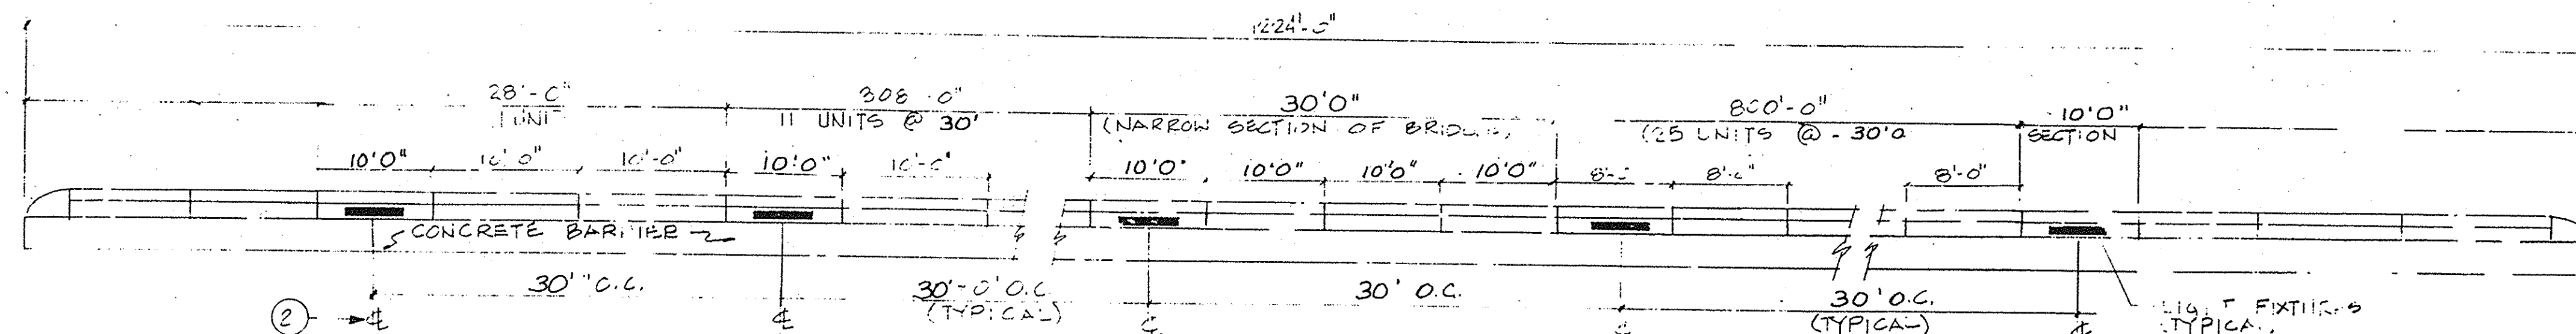

NORTH ELEVATION
NTS

SYMBOL LIST:

- SY 4" FLUORESCENT ROADWAY LIGHT STERNER CFL 1" OR EQUAL FURNISHED WITH VANDAL PROOF SCREWS AND LENS. NUMBERS INDICATE CIRCUITING.
- 110V REMOTE BALLAST WEATHER PROOF ENCLOSURE. ENCLOSURE SHALL BE LISTED FOR THROUGH WIRING.
- 1/2" LIQUID TIGHT FLEX.
- CONDUIT RUN EXPOSED
- CONDUIT RUN UNDERGROUND
- NTS NOT TO SCALE.
- O.C. ON CENTER
- S.C.E. SOUTHERN CALIFORNIA EDISON
- C CENTER LINE

NOTES:

- 1 MATCH SPACING WITH OUTER LIGHT FIXTURE. FIXTURES SHALL BE LOCATED DIRECTLY OPPOSITE TO EACH OTHER. (TYPICAL).
- 2 LIGHT FIXTURES SHALL BE CENTERED BETWEEN HAND RAIL POSTS. LOCATION OF EACH LIGHT FIXTURE MUST BE COORDINATED WITH HAND RAIL POSTS.

INDEX TO STANDARD PLANS

THE FOLLOWING STATE OF CALIFORNIA DEPARTMENT OF TRANSPORTATION STANDARD PLANS ARE A PART OF THESE CONTRACT DRAWINGS ES-7A AND ES-8

SPARVAN INCORPORATED
ELECTRICAL & CONTROL SYSTEM ENGINEERS
4140 NORSE WAY
LONG BEACH, CALIF. 90803
PHONE (213) 425-1233

DESIGNED BY
DPL
DRAWN BY
C.W.Y.
CHECKED BY
FIELD BOOK

**SANTA MARGARITA PARKWAY BRIDGE
OVER ARROYO TRABUCO - WIDENING**

BRIDGE LIGHTING PLAN

SHEET
46
OF
57
JOB NO.

JUNE 28, 1989

AS BUILT 3.93 SLH

