

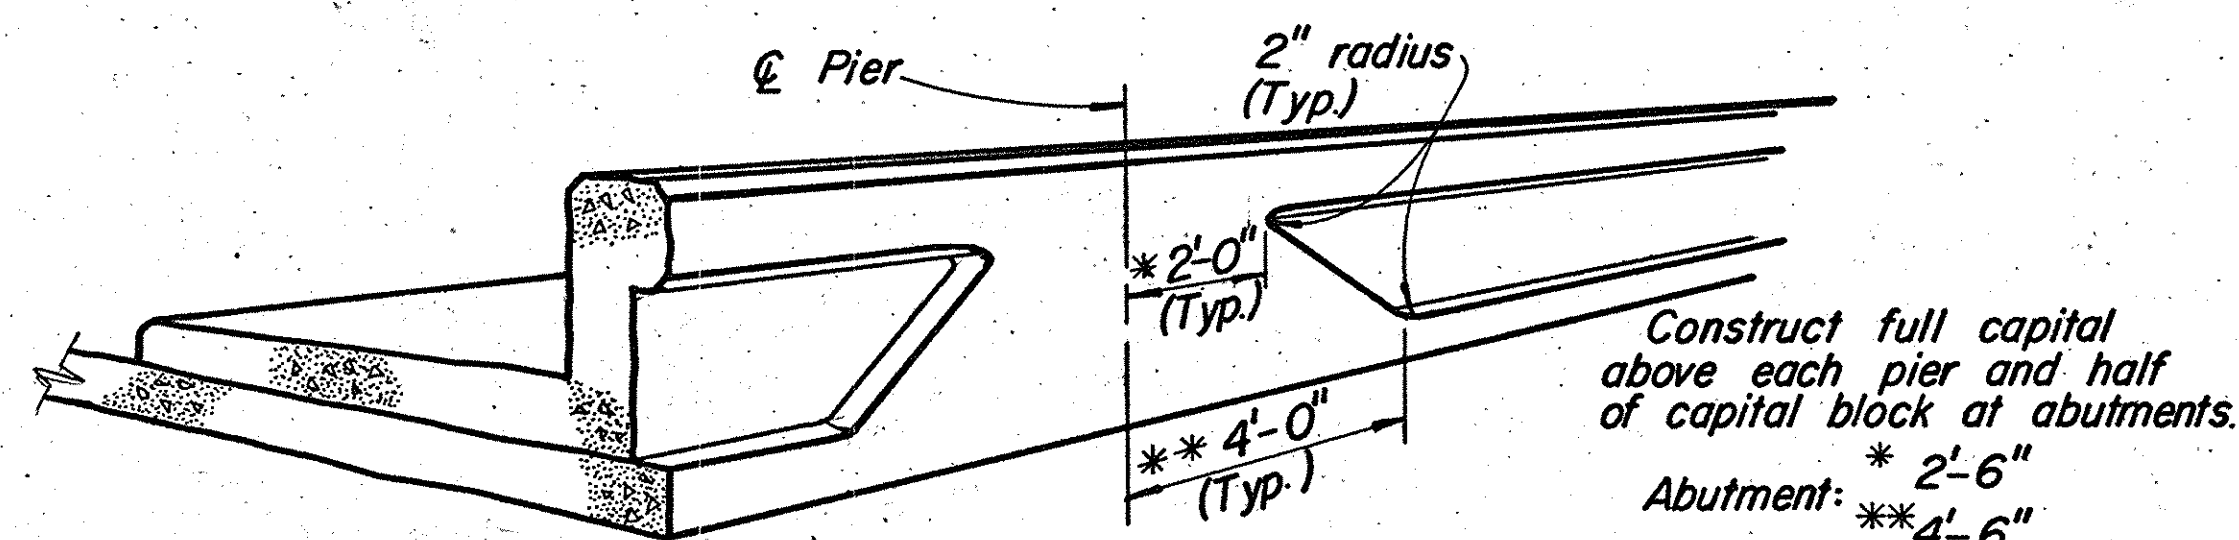
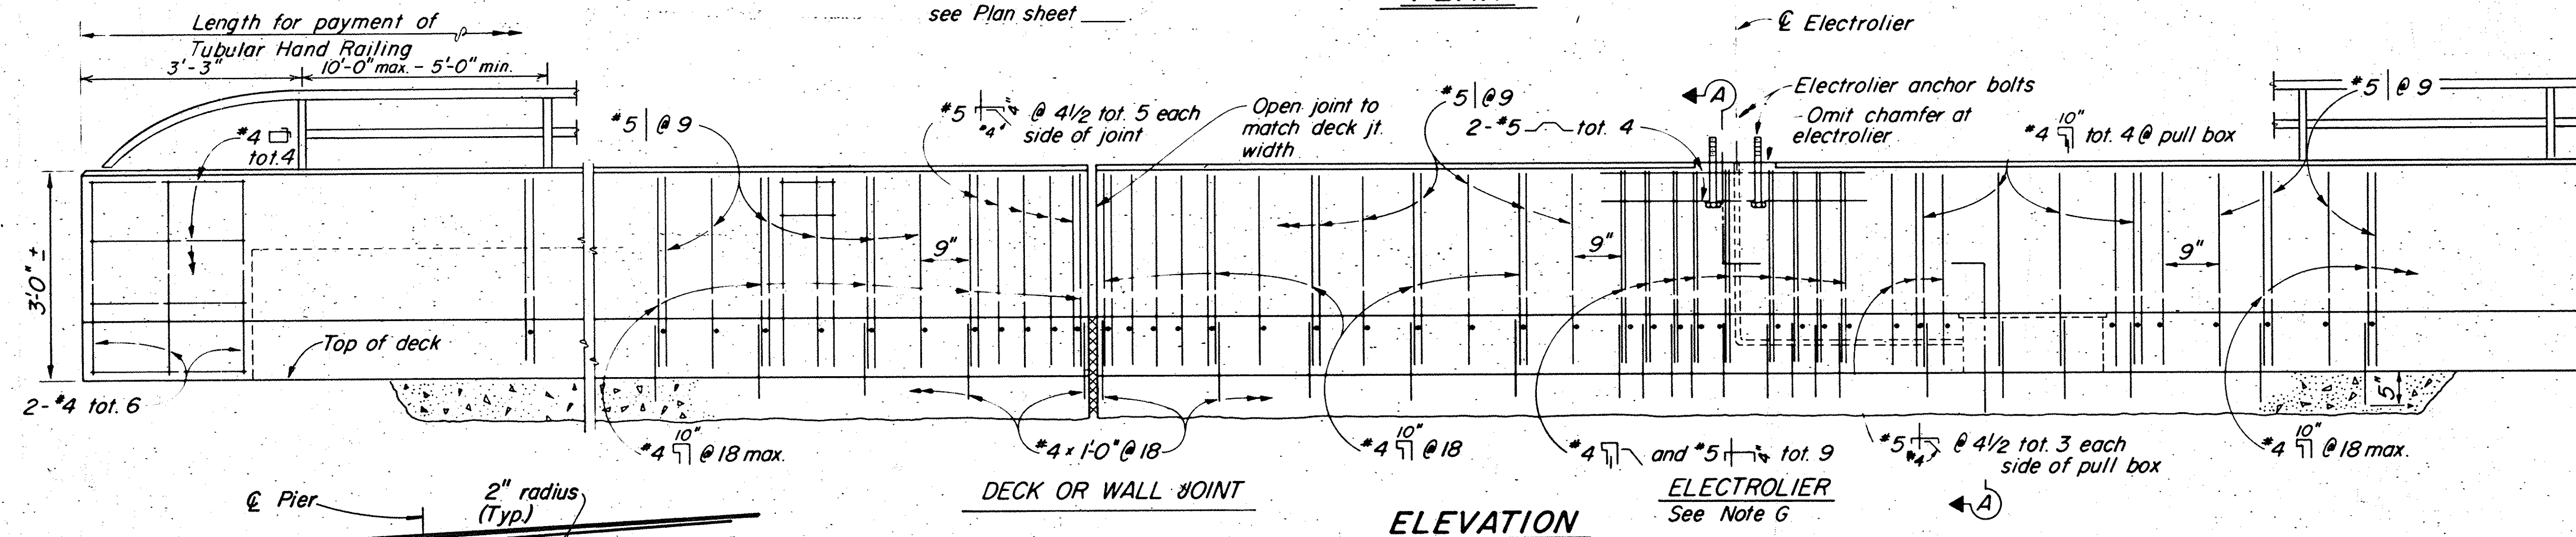


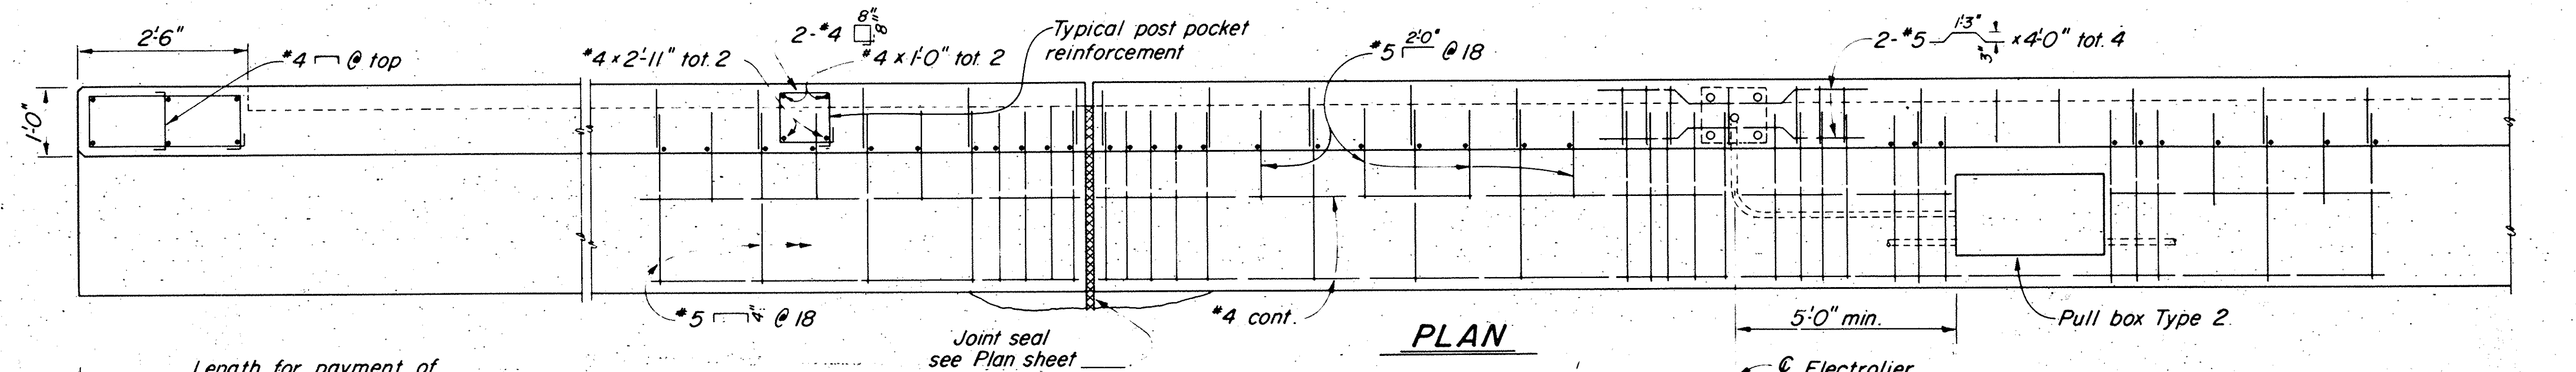


PARAPET CAPITAL

NO SCALE

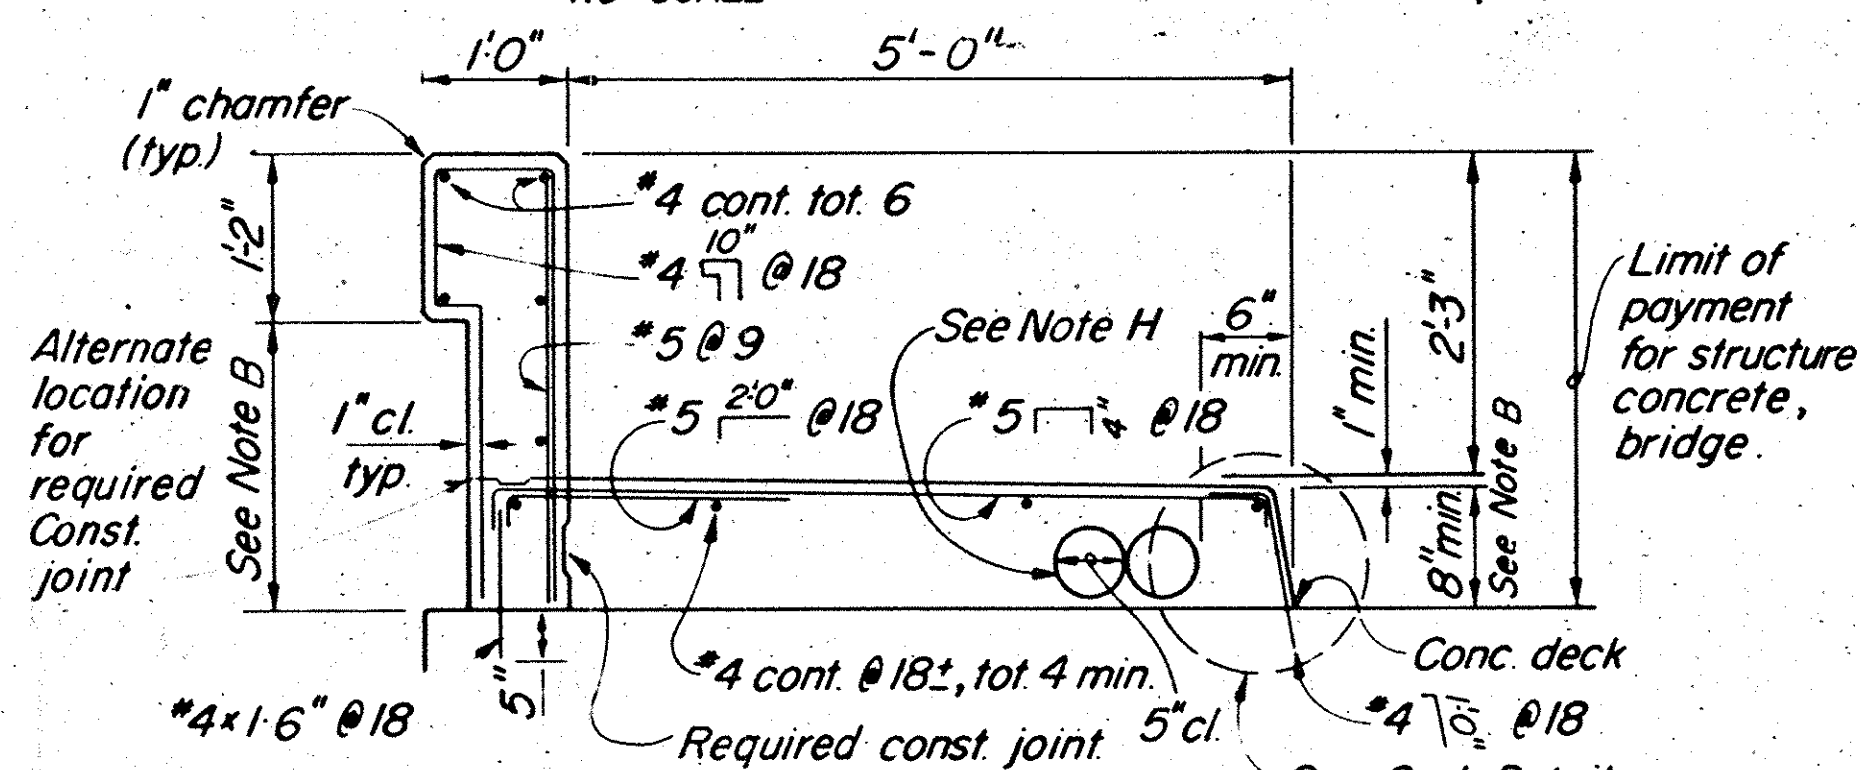


TYPICAL SECTION


Concrete: 5.84 cu. ft. per lineal foot
Reinforcing: 21.8 lbs. per lineal foot
For 5'-0" sidewalk width and 1 1/2% deck cross slope.

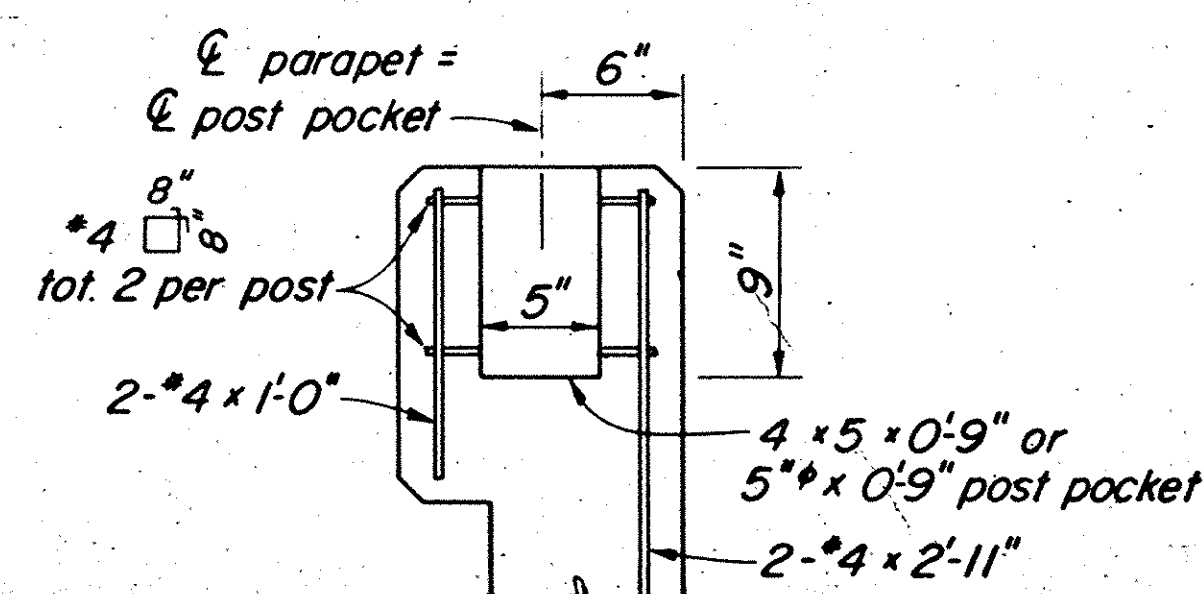

POST POCKET DETAIL

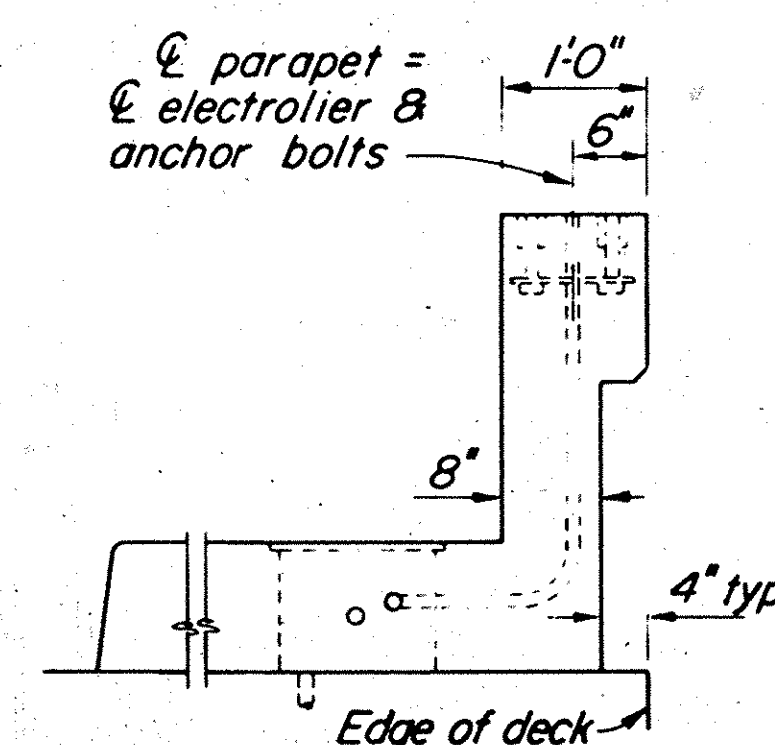


SECTION A-A

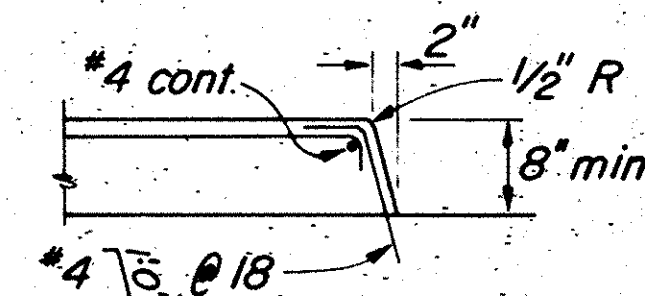

CURB DETAIL

AS BUILT
WHILE THE INFORMATION SHOWN IS BELIEVED TO BE ACCURATE, THE ORANGE COUNTY ENVIRONMENTAL MANAGEMENT AGENCY WILL NOT BE RESPONSIBLE FOR OMISSIONS, ERRORS, OR INACCURACIES.

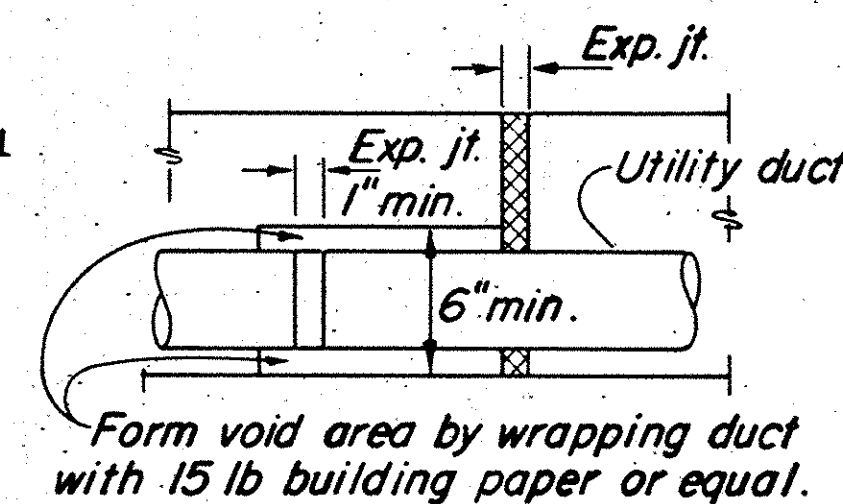

UTILITY DUCT EXPANSION JOINT

GENERAL NOTES

- For hand railing notes and details not shown, see "Tubular Hand Railing" sheet 15.
- Dimensions will vary with cross slope and with certain thicknesses of surfacing. See bridge plans.
- Walls are to be backfilled before railing is placed.
- Clearance to reinforcing steel in curb and railing to be 1" except as noted. Longitudinal reinforcement to stop at all expansion joints.
- See Project Plans for electrolier locations sheet 16.
- See Bridge Plans for limits of Tubular Hand Railing.
- For Electrical Details, see Plan sheets 16.
- A minimum of 4'-0" round openings are required for future or existing utilities. Openings are to be sealed at ends if not used. Duct forms are to be tied down.

1 1/2 0 2
3 inches on original drawing

ORANGE COUNTY ENVIRONMENTAL MANAGEMENT AGENCY		TALBERT - MACARTHUR BRIDGE ACROSS SANTA ANA RIVER	
TYPE 26 PARAPET		SHEET 14	
MARK	DATE	DESCRIPTION	PREPARED UNDER SUPERVISION OF
DESIGNED	SCALE	DATE	DWG. NO.
DRAWN	CHECKED	DATE	