



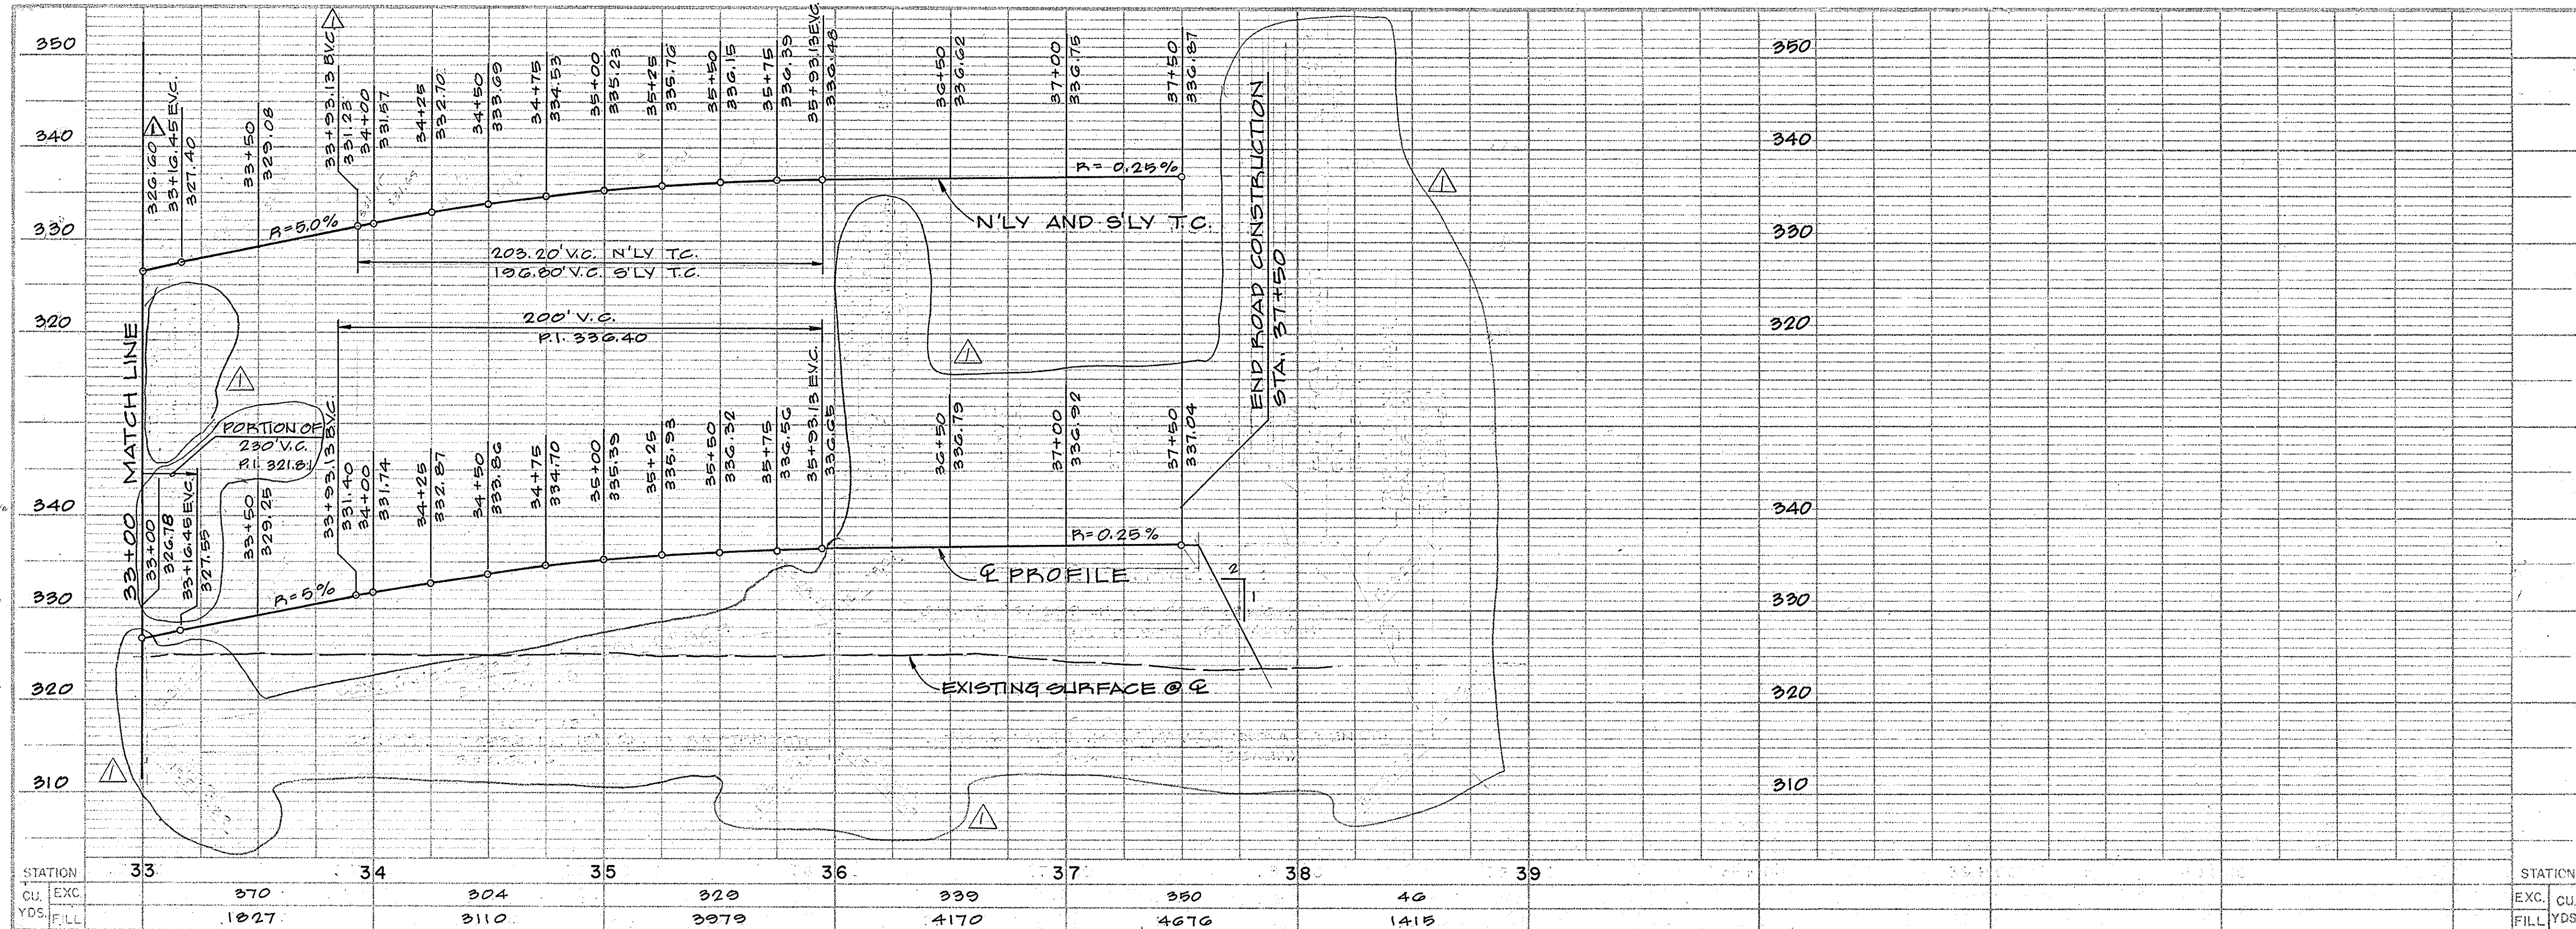

CONSTRUCTION NOTES

- 2 CONSTRUCT 4" P.C.C. SIDEWALK PER O.C.E.M.A. STANDARD PLAN 205.
- 3 CONSTRUCT TYPE D CURB & GUTTER PER O.C.E.M.A. STD. PLAN 201. APPLY PHENEMINE PRIOR TO PLACEMENT OF CURBS.
- 4 CONSTRUCT 16" A.C.P. WATER MAIN WITH MIN. 30" OF COVER OVER TOP OF PIPE.
- 6 CONSTRUCT 15" V.C.P. SEWER.
- 8 CONSTRUCT 24" R.C.P. STORM DRAIN.
- 9 CONSTRUCT STORM DRAIN M.H. USING JUNCTION STRUCTURE TYPE 1 WITHOUT SIDE INLET PER O.C.E.M.A. STANDARD PLAN 310.
- 16 CONSTRUCT 48" SEWER M.H. WITH ECCENTRIC GONE PER O.C.E.M.A. DWG. S-33-1.
- 19 CONSTRUCT 1' DEEP V-DITCH PER TYPICAL SECTIONS, SHT. C-1.
- 20 PLUS OR CAP THE END OF PIPE WITH V.C. OR NEOPRENE PLUG.
- 21 PLUG OR CAP THE END OF PIPE WITH PLYWOOD BULKHEAD.
- 25 CONSTRUCT 3" AC WITH SEAL COAT OVER 8" AB PER TYPICAL SECTIONS, SHT. C-1. (THESE THICKNESSES ARE ESTIMATED AND ARE SUBJECT TO CHANGE PENDING RESULTS OF SOILS TESTS OF IN PLACE ROADWAY EMBANKMENTS).
- 26 ROADWAY EMBANKMENT SHALL BE CONSTRUCTED TO FINISH SUBGRADE OR 3" S. ABOVE THE TOP OF THE PIPE, WHICHEVER IS LOWER, PRIOR TO EXCAVATION OF TRENCH AND PLACEMENT OF PIPE.

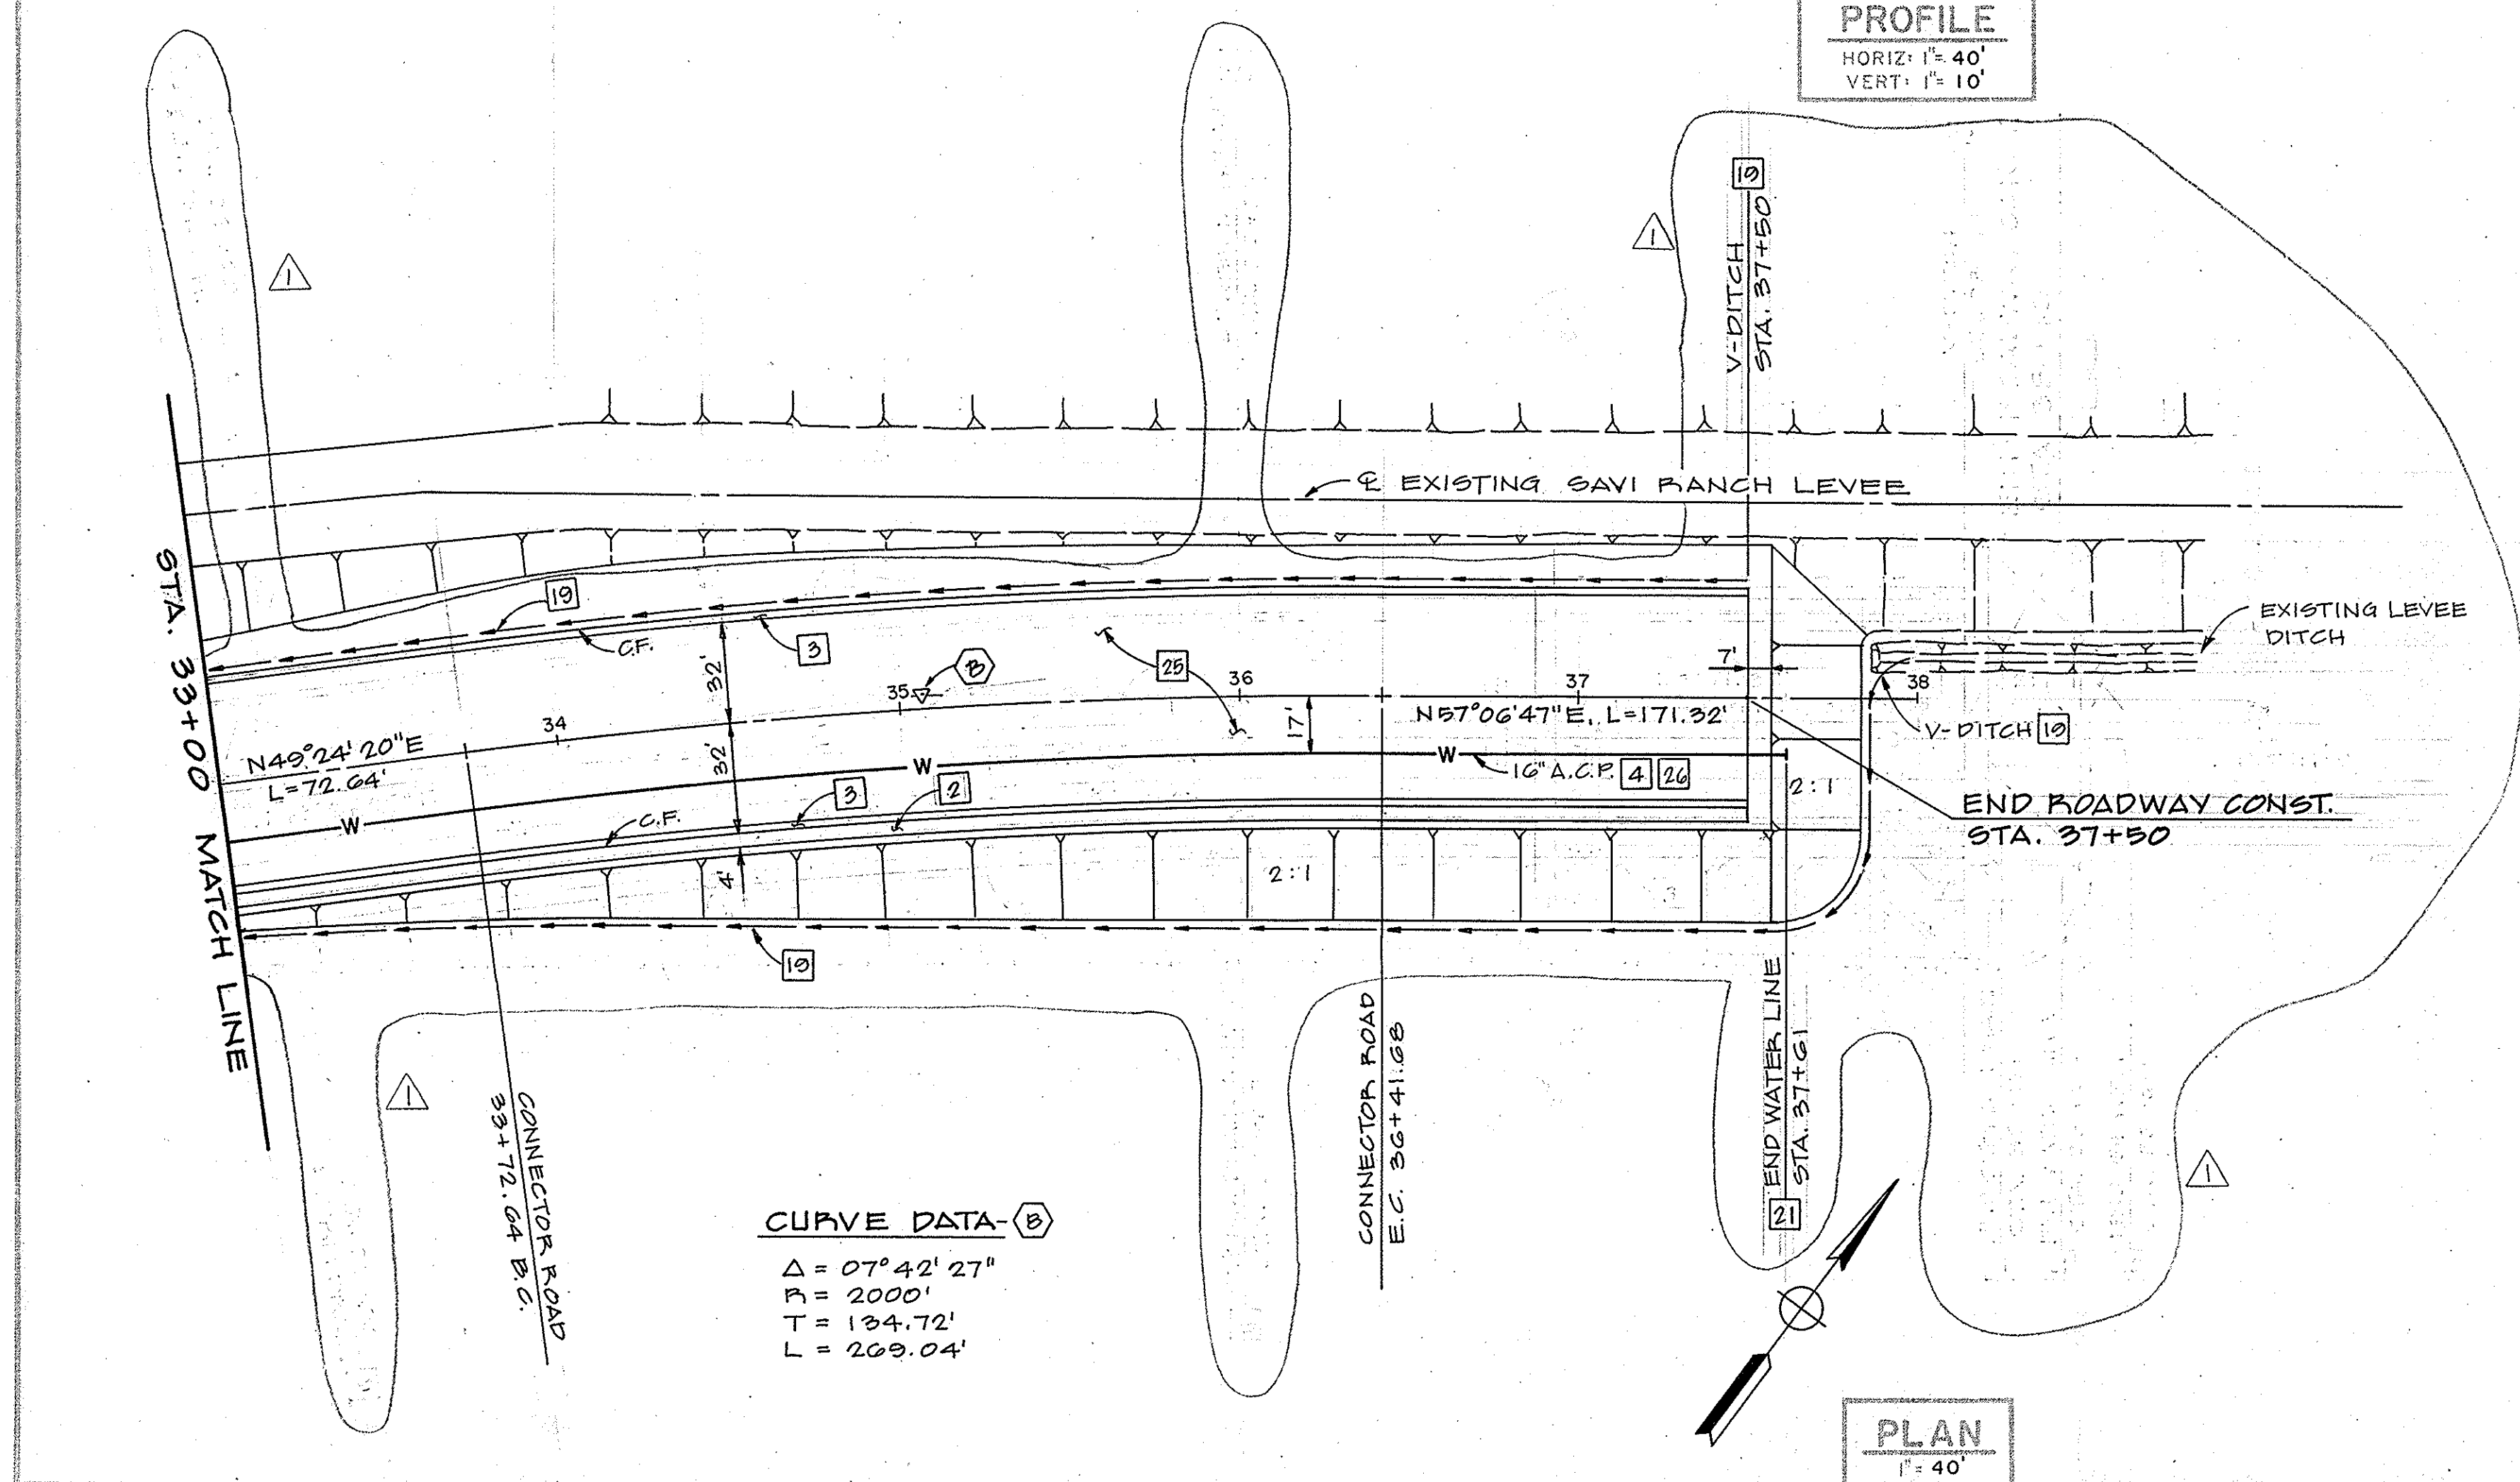

1 1/2 0 1 2
3 inches on original drawing

REVISIONS		ORANGE COUNTY ENVIRONMENTAL MANAGEMENT AGENCY	
WEIR CANYON ROAD CONNECTOR ROAD PLAN AND PROFILE STA. 33+00 TO STA. 38+13		SHEET C-3	
MARK	DATE	DESCRIPTION	PREPARED UNDER SUPERVISION OF
DESIGNED	M.H.M.	SCALE	DATE
DRAWN	B.Y.L.	CHECKED	J.W.P.