


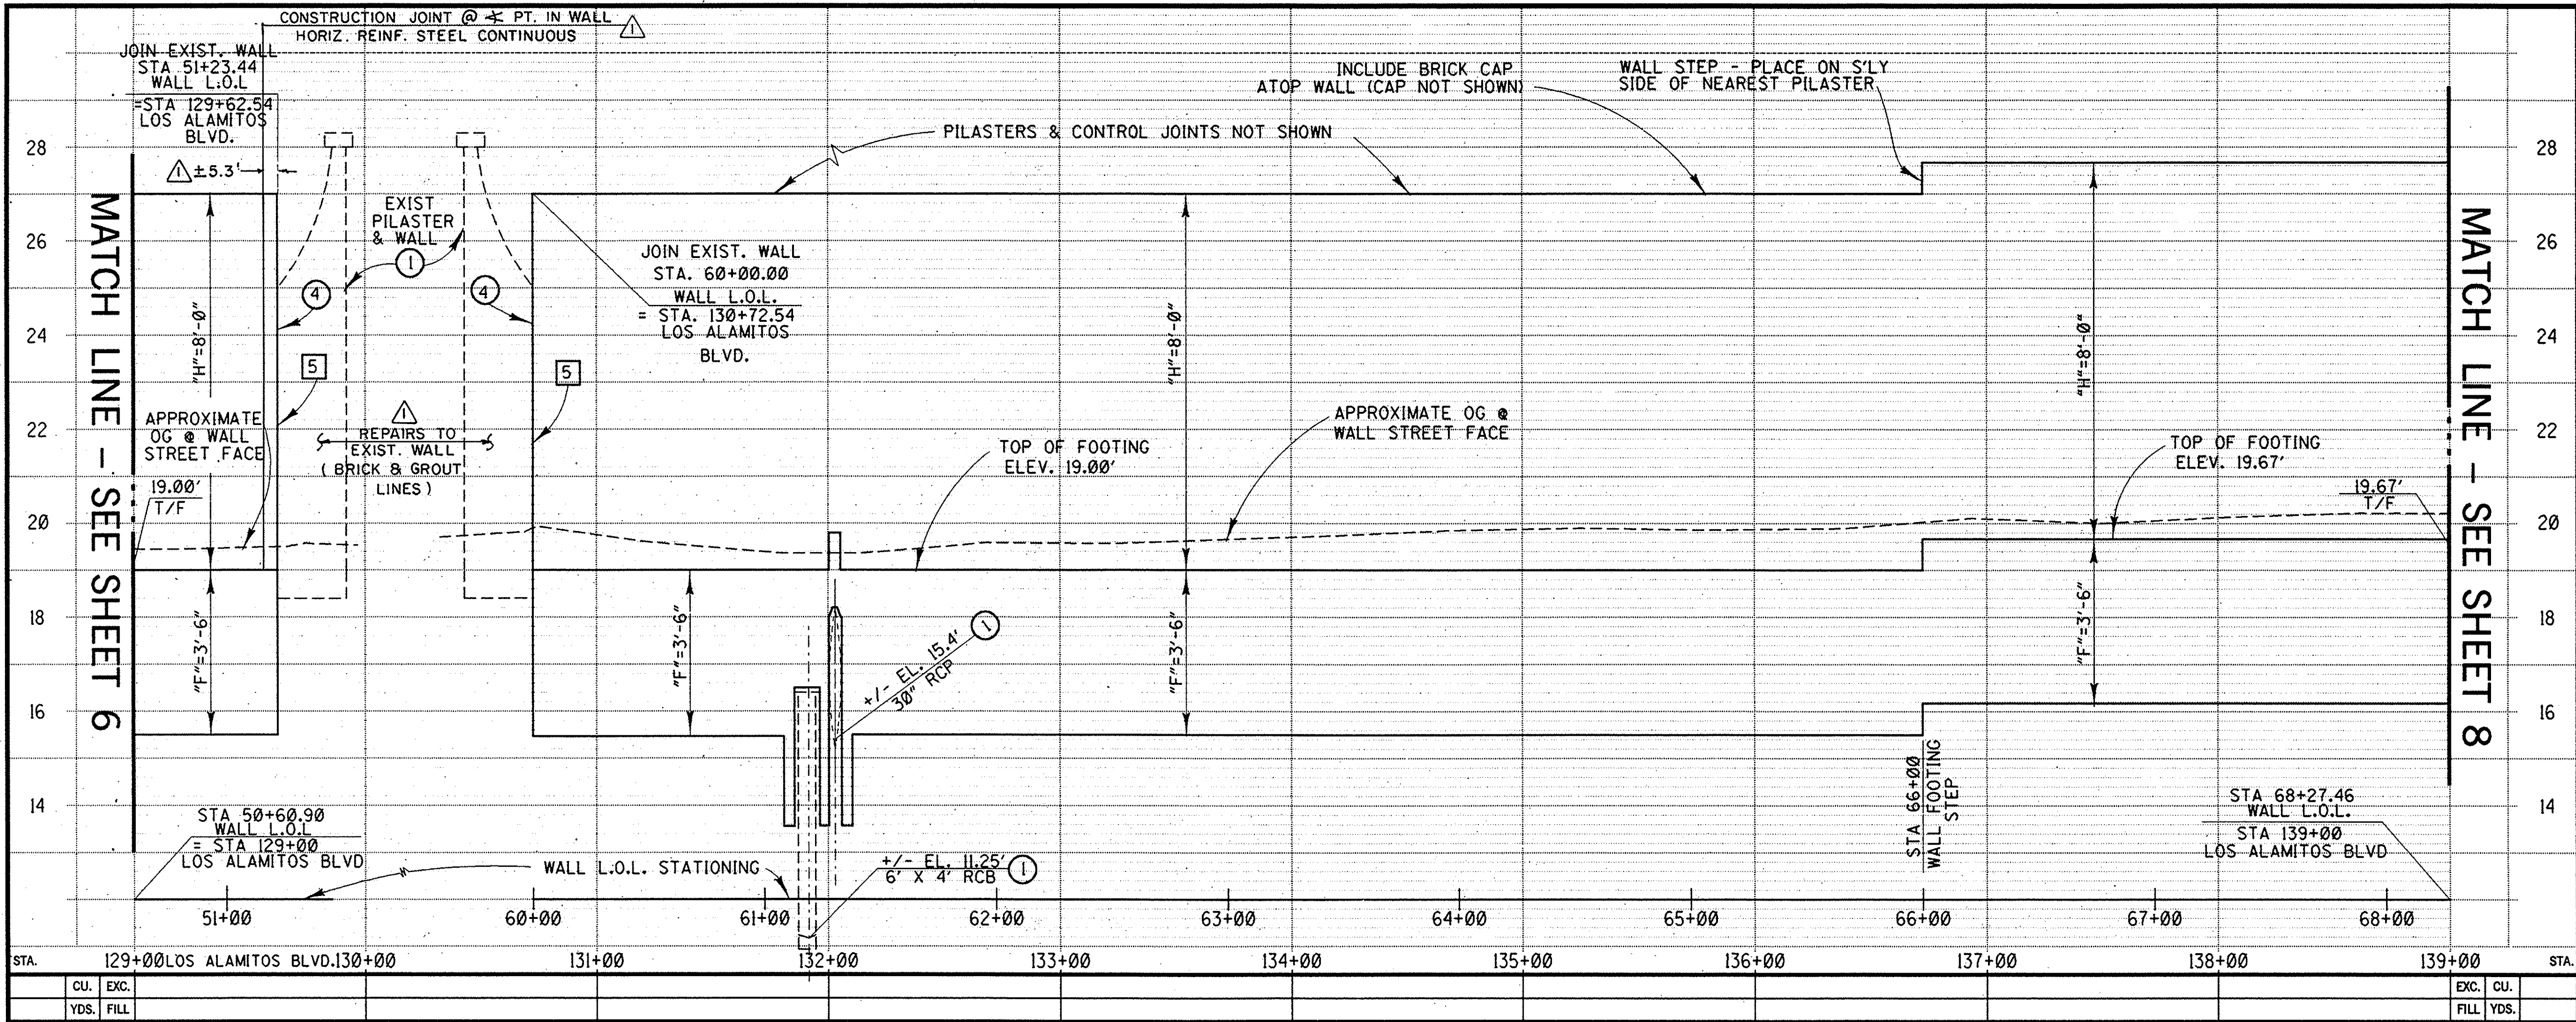

CONSTRUCTION NOTES

1. CONSTRUCT CONCRETE MASONRY BLOCK/RED BRICK VENEER WALL PER MODIFIED APWA STD. PLAN 601-0, TYPE 3, AND PLANS, DETAILS AND SPECIAL PROVISIONS.
2. INSTALL TEMPORARY SECURITY FENCE PER PLAN, DETAILS AND SPECIAL PROVISIONS.
3. CONSTRUCT PCC SIDEWALK, WIDTH AND LIMITS PER PLAN & PER STANDARD PLAN 1205 AND DETAILS SHEET 9.
5. DRILL AND BOND DOWELS PER DETAIL AND SPECIAL PROVISIONS.

NOTE:

CONTRACTOR SHALL LIMIT HIS WORK ACTIVITIES TO THE GREATEST EXTENT POSSIBLE WITHIN THE RIGHT OF ENTRY AREA DELINEATED BY THE TEMPORARY SECURITY FENCE. CONTRACTOR IS TO REPLACE OR REPAIR ANY RESIDENT IMPROVEMENTS DAMAGED BY HIS OPERATIONS, AT HIS SOLE COST, TO THE SATISFACTION OF THE ENGINEER.


UTILITIES

- A SOUTHERN CALIFORNIA EDISON
- B TIME WARNER COMMUNICATIONS.
- C SOUTHERN CALIFORNIA WATER COMPANY
- D SOUTHERN CALIFORNIA GAS
- E ORANGE COUNTY SANITATION DISTRICT
- F CITY OF LOS ALAMITOS
- H COMCAST CABLEVISION
- I GTE CALIFORNIA

LEGEND

- ① PROTECT IN PLACE
- ② REMOVE
- ④ SAWCUT/ JOIN
- ⑦ REMOVE INTERFERING PORTIONS
- ⑪ REMOVE AND SALVAGE

NOTE: NOT ALL STREET UTILITIES PLOTTED.

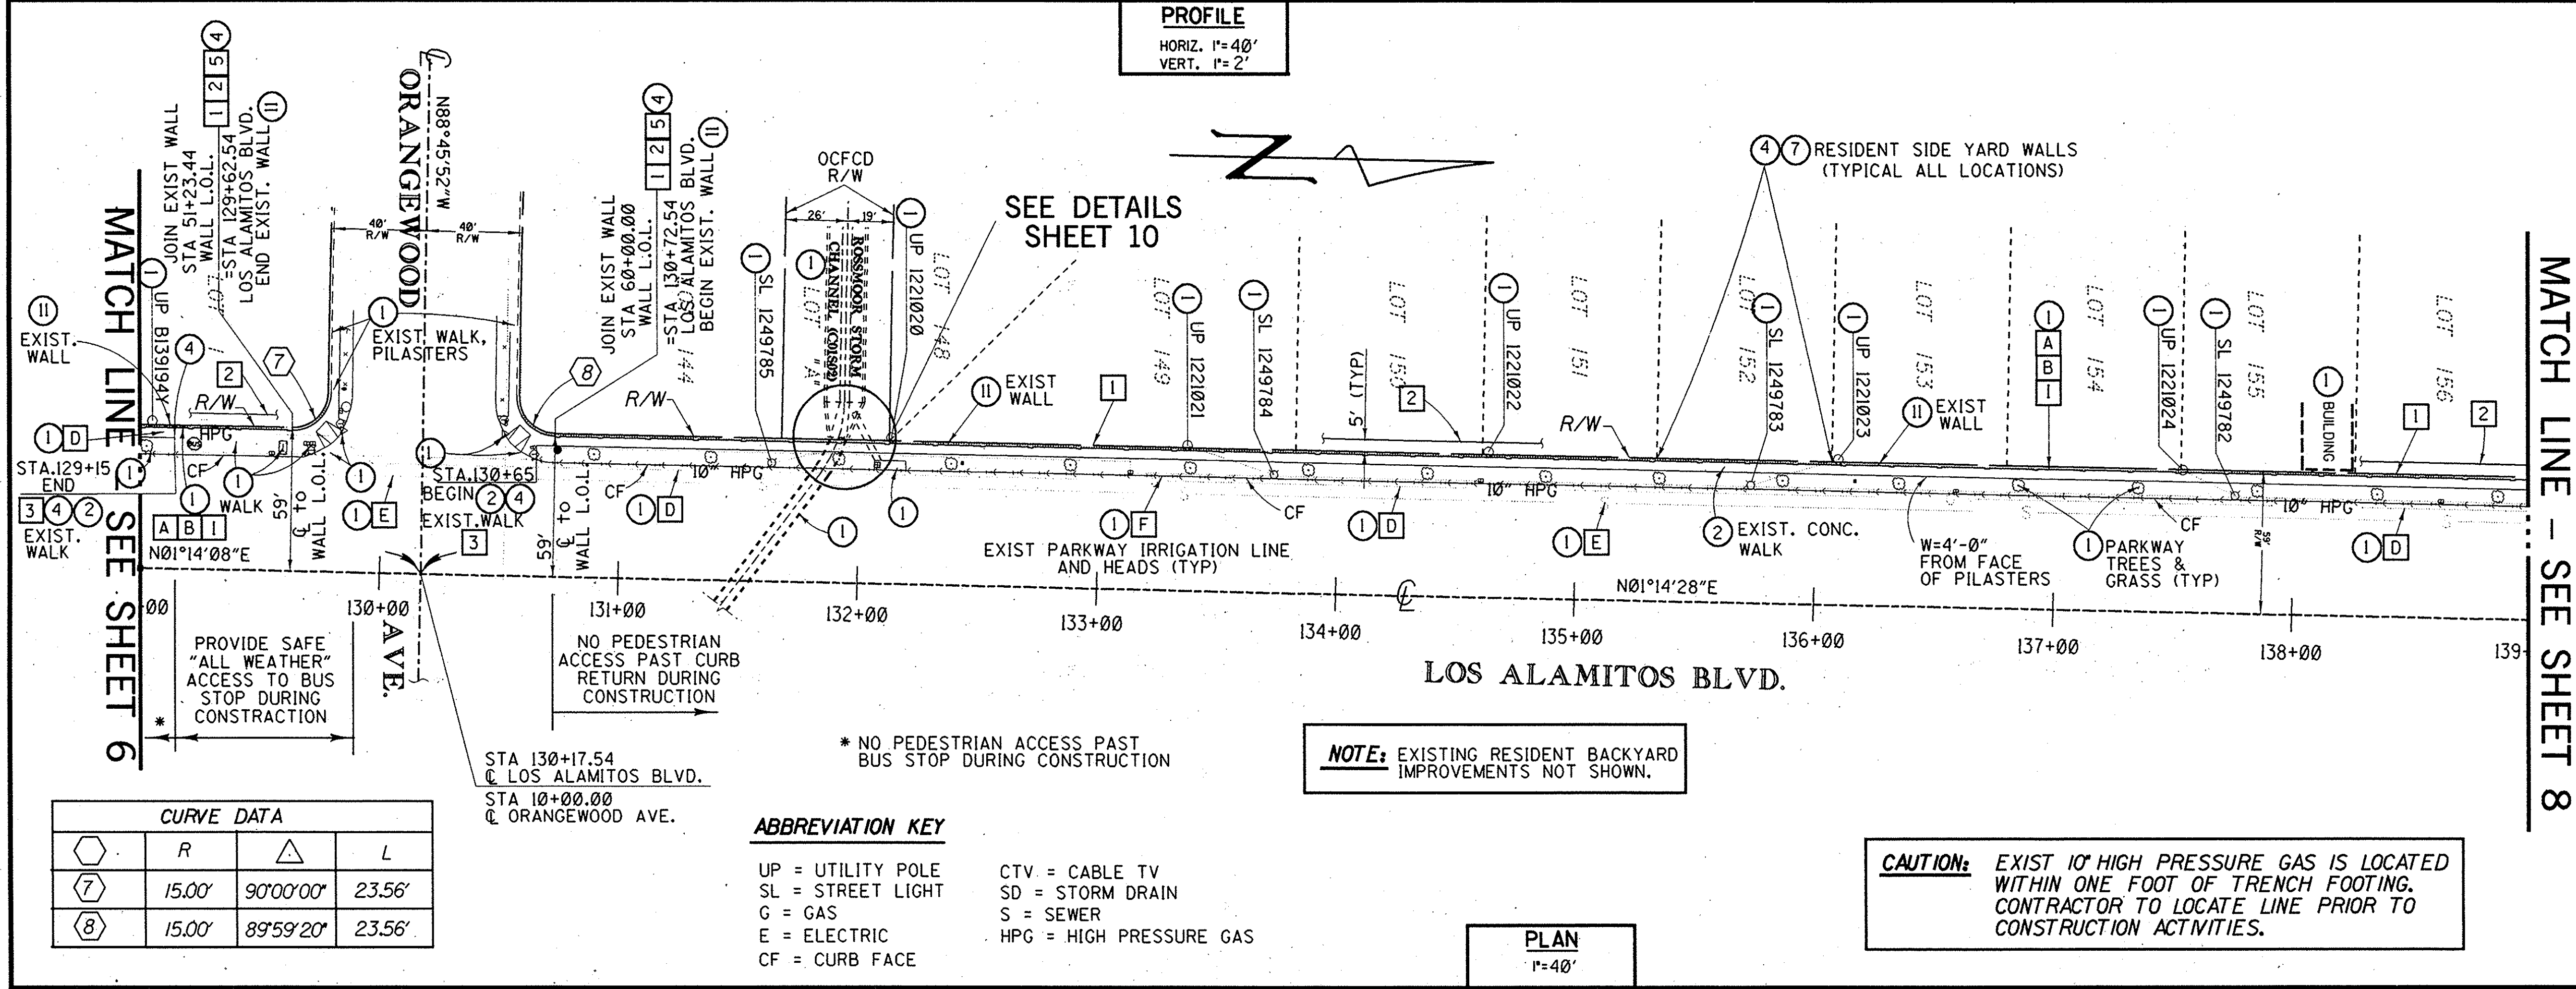

NOTE: EXISTING RESIDENT BACKYARD IMPROVEMENTS NOT SHOWN.

CAUTION: EXIST 10" HIGH PRESSURE GAS IS LOCATED WITHIN ONE FOOT OF TRENCH FOOTING. CONTRACTOR TO LOCATE LINE PRIOR TO CONSTRUCTION ACTIVITIES.

PLAN

1"=40'

ABBREVIATION KEY

- UP = UTILITY POLE
- SL = STREET LIGHT
- G = GAS
- E = ELECTRIC
- CF = CURB FACE
- CTV = CABLE TV
- SD = STORM DRAIN
- S = SEWER
- HPG = HIGH PRESSURE GAS

CURVE DATA

	R	Δ	L
⑦	15.00'	90°00'00"	23.56'
⑧	15.00'	89°59'20"	23.56'

3 inches on original drawing

4-00 RECORD DRAWINGS

ORANGE COUNTY
PUBLIC FACILITIES & RESOURCES DEPARTMENT

ROSSMOOR
SIGNATURE
WALL

PLAN AND PROFILE

DESIGNED: T. RIGONI

DRAWN: A. POPAL/JS. CHECKED: E. KWAN

SCALE: AS SHOWN DATE: 3/10/98

DRAWING NO. ER02792

SHEET 7 OF 12