 




\\\\filer2\\home\\Pham\\Microstation\\cad\\fiber\\cctv\\2-INDEX SHEET.dgn 5/6/2014 9:45 AM

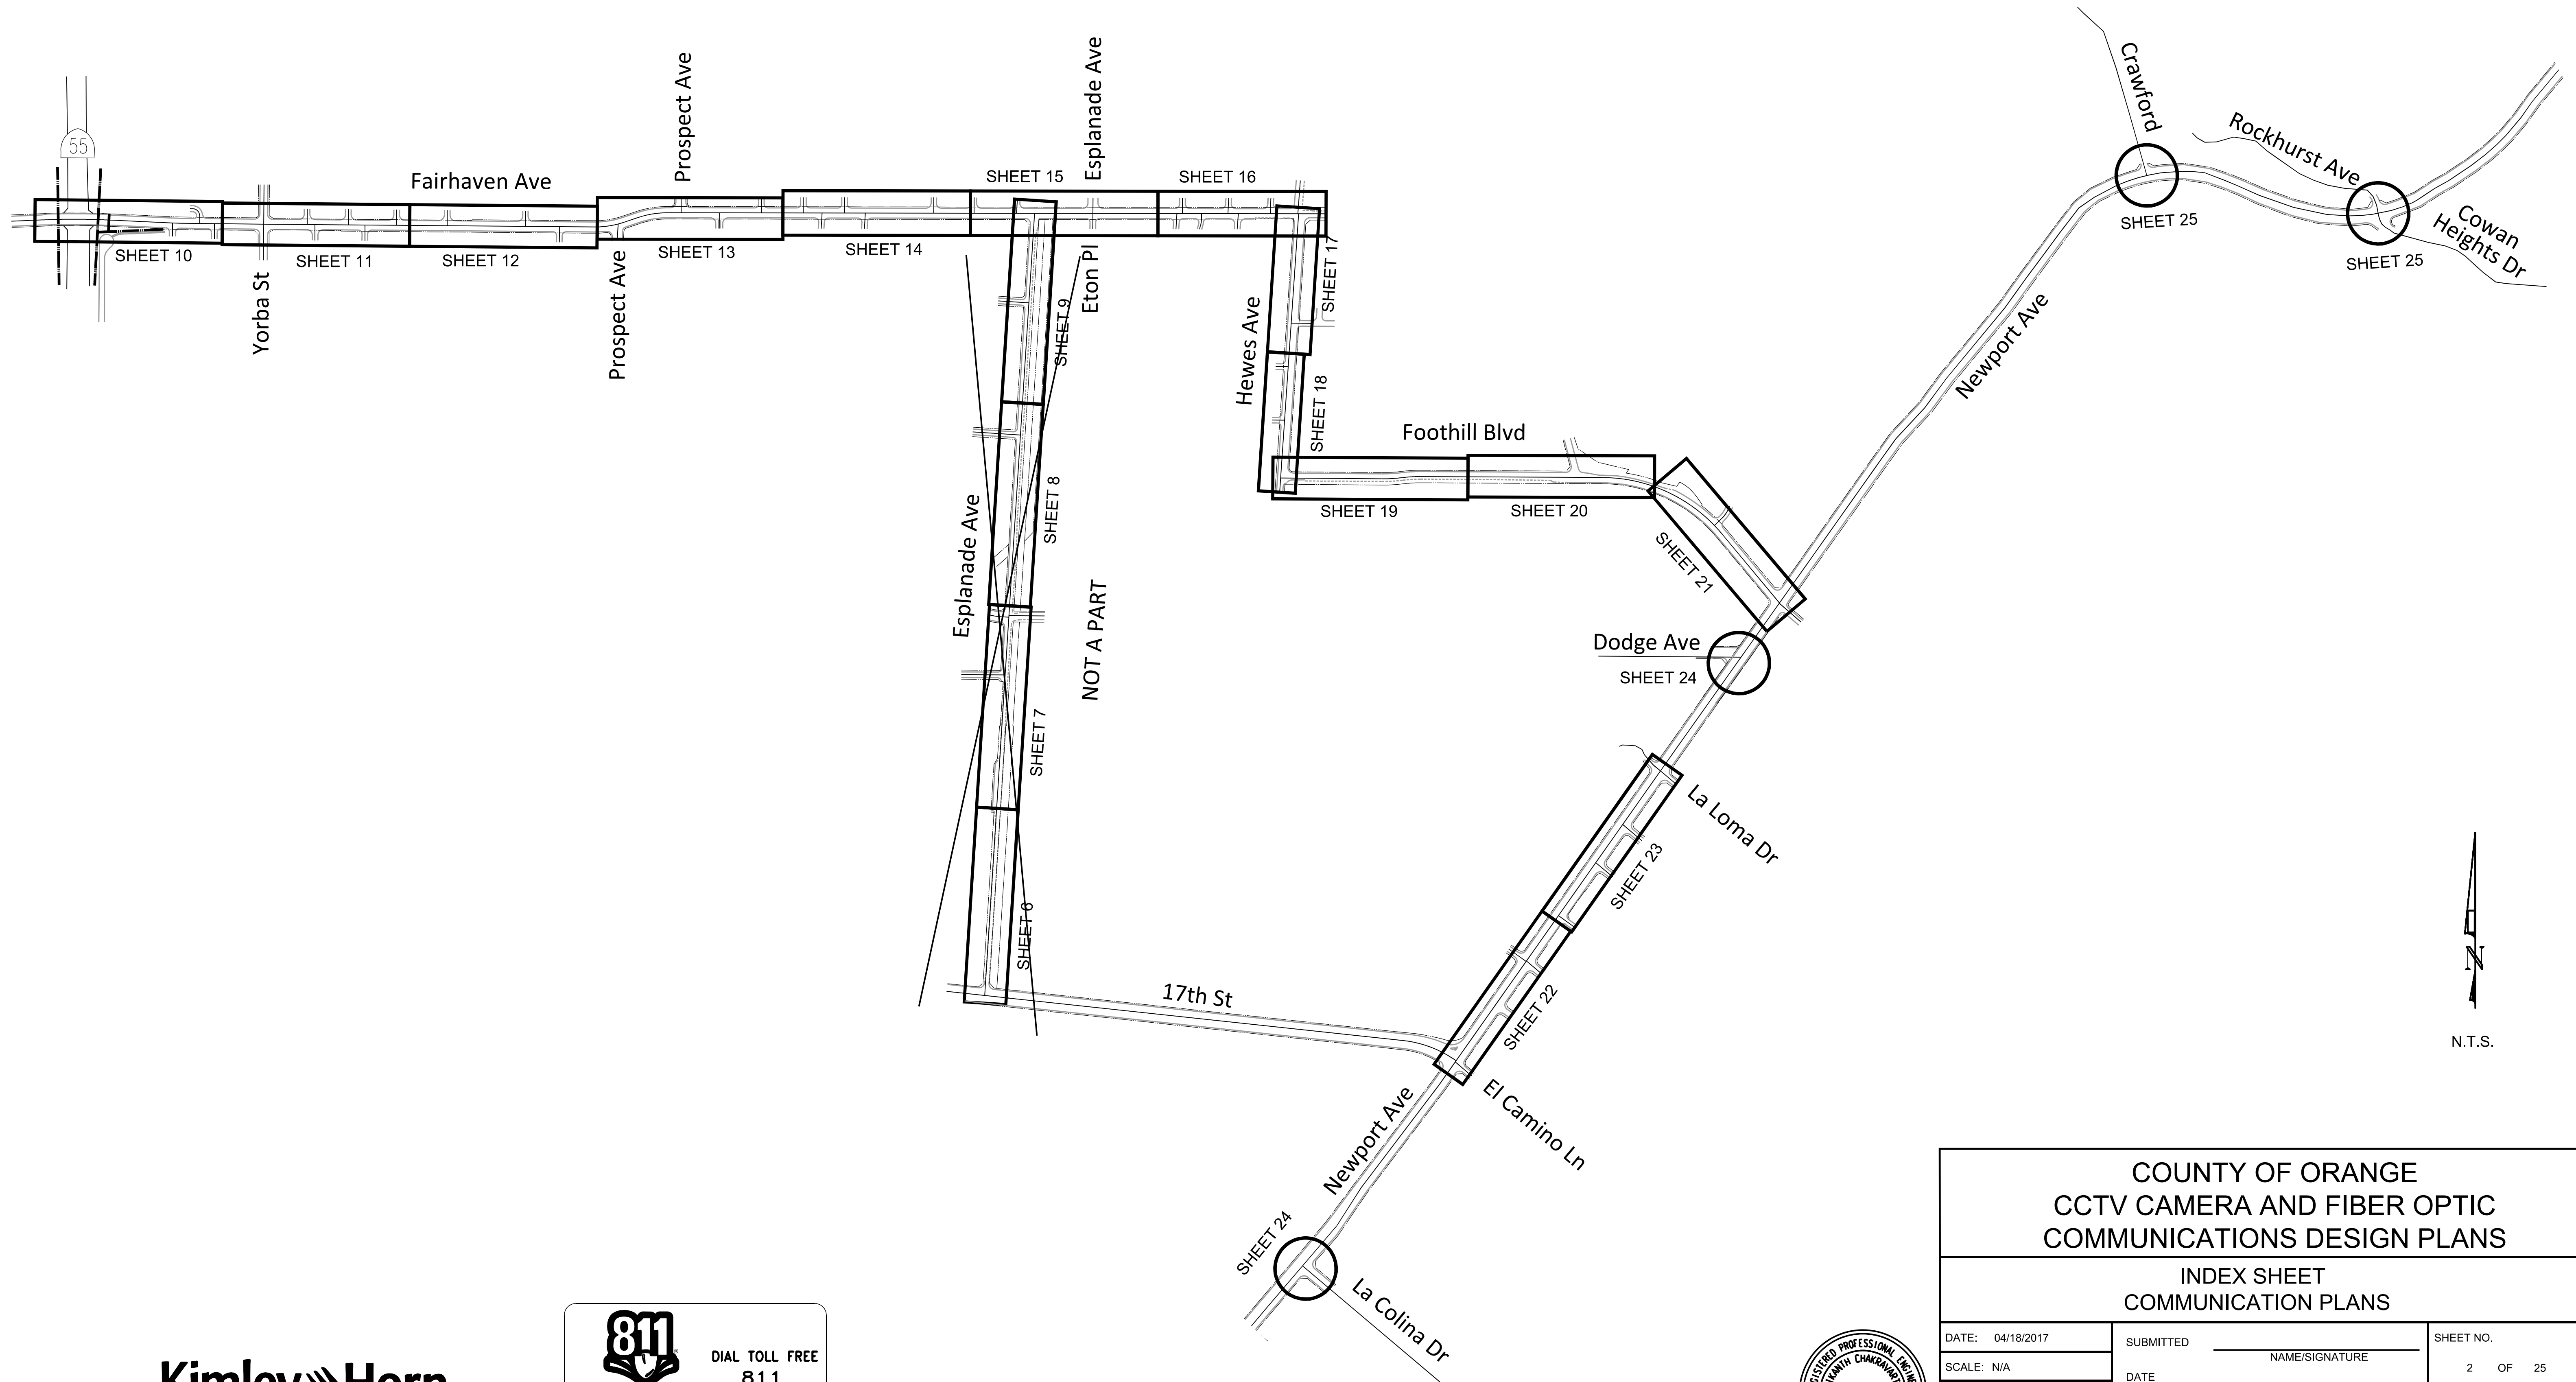

N.T.S.

Kimley»Horn

© 2017 KIMLEY-HORN AND ASSOCIATES, INC.
660 South Figueroa Street, Suite 2050, Los Angeles, CA 90017
Tel (213) 261-4040

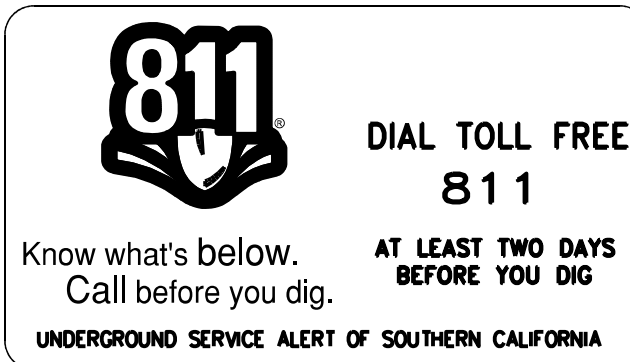

COUNTY OF ORANGE
CCTV CAMERA AND FIBER OPTIC
COMMUNICATIONS DESIGN PLANS

INDEX SHEET
COMMUNICATION PLANS

DATE: 04/18/2017	SUBMITTED _____ NAME/SIGNATURE	SHEET NO. 2 OF 25
SCALE: N/A	DATE _____	PROJECT NO. 099598001
DESIGN: JL	APPROVED _____ NAME/SIGNATURE	
DRAWN: RP/RC	DATE _____	
CHECKED: MSW		